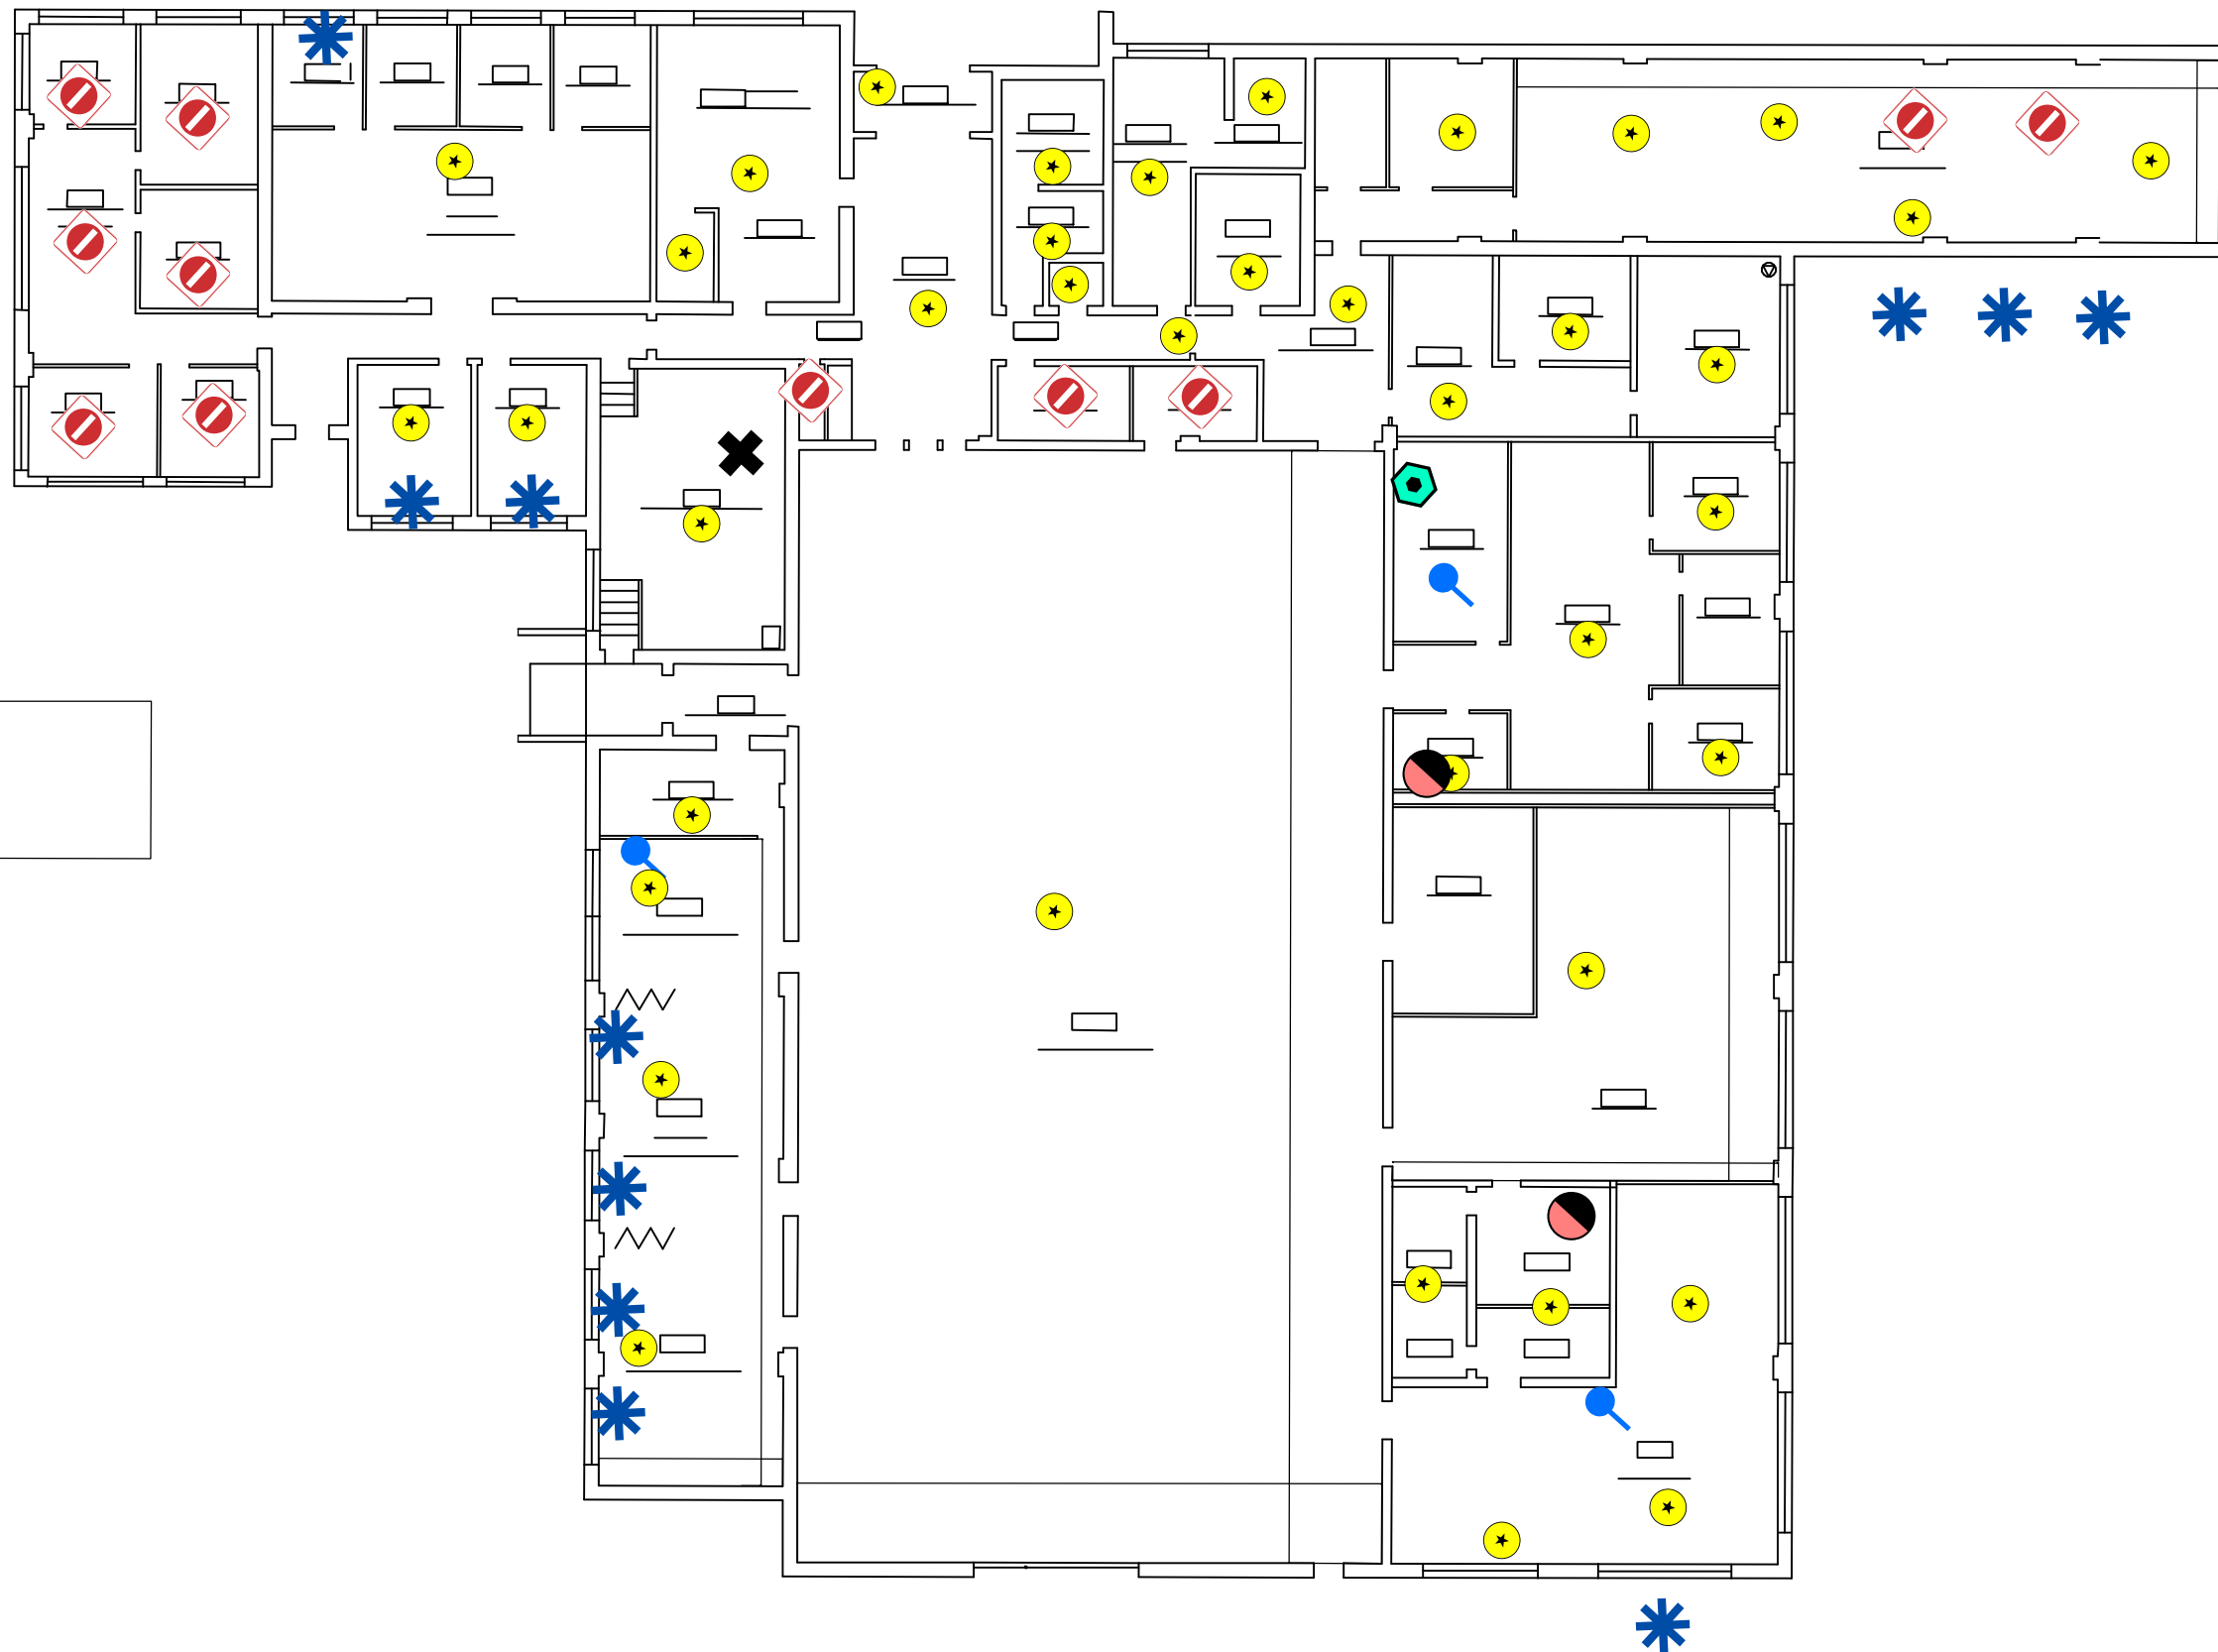









 
**Figure LD1
Site Map with
Site Level Features
Lodi Armory
Floor 1**




Legend

Lodi Armory 1st Floor

-  Air Conditioning Unit
-  Boiler
-  Light Ballast
-  No Access
-  Refrigeration Unit
-  Split Unit (Air Conditioner/Heater)
-  Water Cooler



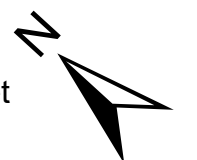1 inch = 20 feet



Notes:

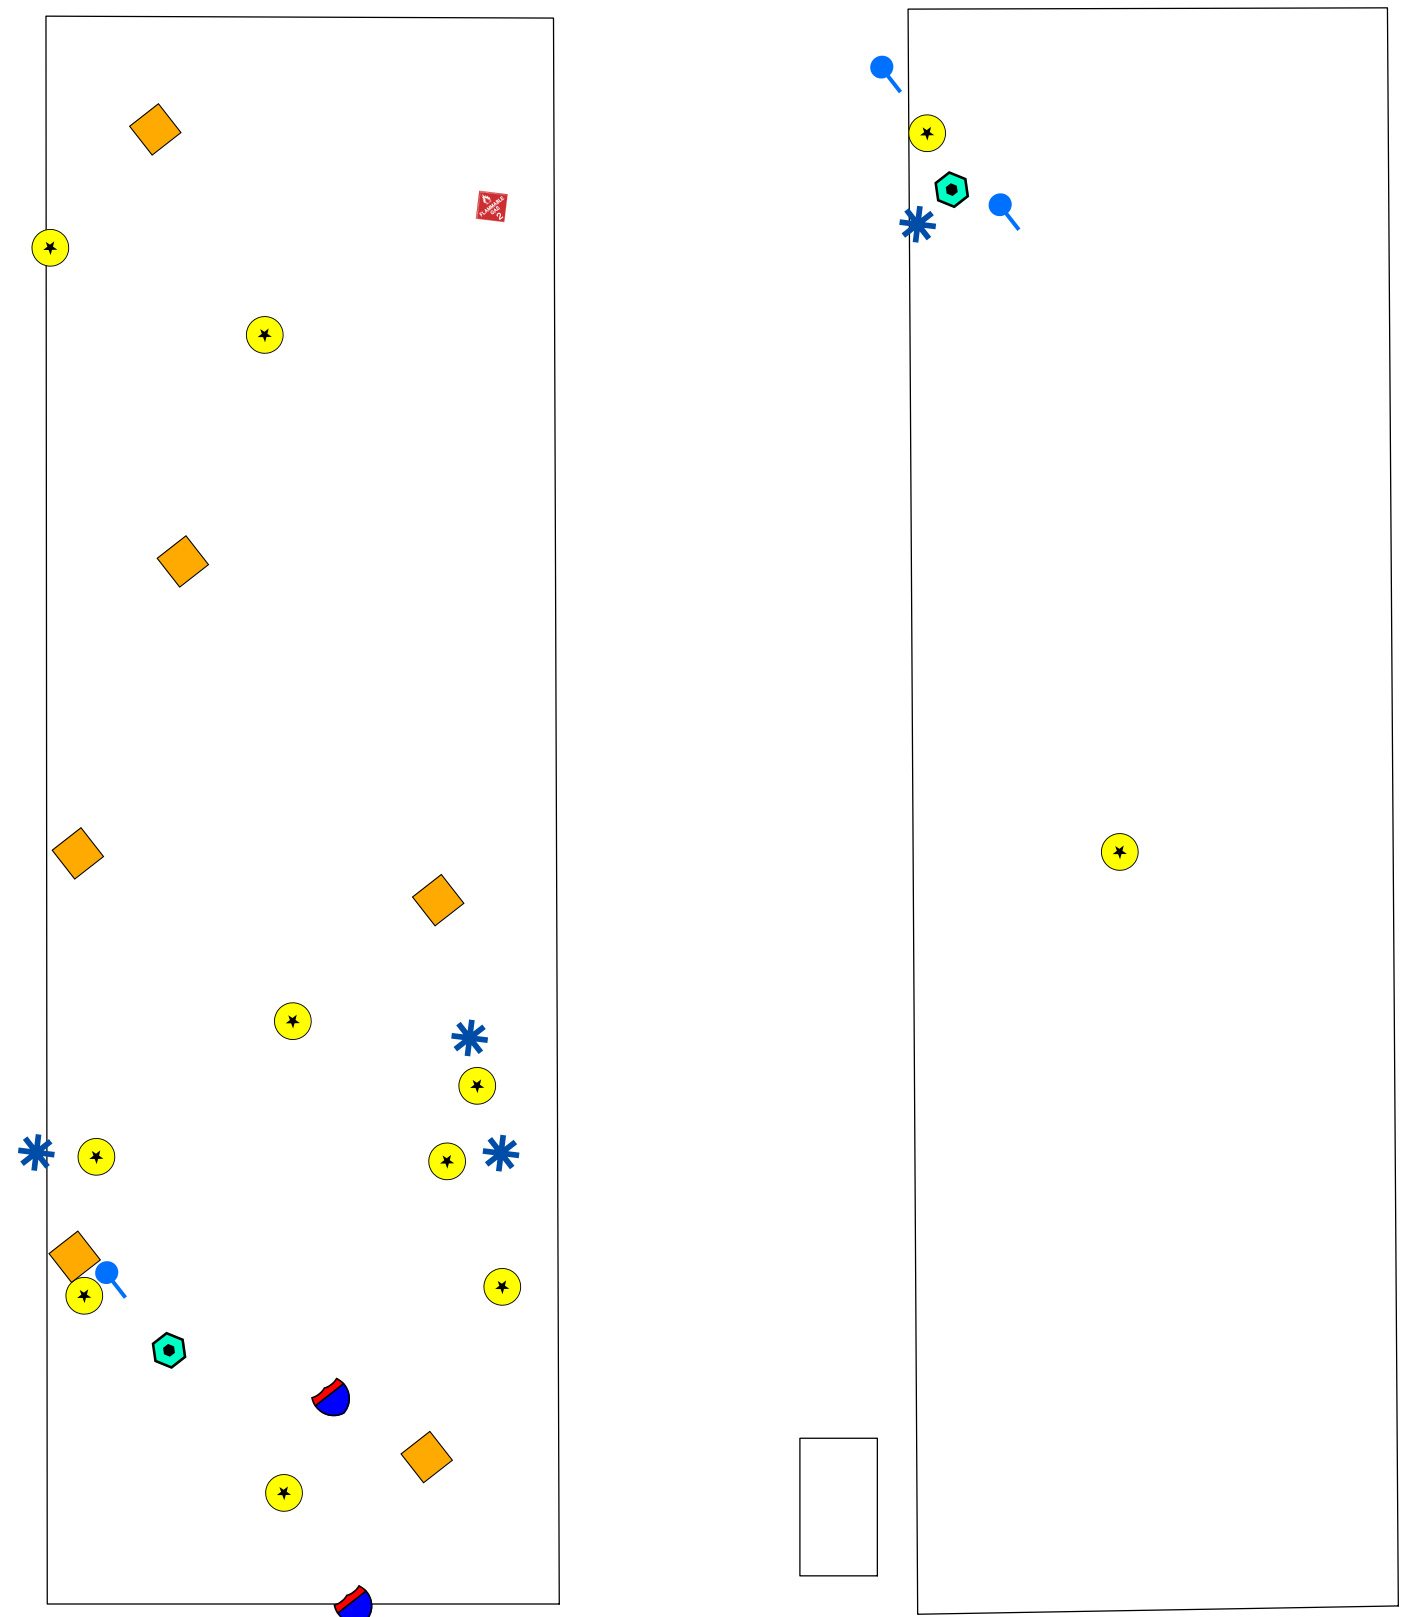
Floor plans georeferenced via headsup digitizing over 2015 aerial photography
Locations of air emissions, ODS, and FLBs georeferenced via floor plans



Scale: 1 inch = 20 feet
File: LD1
Date: 5/20/2019
Created By: Rosalie Hood,
Michael Hoffman,
Alexandria Petrosch








**Rowan
University
&
Stockton
University**


**Figure LD2
Site Map with
Site Level Features
Lodi MSVB 1&2
Floor 1**



Legend

MVSB 1&2

 -  Air Conditioning Unit
-  Flammable Cabinet
-  Forced Air Heater
-  Light Ballast
-  Refrigeration Unit
-  Vehicle Recovery Air Conditioning Unit
-  Water Cooler



1 inch = 25 feet



Notes:

Floor plans georeferenced via headsup digitizing over 2015 aerial photography
Locations of air emissions, ODS, and FLBs georeferenced via floor plans



Scale: 1 inch = 25 feet
File: LD2
Date: 5/20/2019
Created By: Rosalie Hood,
Tim Ivancich,
Alexandria Petrosch

**Rowan
University
&
Stockton
University**

*

**Figure MN1
Site Map with
Site Level Features
Morristown Armory
Floor 1**

Legend

Morristown Armory 1st Floor

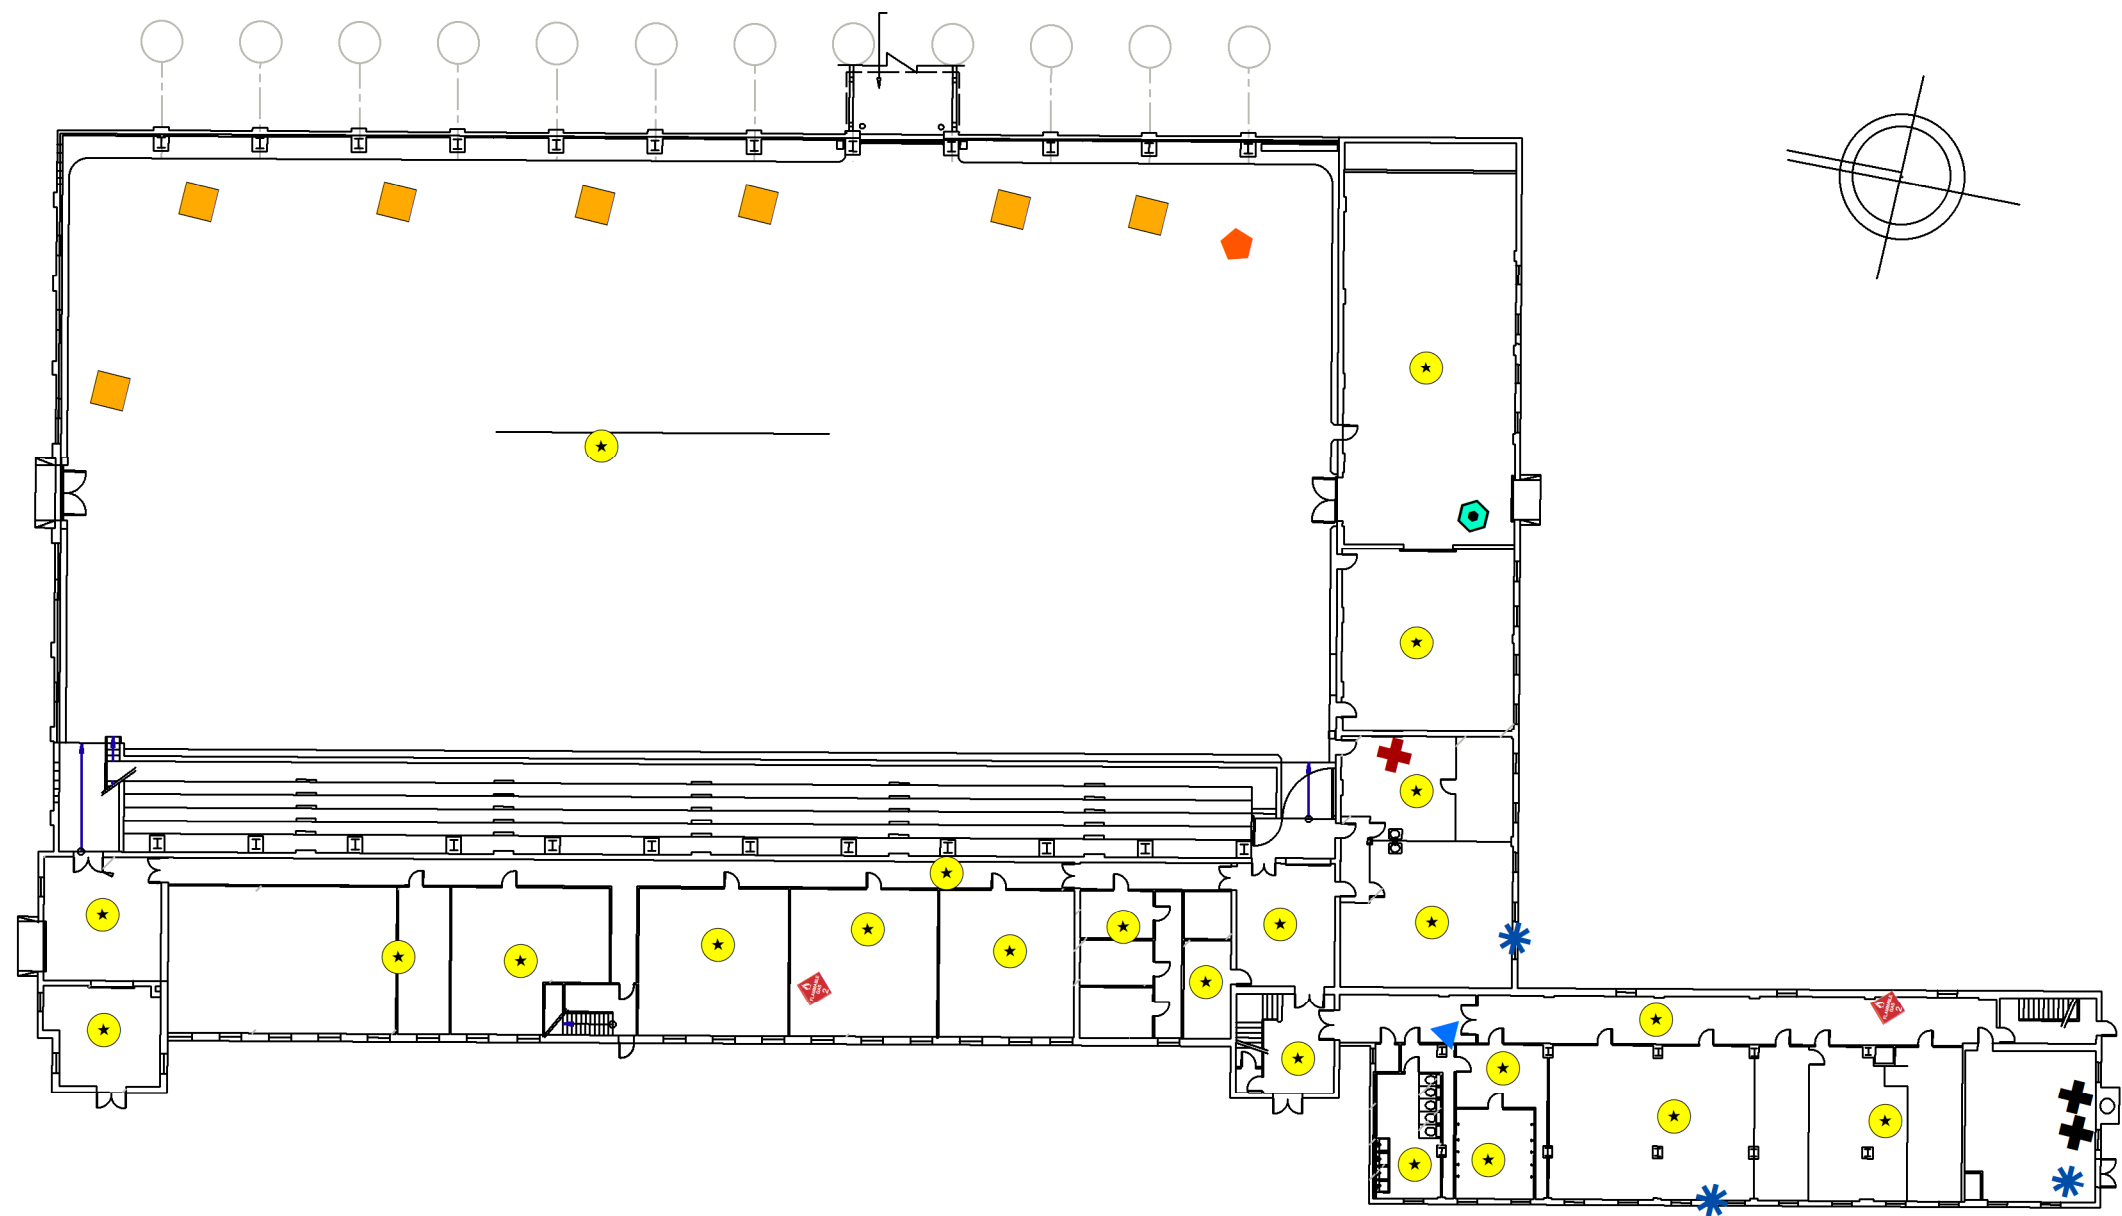
- ▲ Above Ground Storage Tank
- * Air Conditioning Unit
- ⊕ Boiler
- ◆ Dehumidifying Unit
- ▲ Drinking Water Fountain
- ◆ Flammable Cabinet
- Forced Air Heater
- ⊕ Kegerator
- Light Ballast
- ⊖ No Access
- ▽ No FLBs
- ⬢ Refrigeration Unit

0 20 40 80 Feet
1 inch = 40 feet



Notes:


Floor plans georeferenced via headsup digitizing over 2015 aerial photography
Locations of air emissions, ODS, and FLBs georeferenced via floor plans



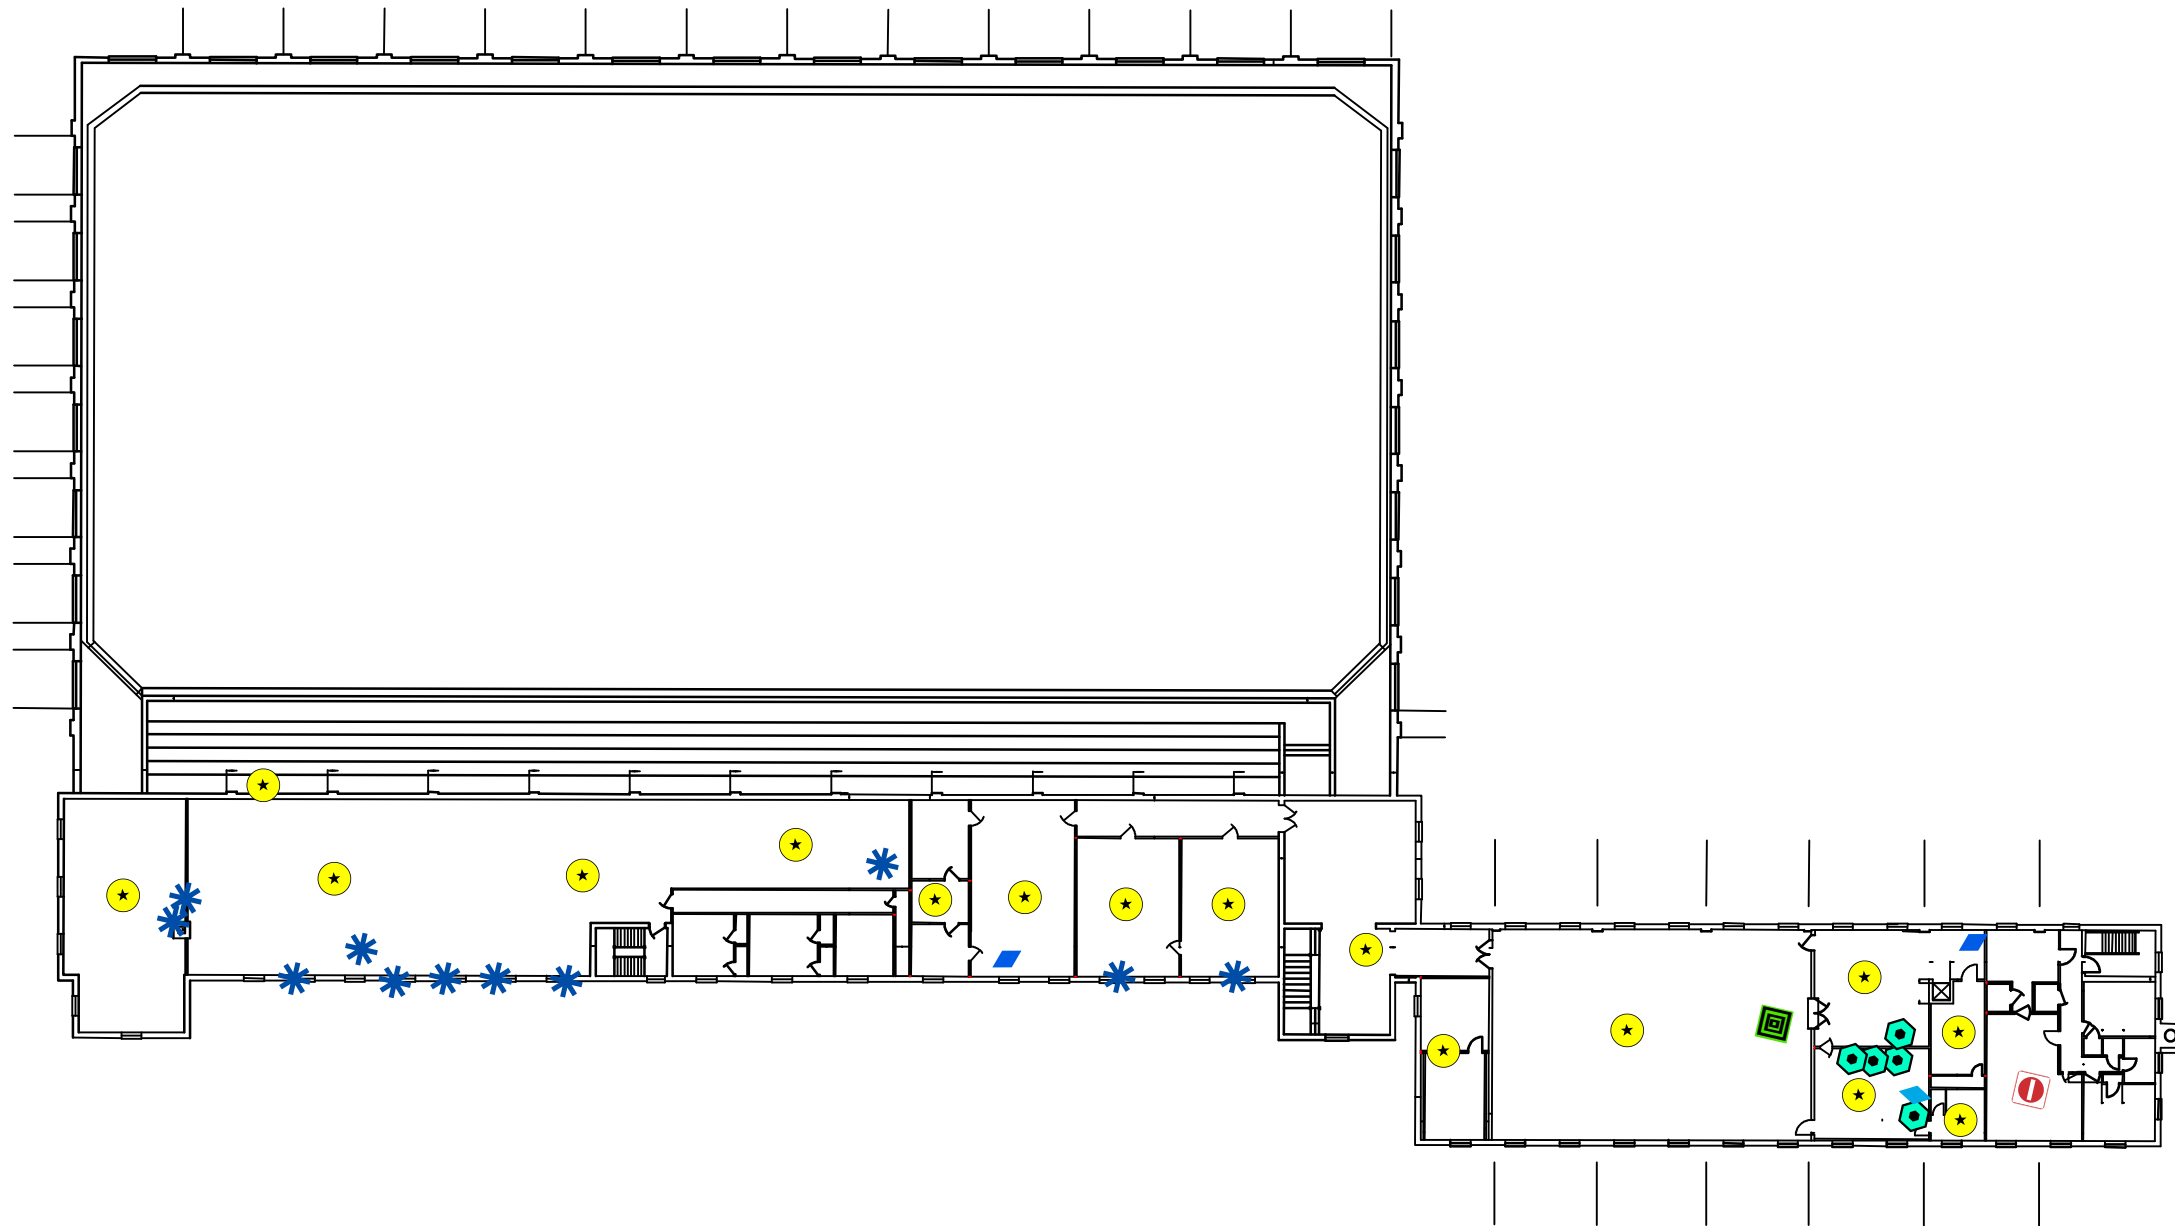Scale: 1 inch = 40 feet
File: MN1
Date: 5/20/2019
Created By: Rosalie Hood
Anne Timmreck,
Raina Ryan,
Alexandria Petrosch








**Rowan
University
&
Stockton
University**


**Figure MN2
Site Map with
Site Level Features
Morristown Armory
Floor 2**



Legend

Morristown Armory 2nd Floor

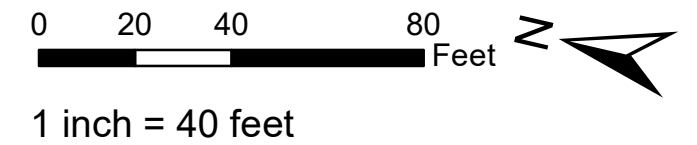-  Air Conditioning Unit
-  Chilled Serving Counter
-  Freezer Unit
-  Ice Machine
-  No Access
-  Refrigeration Unit
-  Light Ballast



Notes:

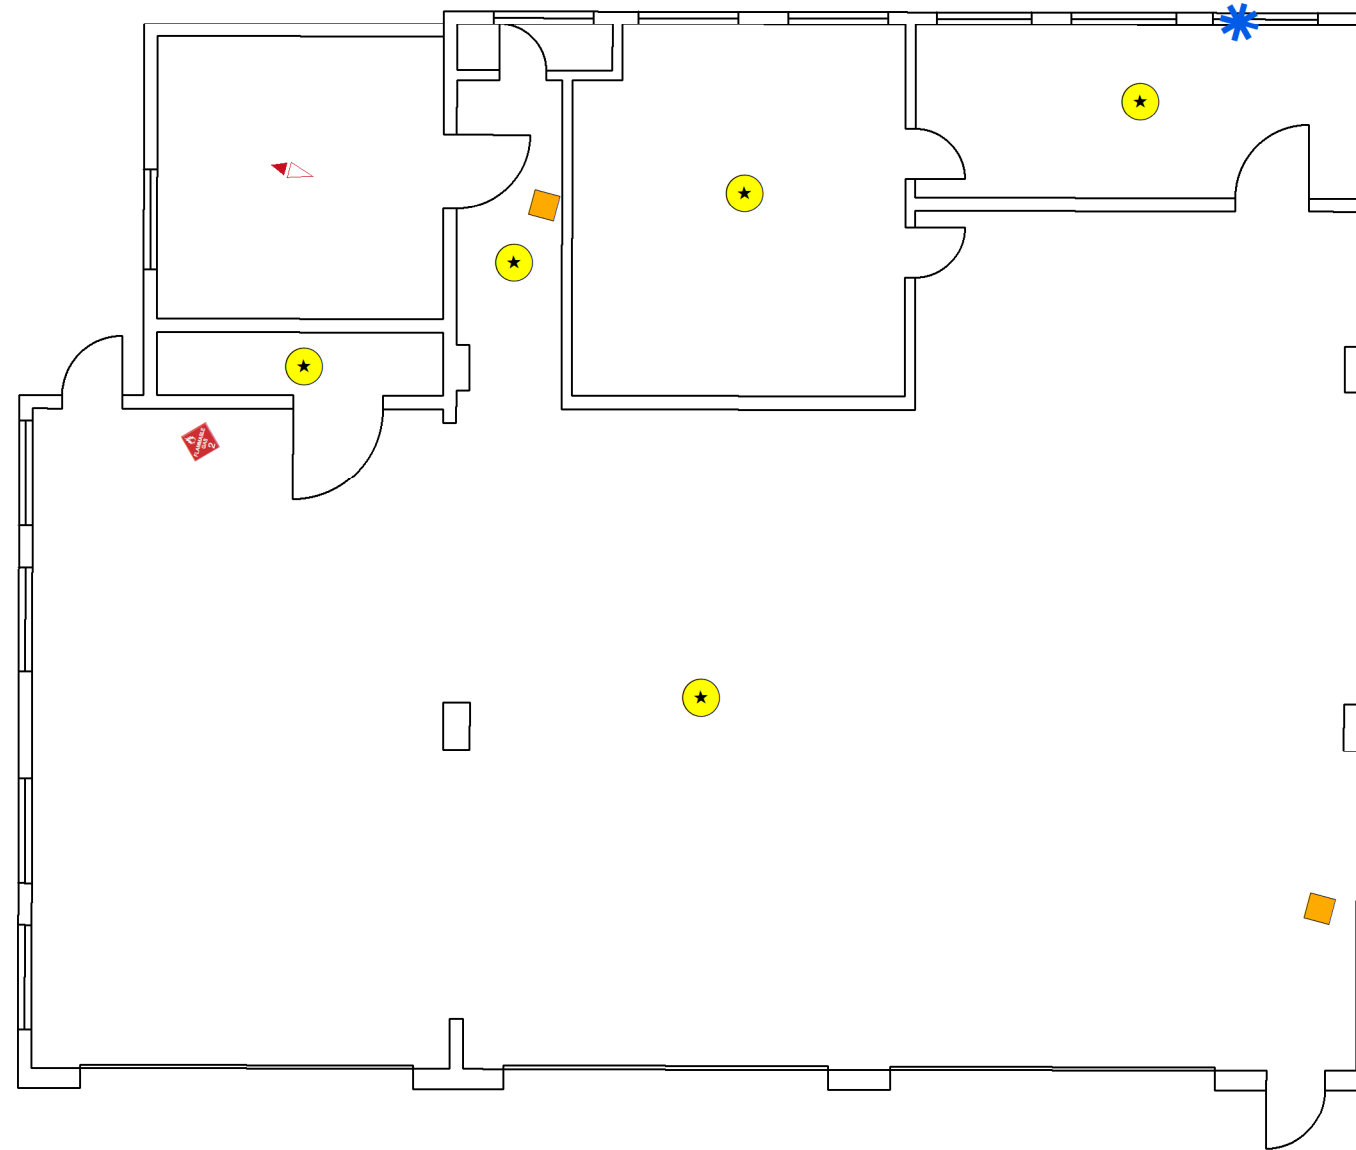
Floor plans georeferenced via headsup digitizing over 2015 aerial photography
Locations of air emissions, ODS, and FLBs georeferenced via floor plans



Scale: 1 inch = 40 feet
File: MN2
Date: 5/20/2019
Created By: Rosalie Hood
Anne Timmreck,
Raina Ryan,
Alexandria Petrosch






**Rowan
University
&
Stockton
University**


**Figure MN3
Site Map with
Site Level Features
Morristown Armory
OMS**



Legend

Morristown OMS 1st_Floor

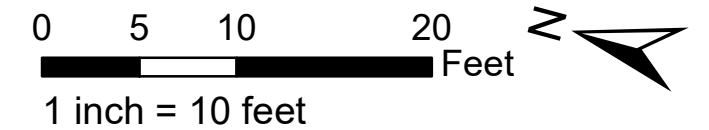-  Air Conditioning Unit
-  Flammable Cabinet
-  Forced Air Heater
-  Light Ballast
-  No FLBs



Notes:

Floor plans georeferenced via headsup digitizing over 2015 aerial photography
Locations of air emissions, ODS, and FLBs georeferenced via floor plans



Scale: 1 inch = 10 feet
File: MN3
Date: 5/20/2019
Created By: Rosalie Hood,
Anne Timmreck,
Raina Ryan,
Alexandria Petrosch










**Rowan
University
&
Stockton
University**

**Figure MY1
Site Map with
Site Level Features
Mount Holly Armory
Floor 1**



Legend

Mount Holly Armory 1st Floor

-  Air Conditioning Condenser Unit
-  Boiler
-  Drinking Water Fountain
-  Ice Machine
-  Light Ballast
-  No Access
-  No FLBs
-  Parts Washer
-  Refrigeration Unit

0 7.5 15 30 Feet
1 inch = 15 feet



Notes:


Floor plans georeferenced via headsup digitizing over 2015 aerial photography
Locations of air emissions, ODS, and FLBs georeferenced via floor plans



Scale: 1 inch = 15 feet
File: MY1
Date: 5/20/2019
Created By: Jon McKinnon,
Michael Hoffman,
Alexandria Petrosch


**Rowan
University
&
Stockton
University**

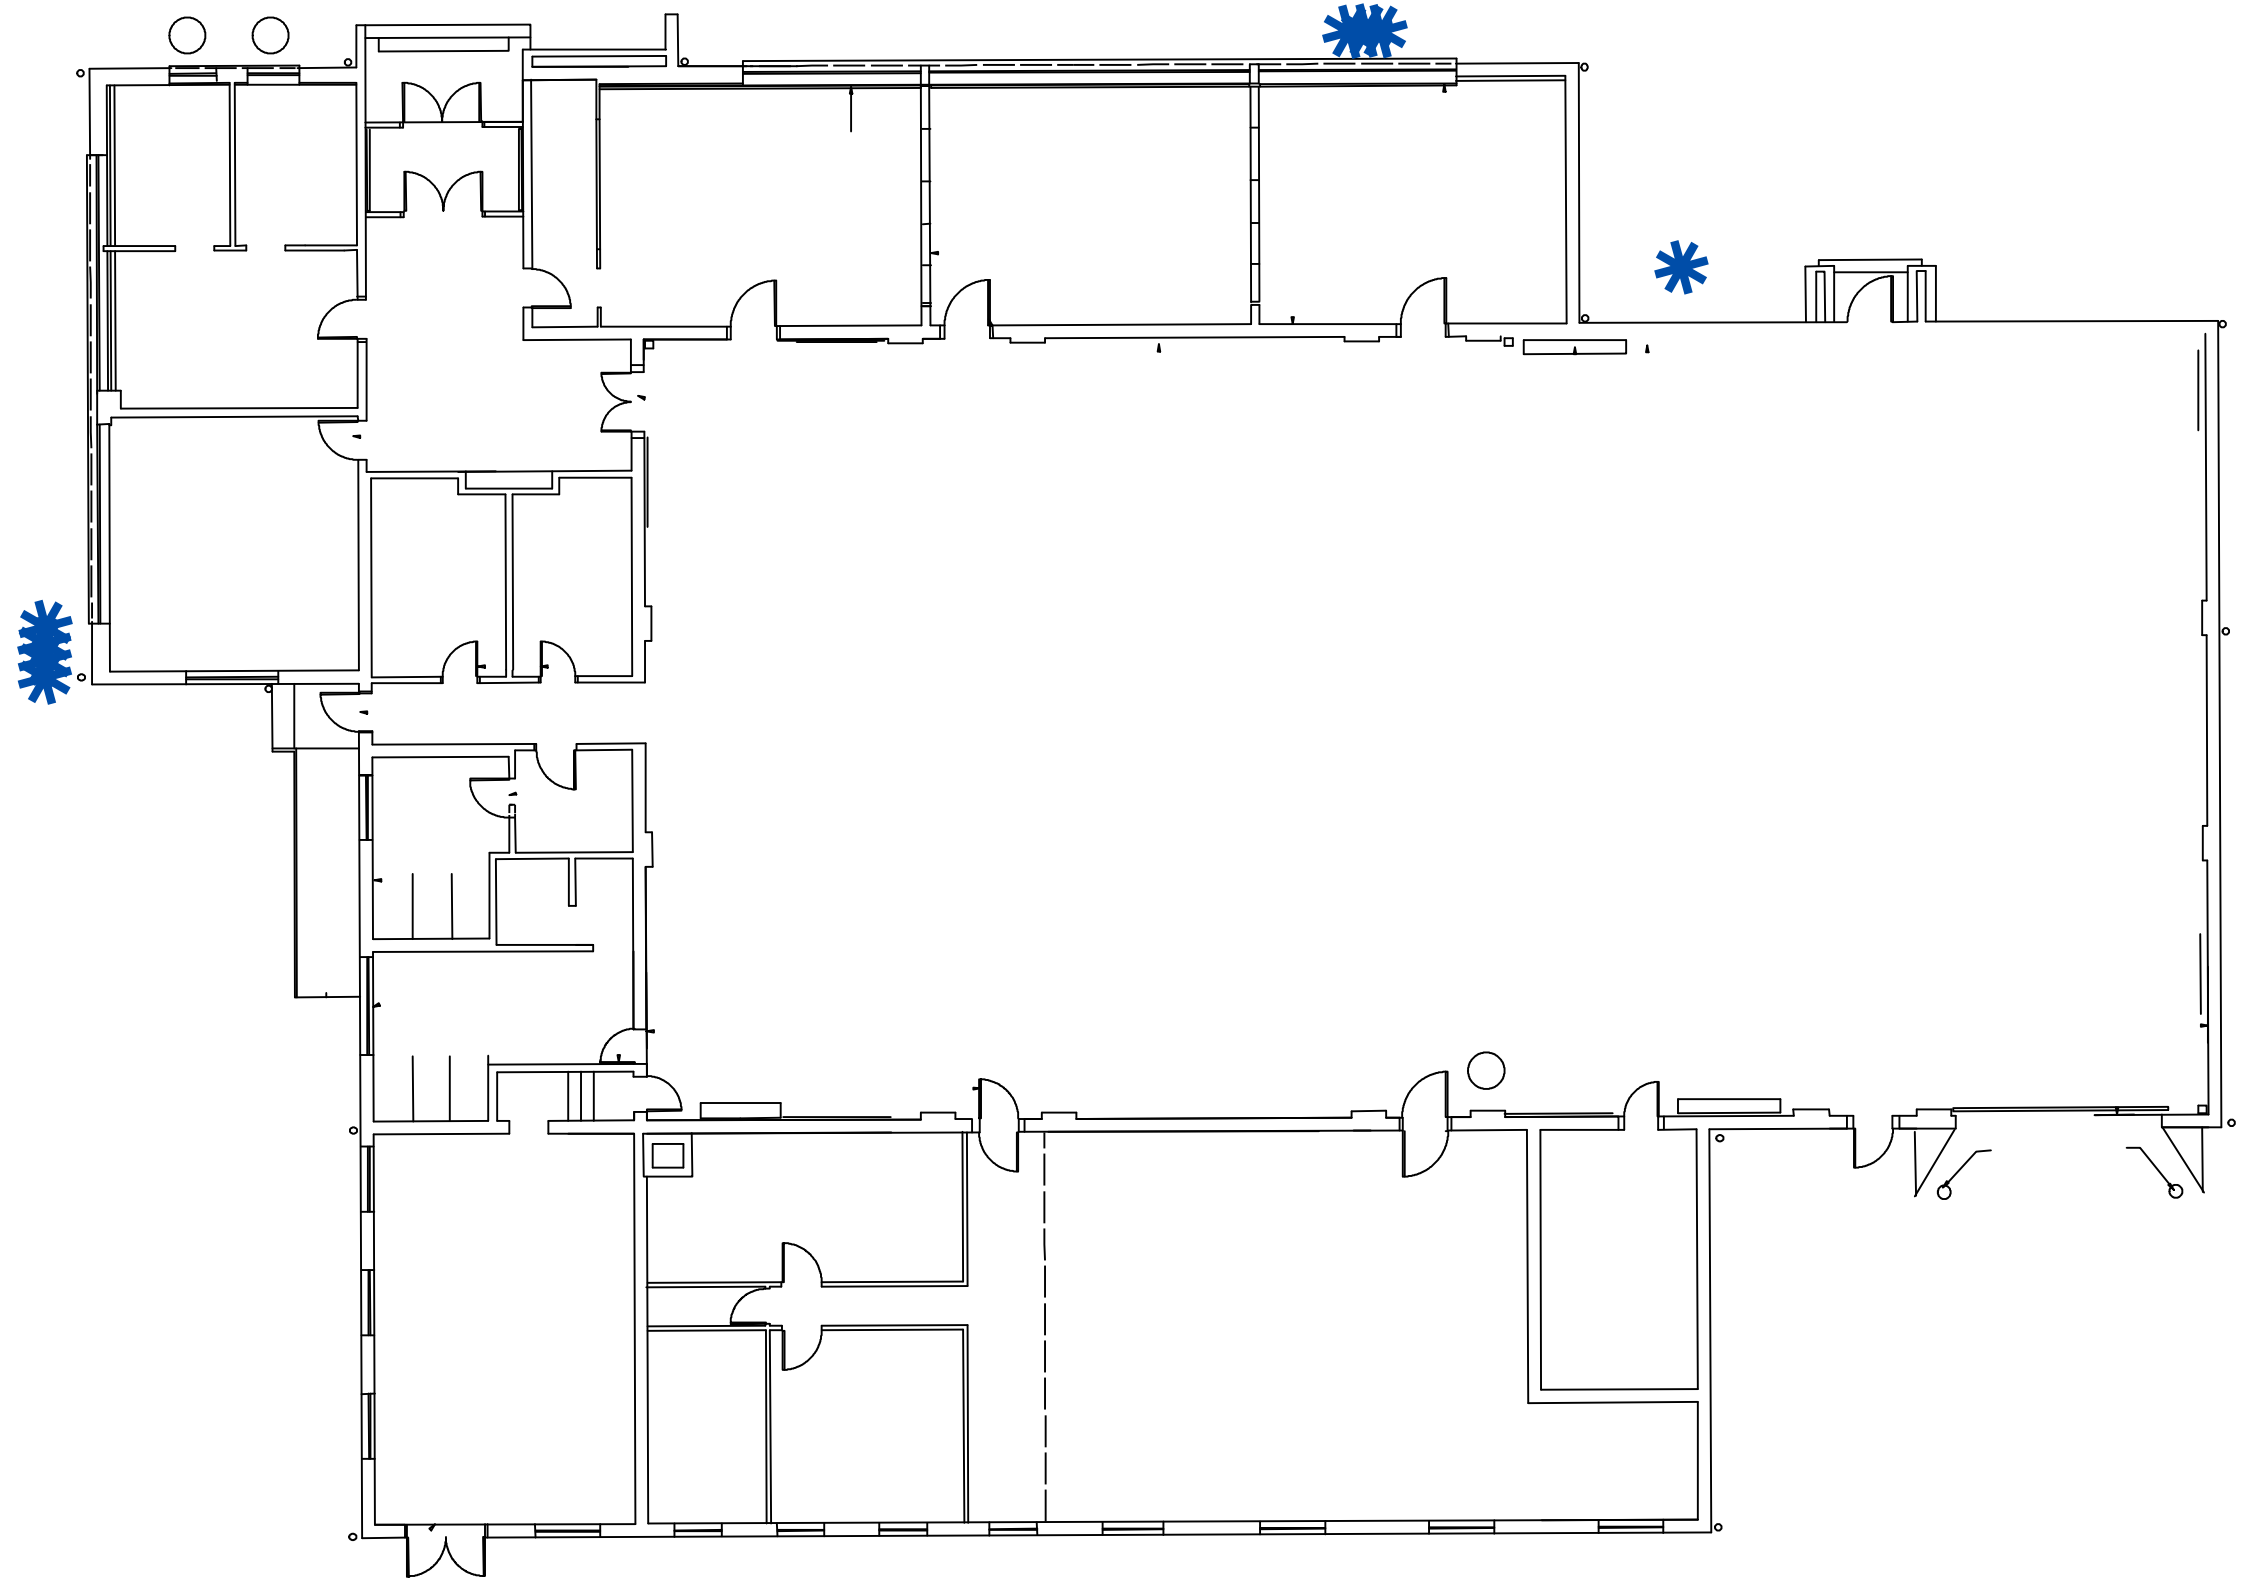**Figure MY2
Site Map with
Site Level Features
Mount Holly Armory
Outside**



Legend

Mount Holly Armory Outside

 Air Conditioning Condenser Unit

0 7.5 15 30 Feet

1 inch = 15 feet



Notes:


Floor plans georeferenced via headsup digitizing over 2015 aerial photography
Locations of air emissions, ODS, and FLBs georeferenced via floor plans



Scale: 1 inch = 15 feet
File: MY2
Date: 5/20/2019
Created By: Jon McKinnon,
Michael Hoffman,
Alexandria Petros

**Rowan
University
&
Stockton
University**

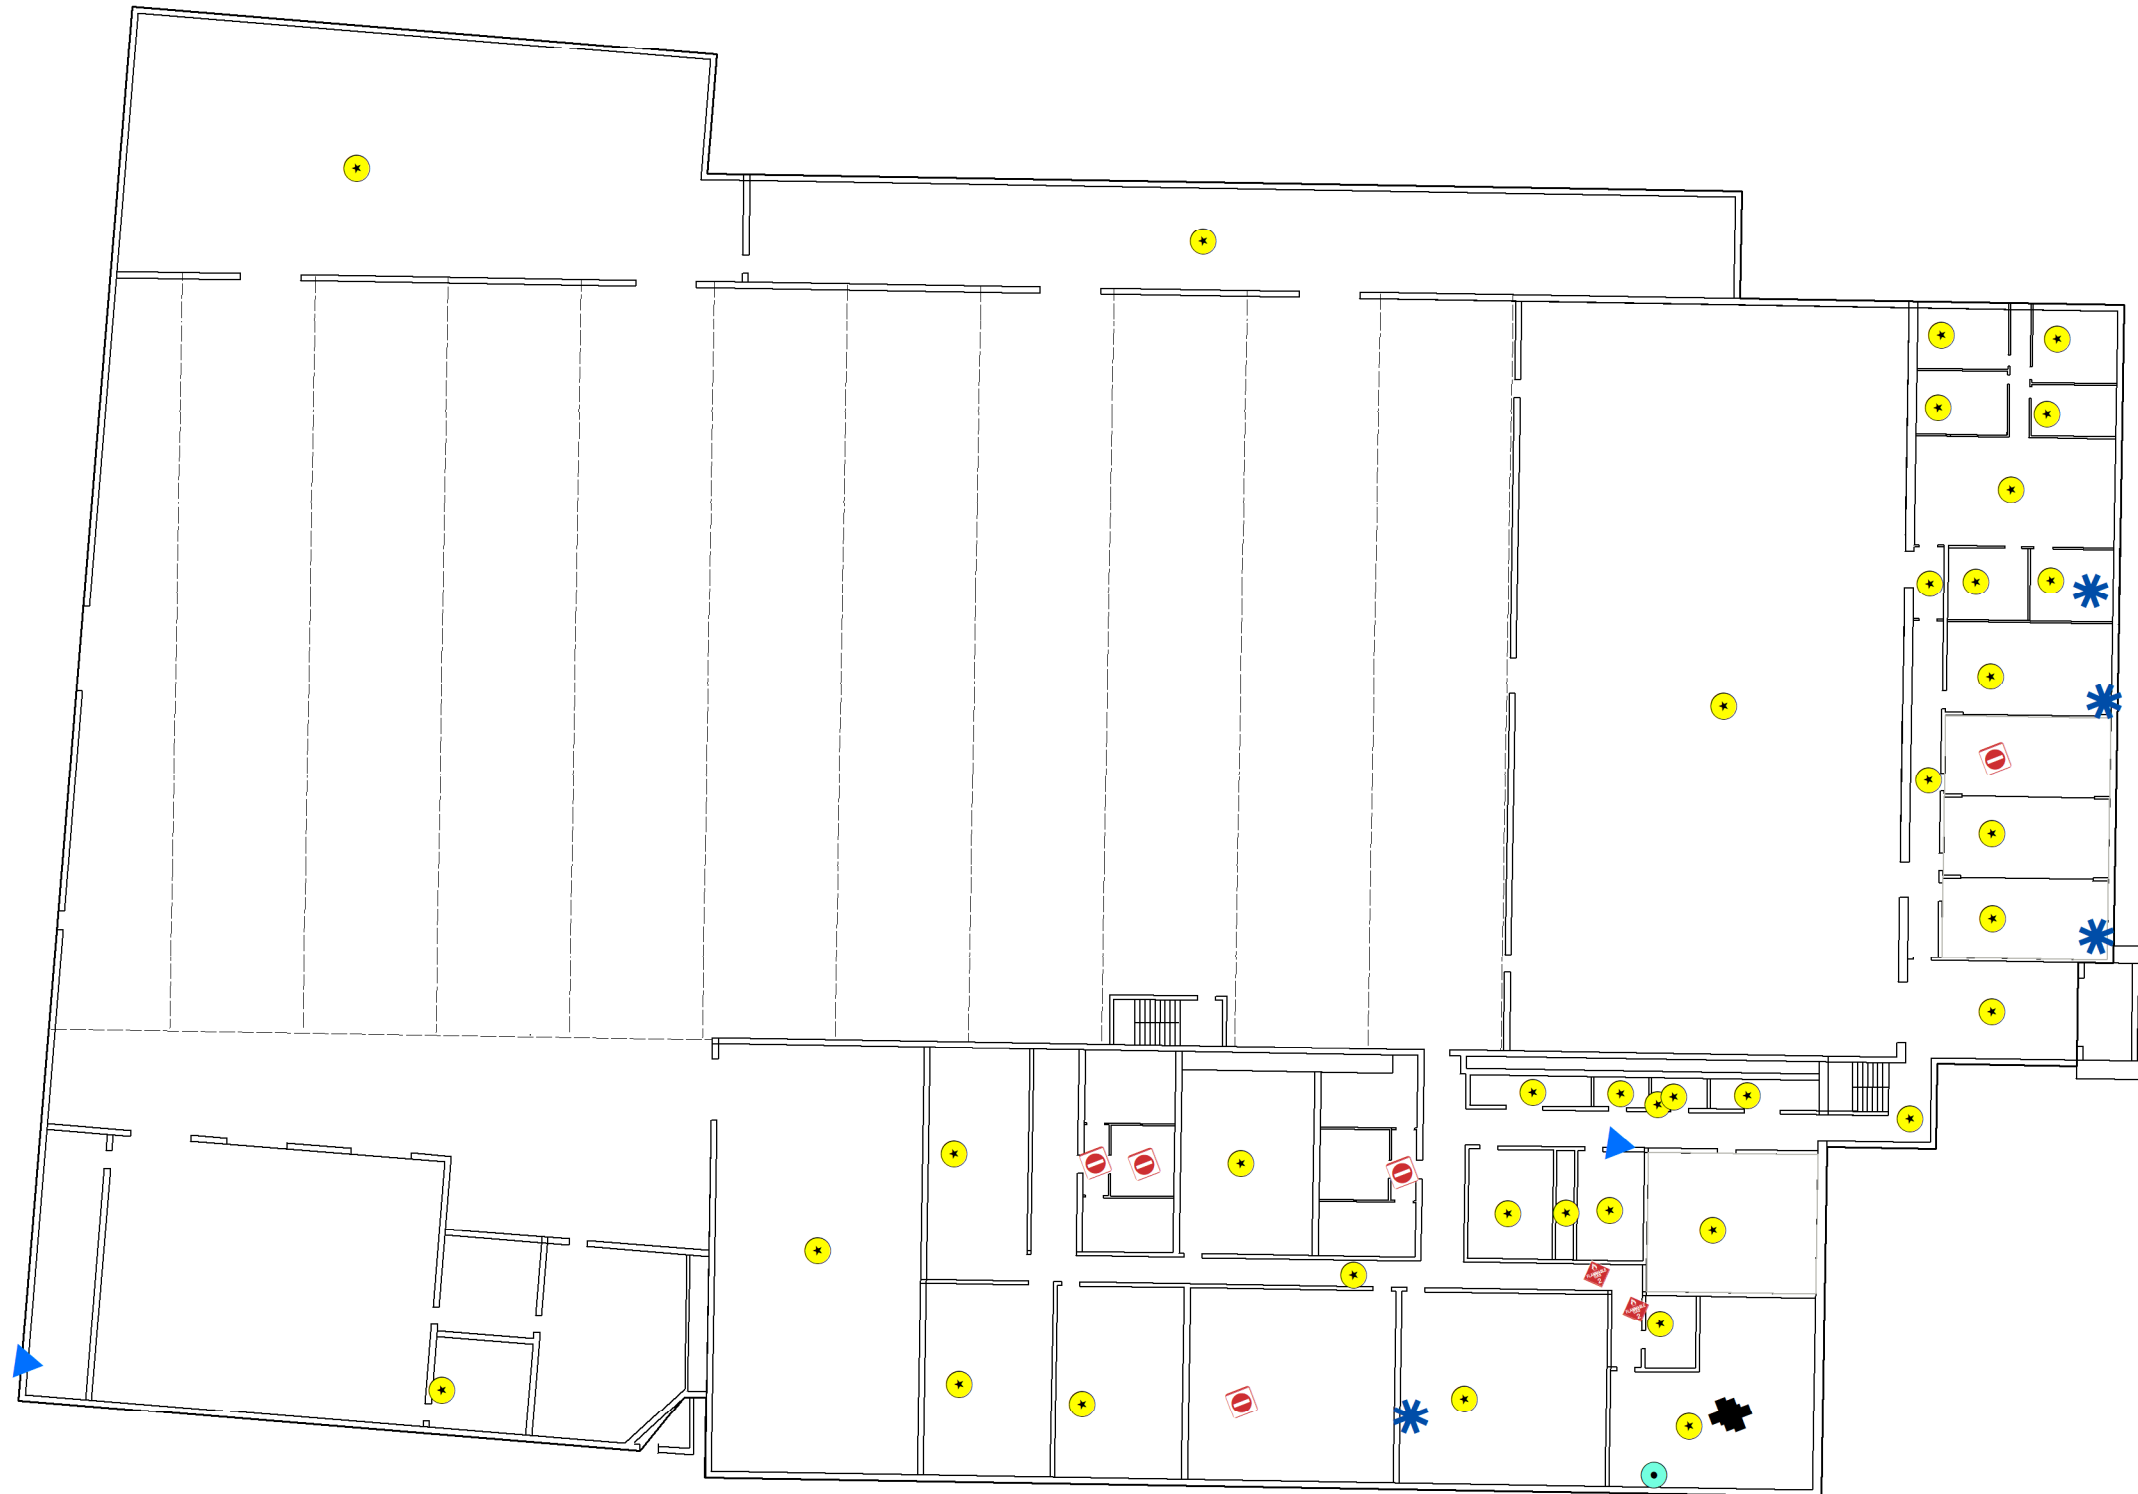**Figure NK1
Site Map with
Site Level Features
Newark Armory
Floor 1**



Legend

Newark Armory 1st Floor

- Air Conditioning Unit
- Boiler
- Drinking Water Fountain
- Flammable Cabinet
- Hot Water Heater
- Light Ballast
- No Access
- No FLBs
- Split Unit (Air Conditioner/Heater)

0 15 30 60 Feet

1 inch = 30 feet



Notes:

Floor plans georeferenced via headsup digitizing over 2015 aerial photography
Locations of air emissions, ODS, and FLBs georeferenced via floor plans



Scale: 1 inch = 30 feet
File: NK1
Date: 5/20/2019
Created By: Rosalie Hood,
Michael Hoffman,
Alexandria Petrosch

**Rowan
University
&
Stockton
University**

**Figure NK2
Site Map with
Site Level Features
Newark Armory
Floor 2**



Legend

Newark Armory 2nd Floor

- Air Conditioning Unit
- Drinking Water Fountain
- Hot Water Heater
- Ice Machine
- Light Ballast
- Refrigeration Unit
- No Access

0 15 30 60 Feet

1 inch = 30 feet



Notes:

Floor plans georeferenced via headsup digitizing over 2015 aerial photography
Locations of air emissions, ODS, and FLBs georeferenced via floor plans








Scale: 1 inch = 30 feet
File: NK2
Date: 5/20/2019
Created By: Rosalie Hood,
Michael Hoffman,
Alexandria Petrosch

**Rowan
University
&
Stockton
University**

**Figure NK3
Site Map with
Site Level Features
Newark OMS
Floor 1**

Legend

Newark OMS

-  Air Conditioning Unit
-  Drinking Water Fountain
-  Flammable Cabinet
-  Light Ballast
-  Forced Air Heater

0 5 10 20
Feet

1 inch = 10 feet



Notes:

Floor plans georeferenced via headsup digitizing
over 2015 aerial photography
Locations of air emissions, ODS, and FLBs georeferenced
via floor plans



Scale: 1 inch = 10 feet

File: NK3


Date: 5/20/2019

Created By: Rosalie Hood,
Michael Hoffman,
Alexandria Petrosch

**Rowan
University
&
Stockton
University**





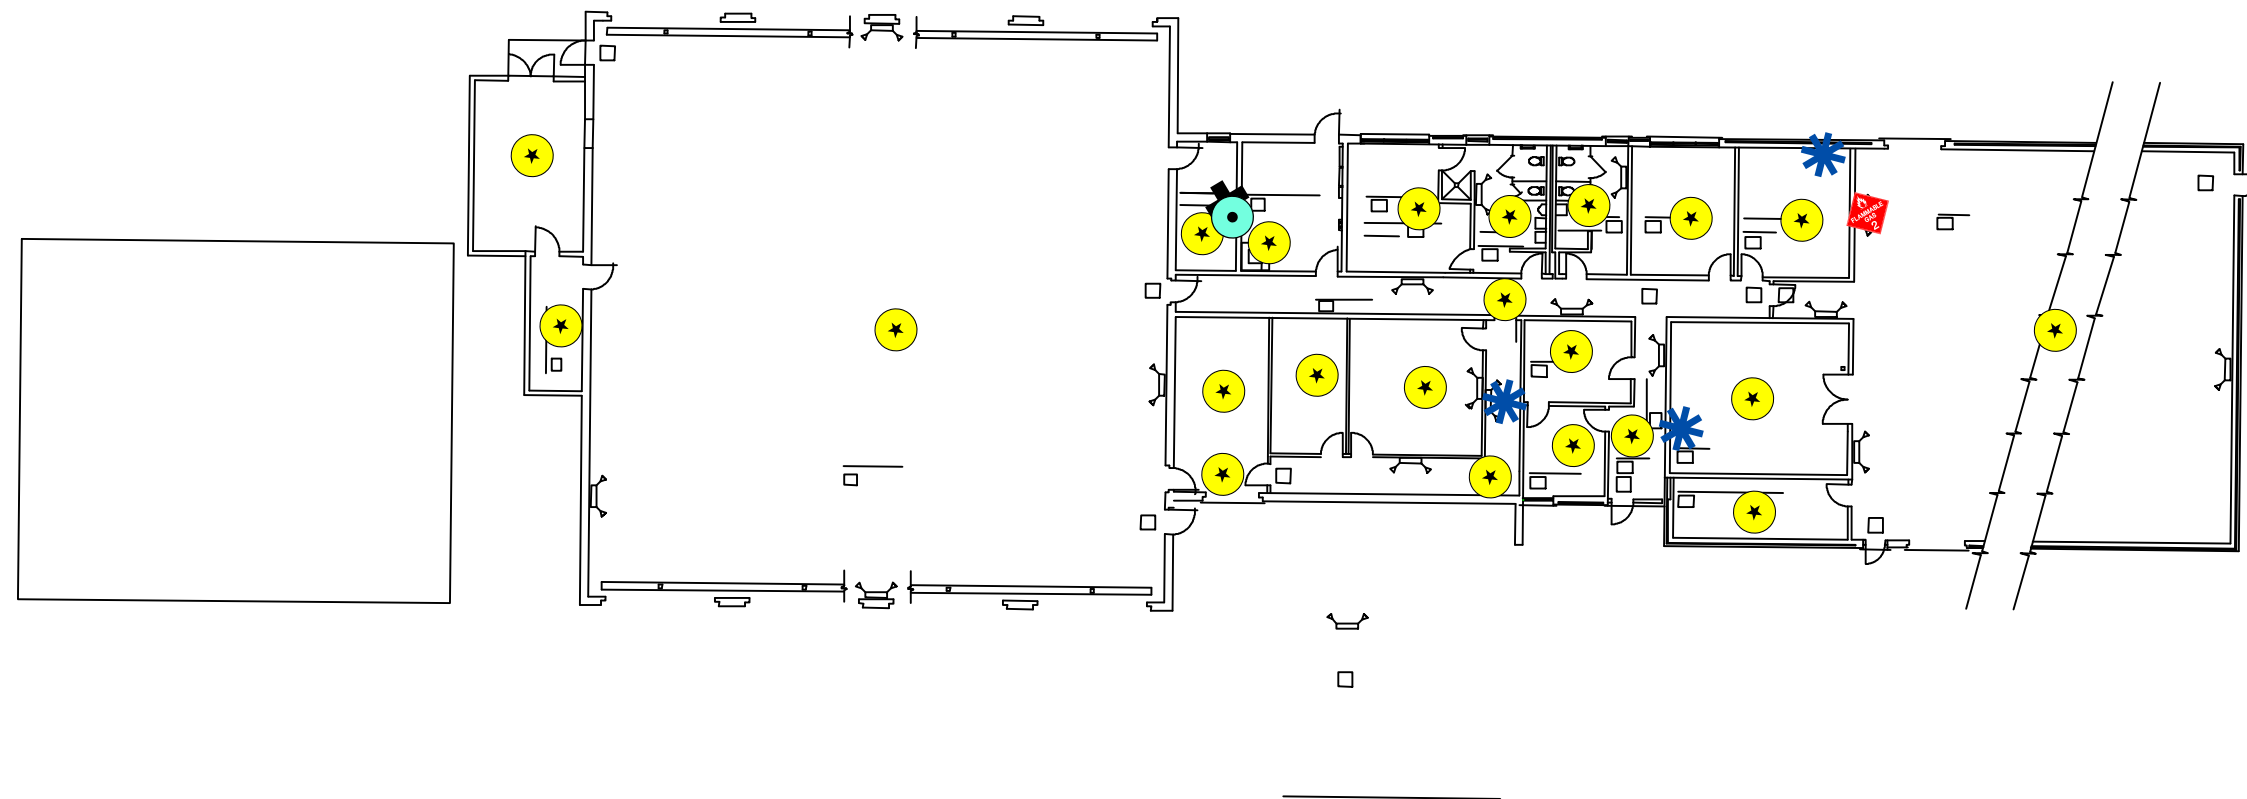


**Figure OU1
Site Map with
Site Level Features
Old UTES
Floor 1**



Legend

Old UTES Armory 1st Floor

-  Air Conditioning Unit
-  Boiler
-  Flammable Cabinet
-  Hot Water Heater
-  Light Ballast

0 17.5 35 70 Feet

1 inch = 35 feet



Notes:

Floor plans georeferenced via headsup digitizing over 2015 aerial photography
Locations of air emissions, ODS, and FLBs georeferenced via floor plans















Scale: 1 inch = 35 feet
File: OU1
Date: 5/20/2019
Created By: Rosalie Hood,
Michael Hoffman,
Alexandria Petrosch

**Rowan
University
&
Stockton
University**

**Figure PY1
Site Map with
Site Level Features
Picatinny Armory
Floor 1**

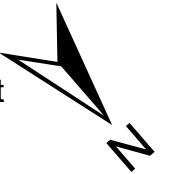
Legend

Picatinny Armory 1st Floor

-  Air Conditioning Unit
-  Boiler
-  Compressed Air Dryer
-  Drinking Water Fountain
-  Flammable Cabinet
-  Hot Water Heater
-  Light Ballast
-  No Access
-  No FLBs
-  Recovery Unit
-  Refrigeration Unit
-  Welding Operation

0 7.5 15 30 Feet

1 inch = 15 feet



Notes:

Floor plans georeferenced via headsup digitizing over 2015 aerial photography
Locations of air emissions, ODS, and FLBs georeferenced via floor plans



FIRST FLOOR PLAN



Scale: 1 inch = 15 feet
File: PY1
Date: 5/20/2019
Created By: Rosalie Hood,
Tim Ivanchich,
Alexandria Petrosch

Rowan
University
&
Stockton
University

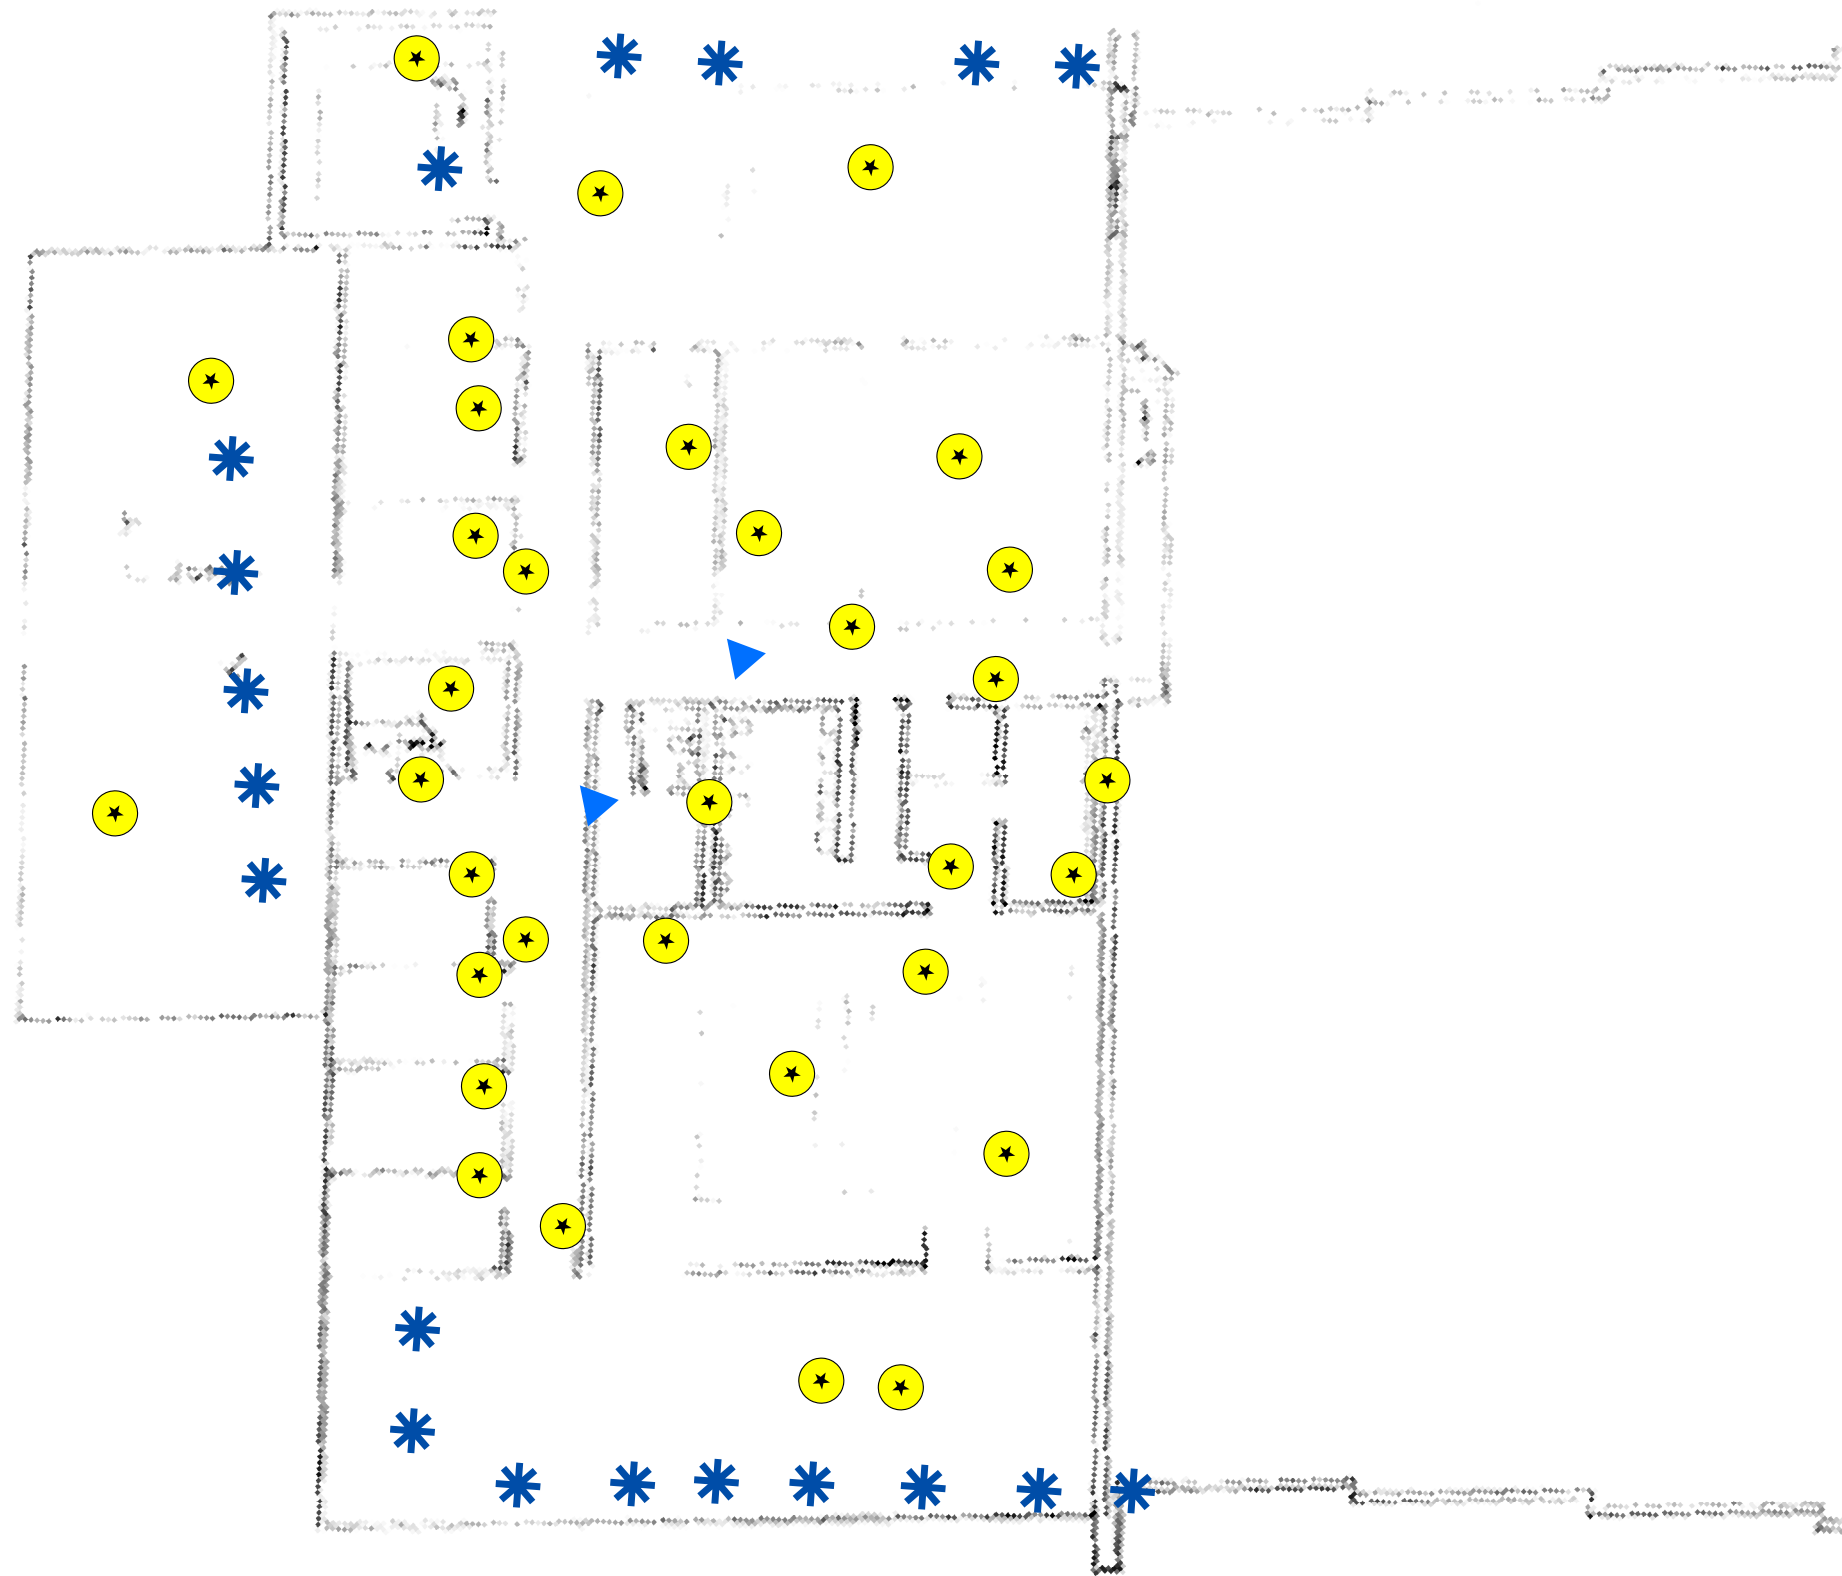



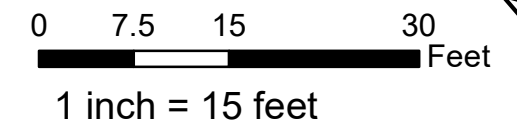


Figure PY2
Site Map with
Site Level Features
Picatinny Armory
Floor 2

Legend

Picatinny Armory Floor 2

-  Air Conditioning Unit
-  Drinking Water Fountain
-  Light Ballast



Notes:

Floor plans georeferenced via headsup digitizing
 over 2015 aerial photography
 Locations of air emissions, ODS, and FLBs georeferenced
 via floor plans





Scale: 1 inch = 15 feet
 File: PY2
 Date: 5/20/2019
 Created By: Rosalie Hood,
 Anne Timmreck,
 Raina Ryan,
 Alexandria Petrosch

Rowan
 University
 &
 Stockton
 University

**Figure PN1
Site Map with
Site Level Features
Princeton Warehouse
Floor 1**

Legend

Princeton Warehouse 1st Floor

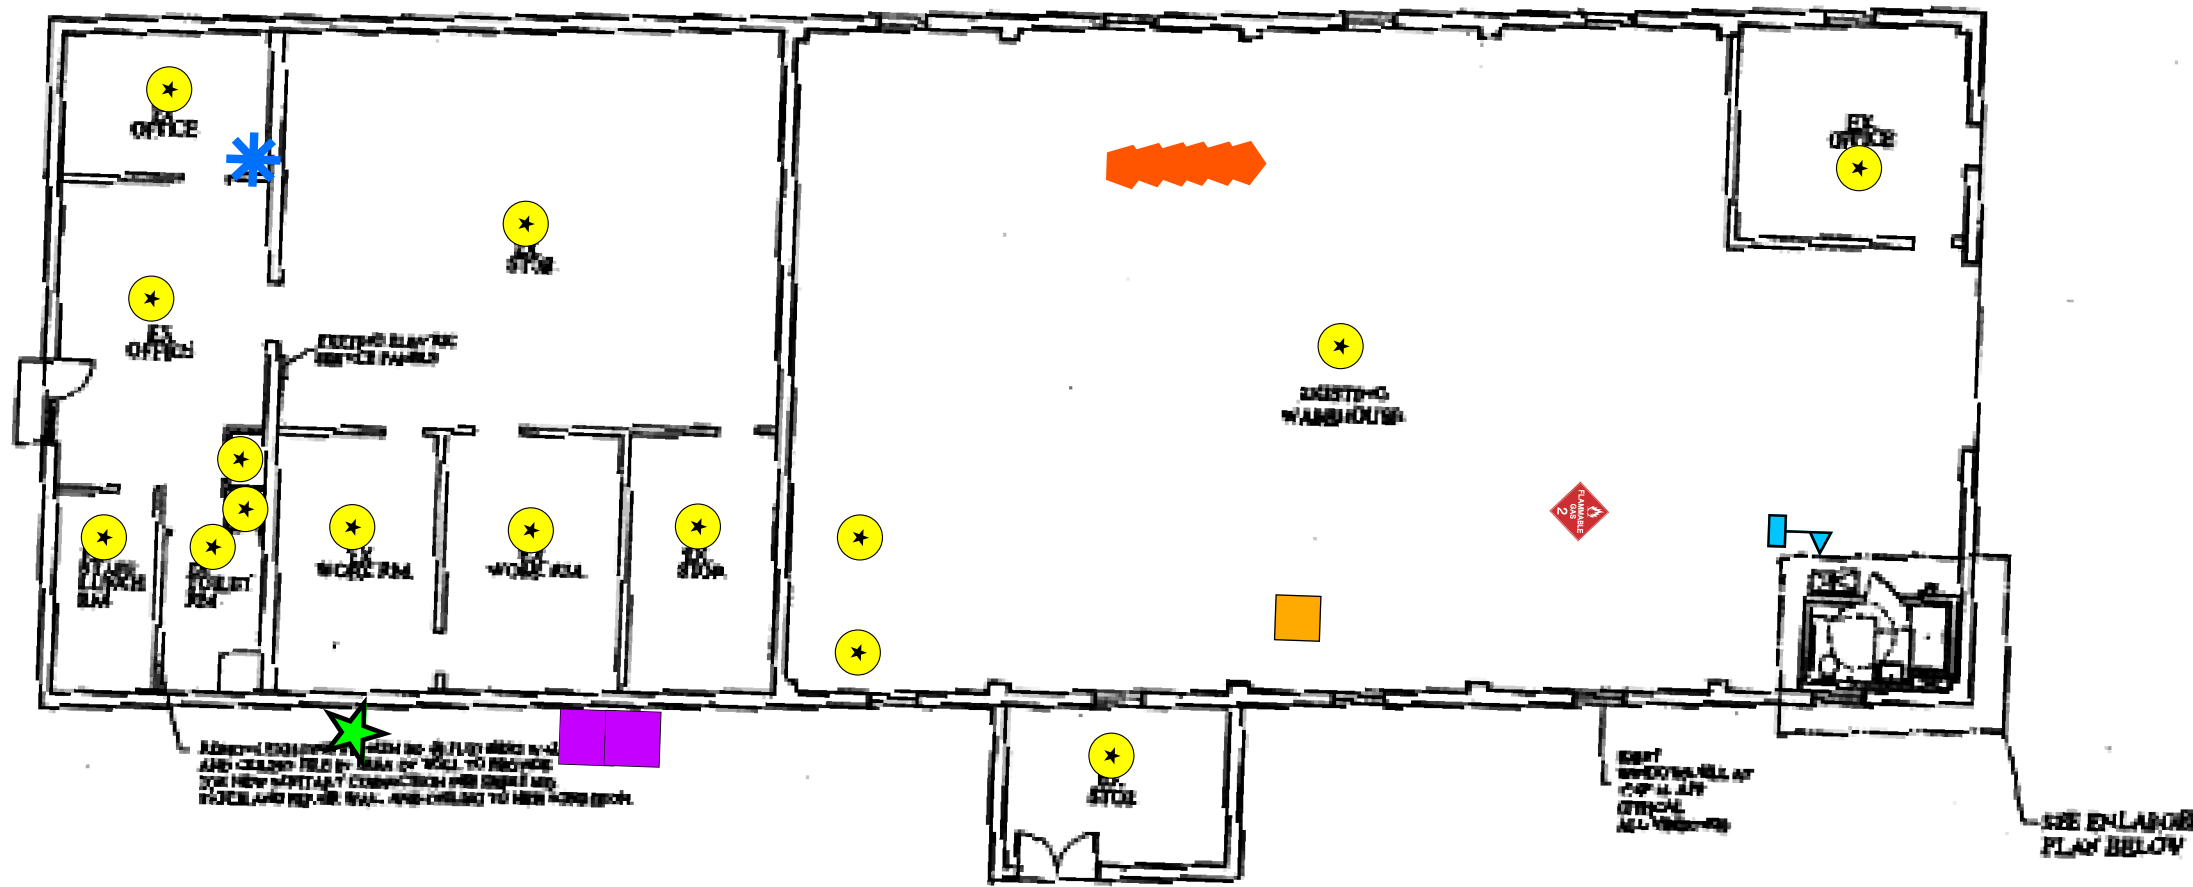
-  Air Conditioning Unit
-  Dehumidifying Unit
-  Emergency Generator
-  Flammable Cabinet
-  Forced Air Heater
-  Light Ballast
-  Parts Washer
-  Refrigeration Unit
-  Storage Tank



1 inch = 15 feet

Notes:

Floor plans georeferenced via headsup digitizing over 2015 aerial photography
Locations of air emissions, ODS, and FLBs georeferenced via floor plans



FLOOR PLAN
SCALE: 1/4" = 15'



PRINCETON WAREHOUSE



Scale: 1 inch = 15 feet
File: PN1
Date: 5/20/2019
Created By: Rosalie Hood,
Michael Hoffman,
Alexandria Petrosch

**Rowan
University
&
Stockton
University**

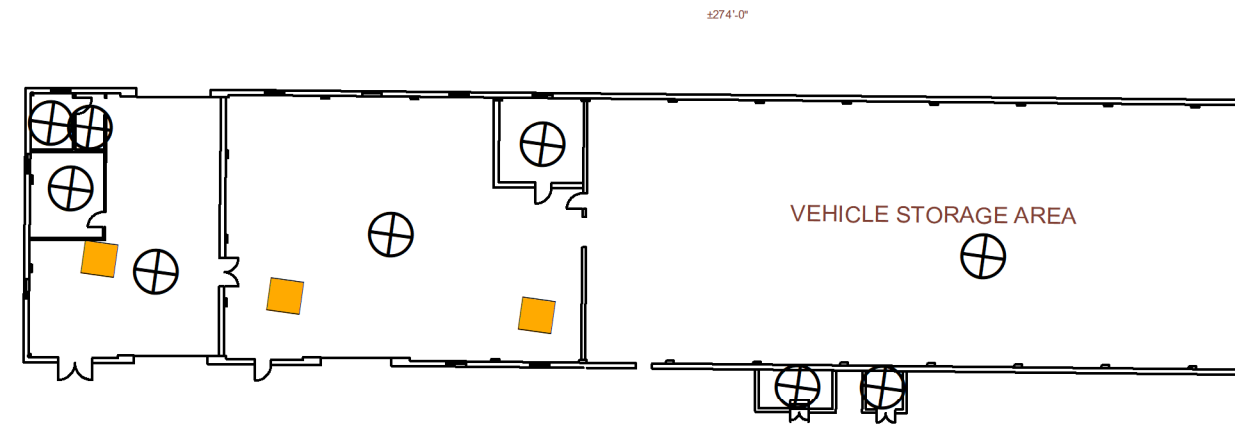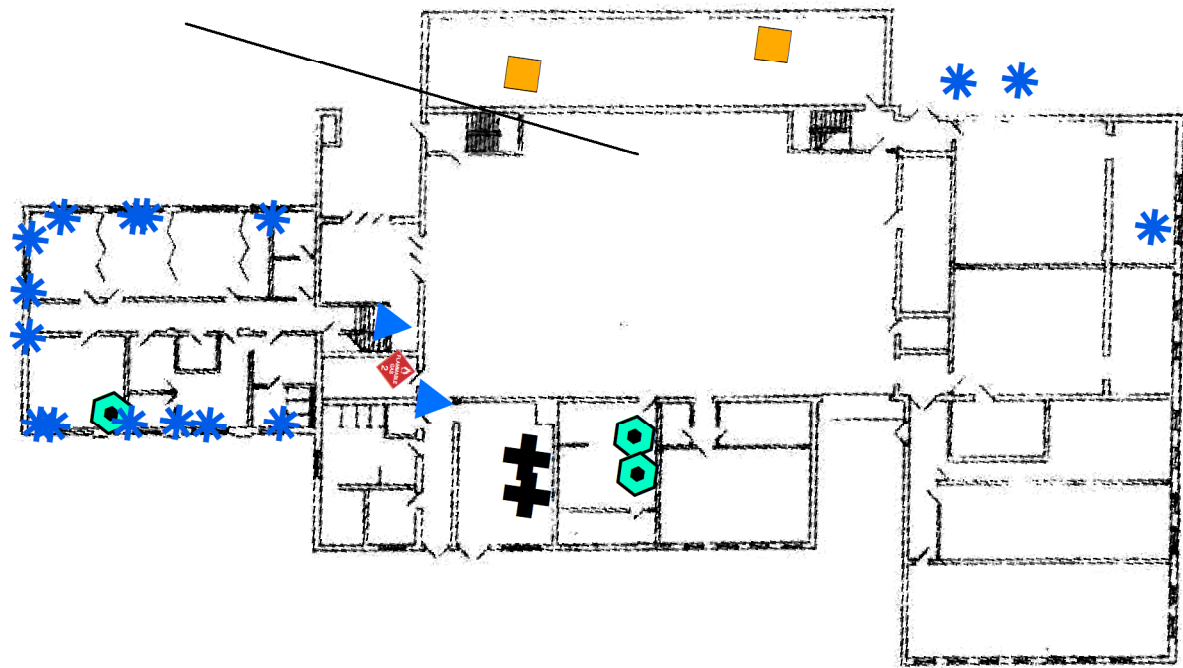**Figure RE1
Site Map with
Site Level Features
Riverdale Armory & OMS
Floor 1**




RIVERDALE (MVS) Floor Plan

Legend

Riverdale Armory & OMS Floor 1

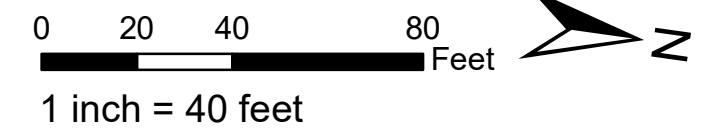- Air Conditioning Unit
- Boiler
- Drinking Water Fountain
- Flammable Cabinet
- Forced Air Heater
- Light Ballast
- No Access
- No FLBs
- OMS
- Refrigeration Unit



Notes:

Floor plans georeferenced via headsup digitizing over 2015 aerial photography
Locations of air emissions, ODS, and FLBs georeferenced via floor plans






Scale: 1 inch = 40 feet
File: RE1
Date: 5/20/2019
Created By: Hannah Buckley,
Alexandria Petros

Rowan
University
&
Stockton
University

**Figure RE2
Site Map with
Site Level Features
Riverdale Armory
Floor 2**

Legend

Riverdale 2nd Floor a&b

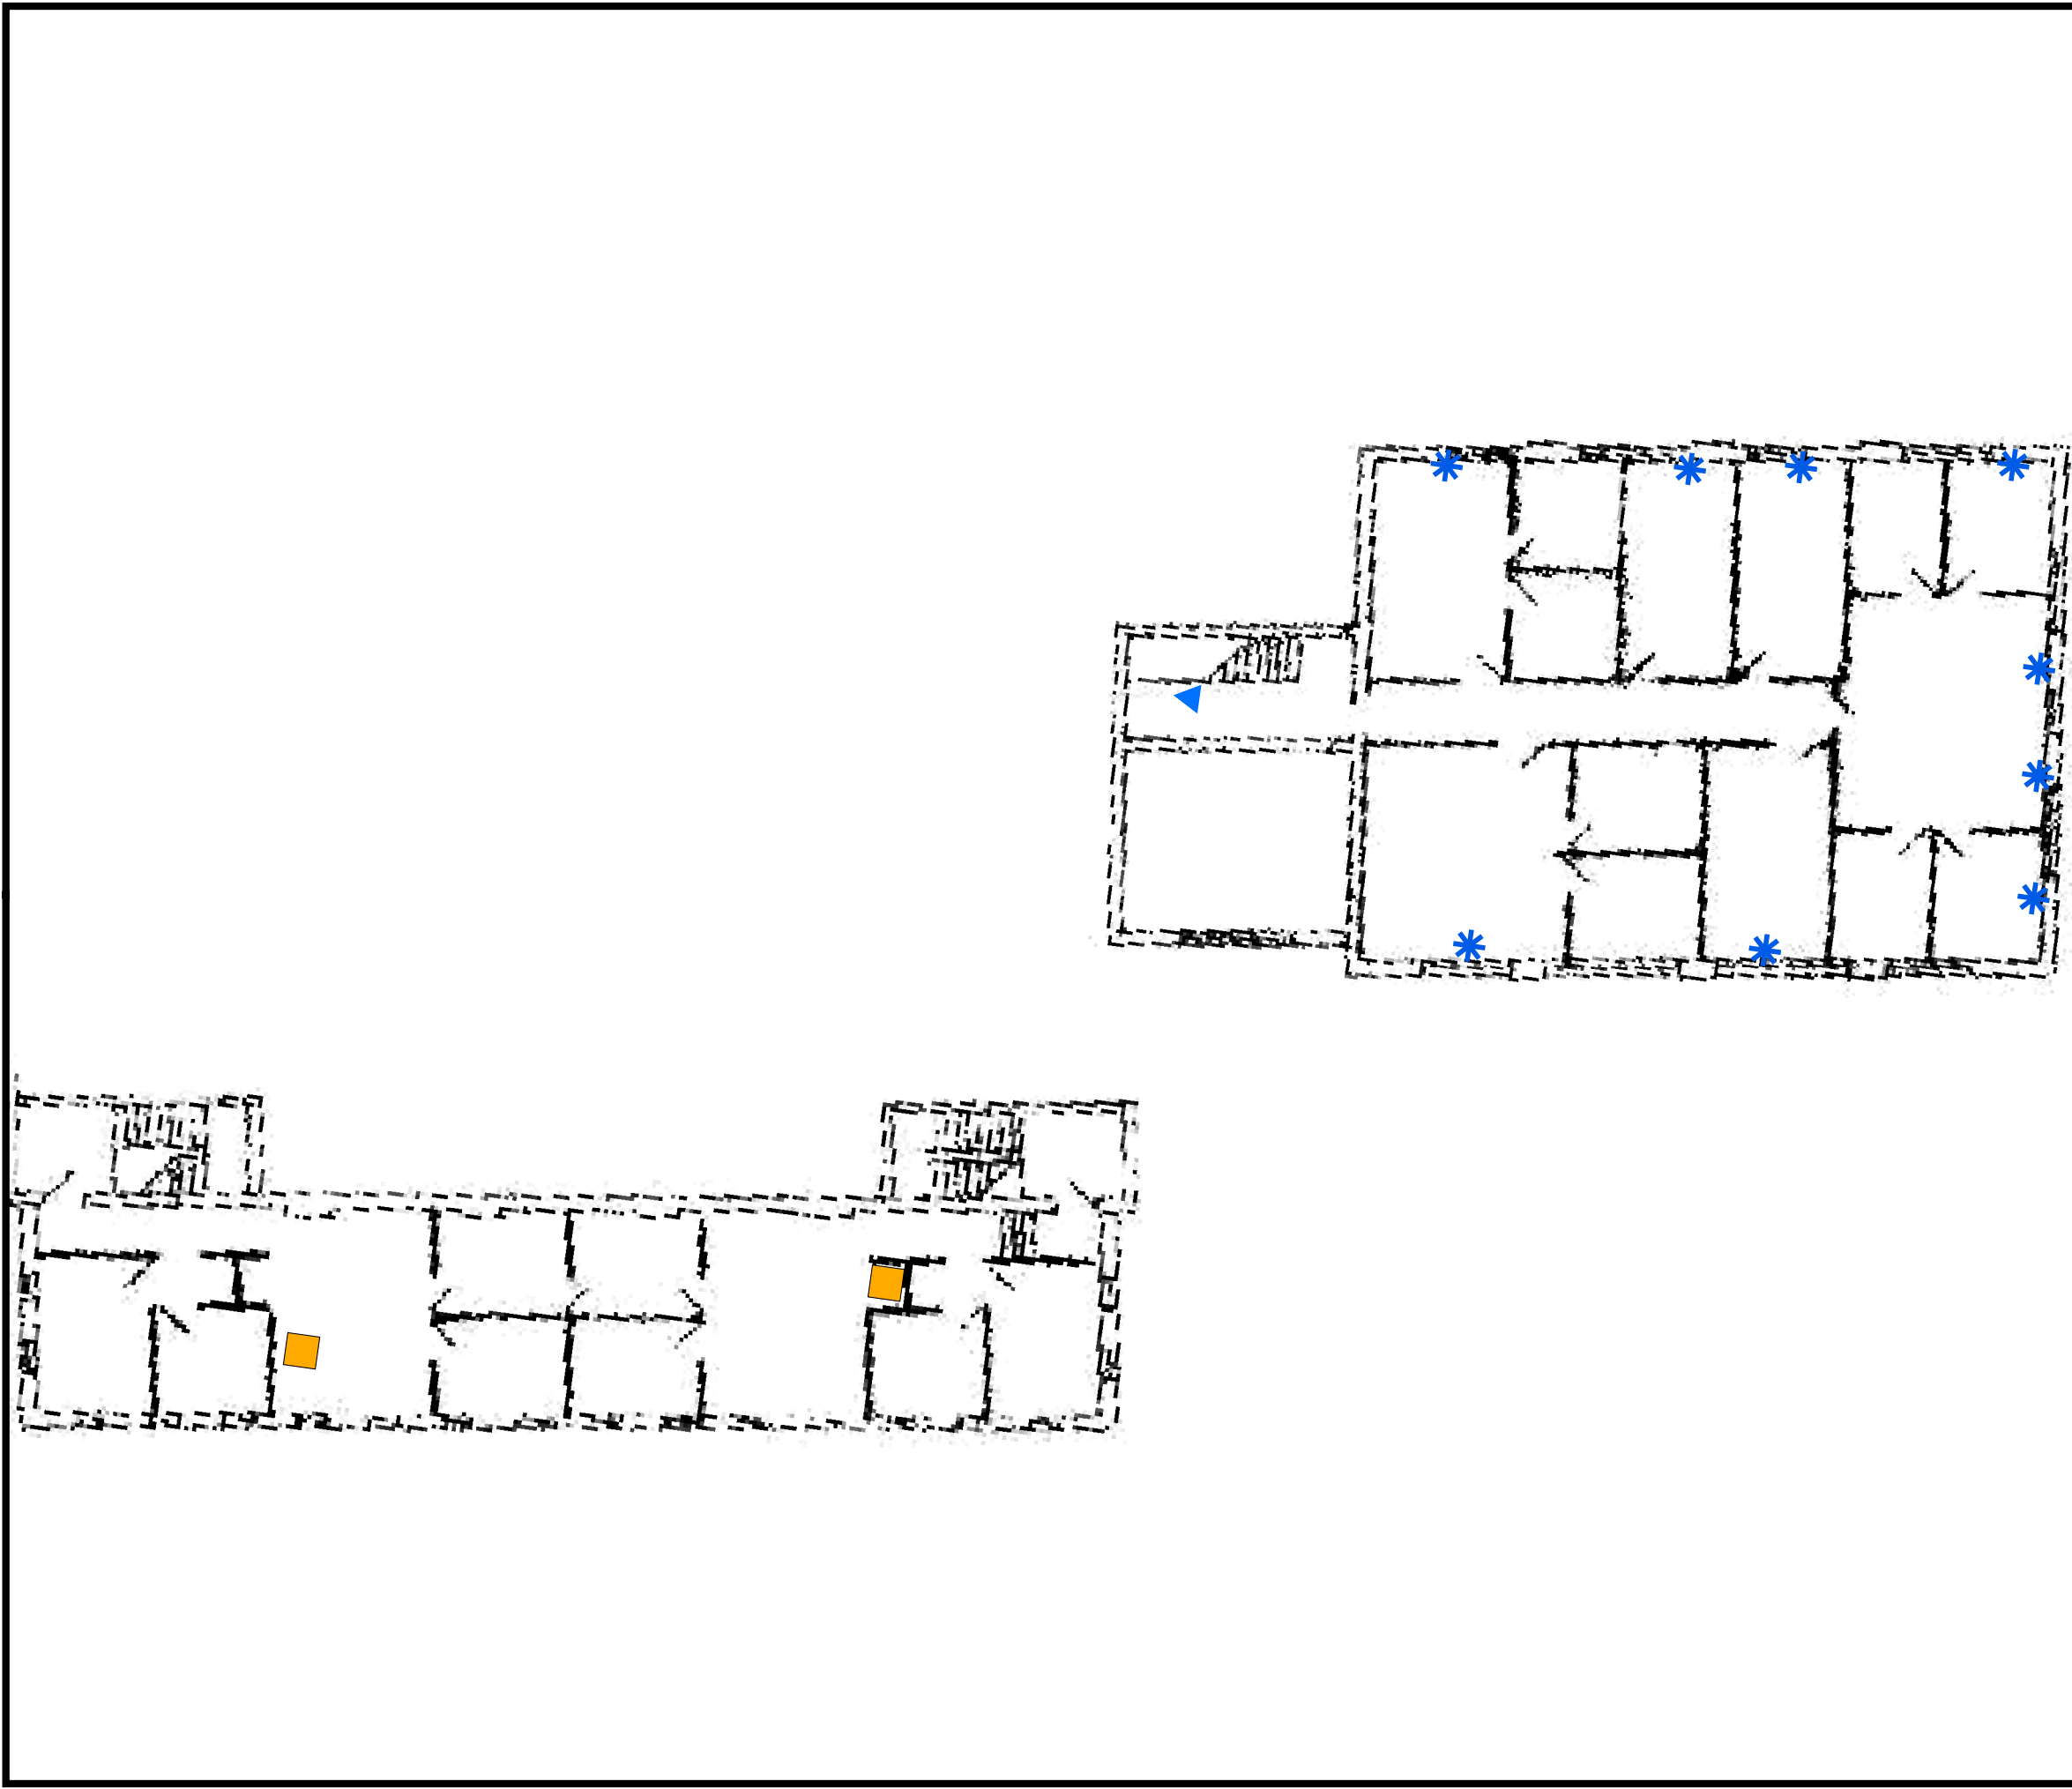
-  Air Conditioning Unit
-  Drinking Water Fountain
-  Forced Air Heater



1 inch = 15 feet

Notes:

Floor plans georeferenced via headsup digitizing over 2015 aerial photography
Locations of air emissions, ODS, and FLBs georeferenced via floor plans




Scale: 1 inch = 15 feet
File: RE2
Date: 5/20/2019
Created By: Hannah Buckley,
Alexandria Petrosch

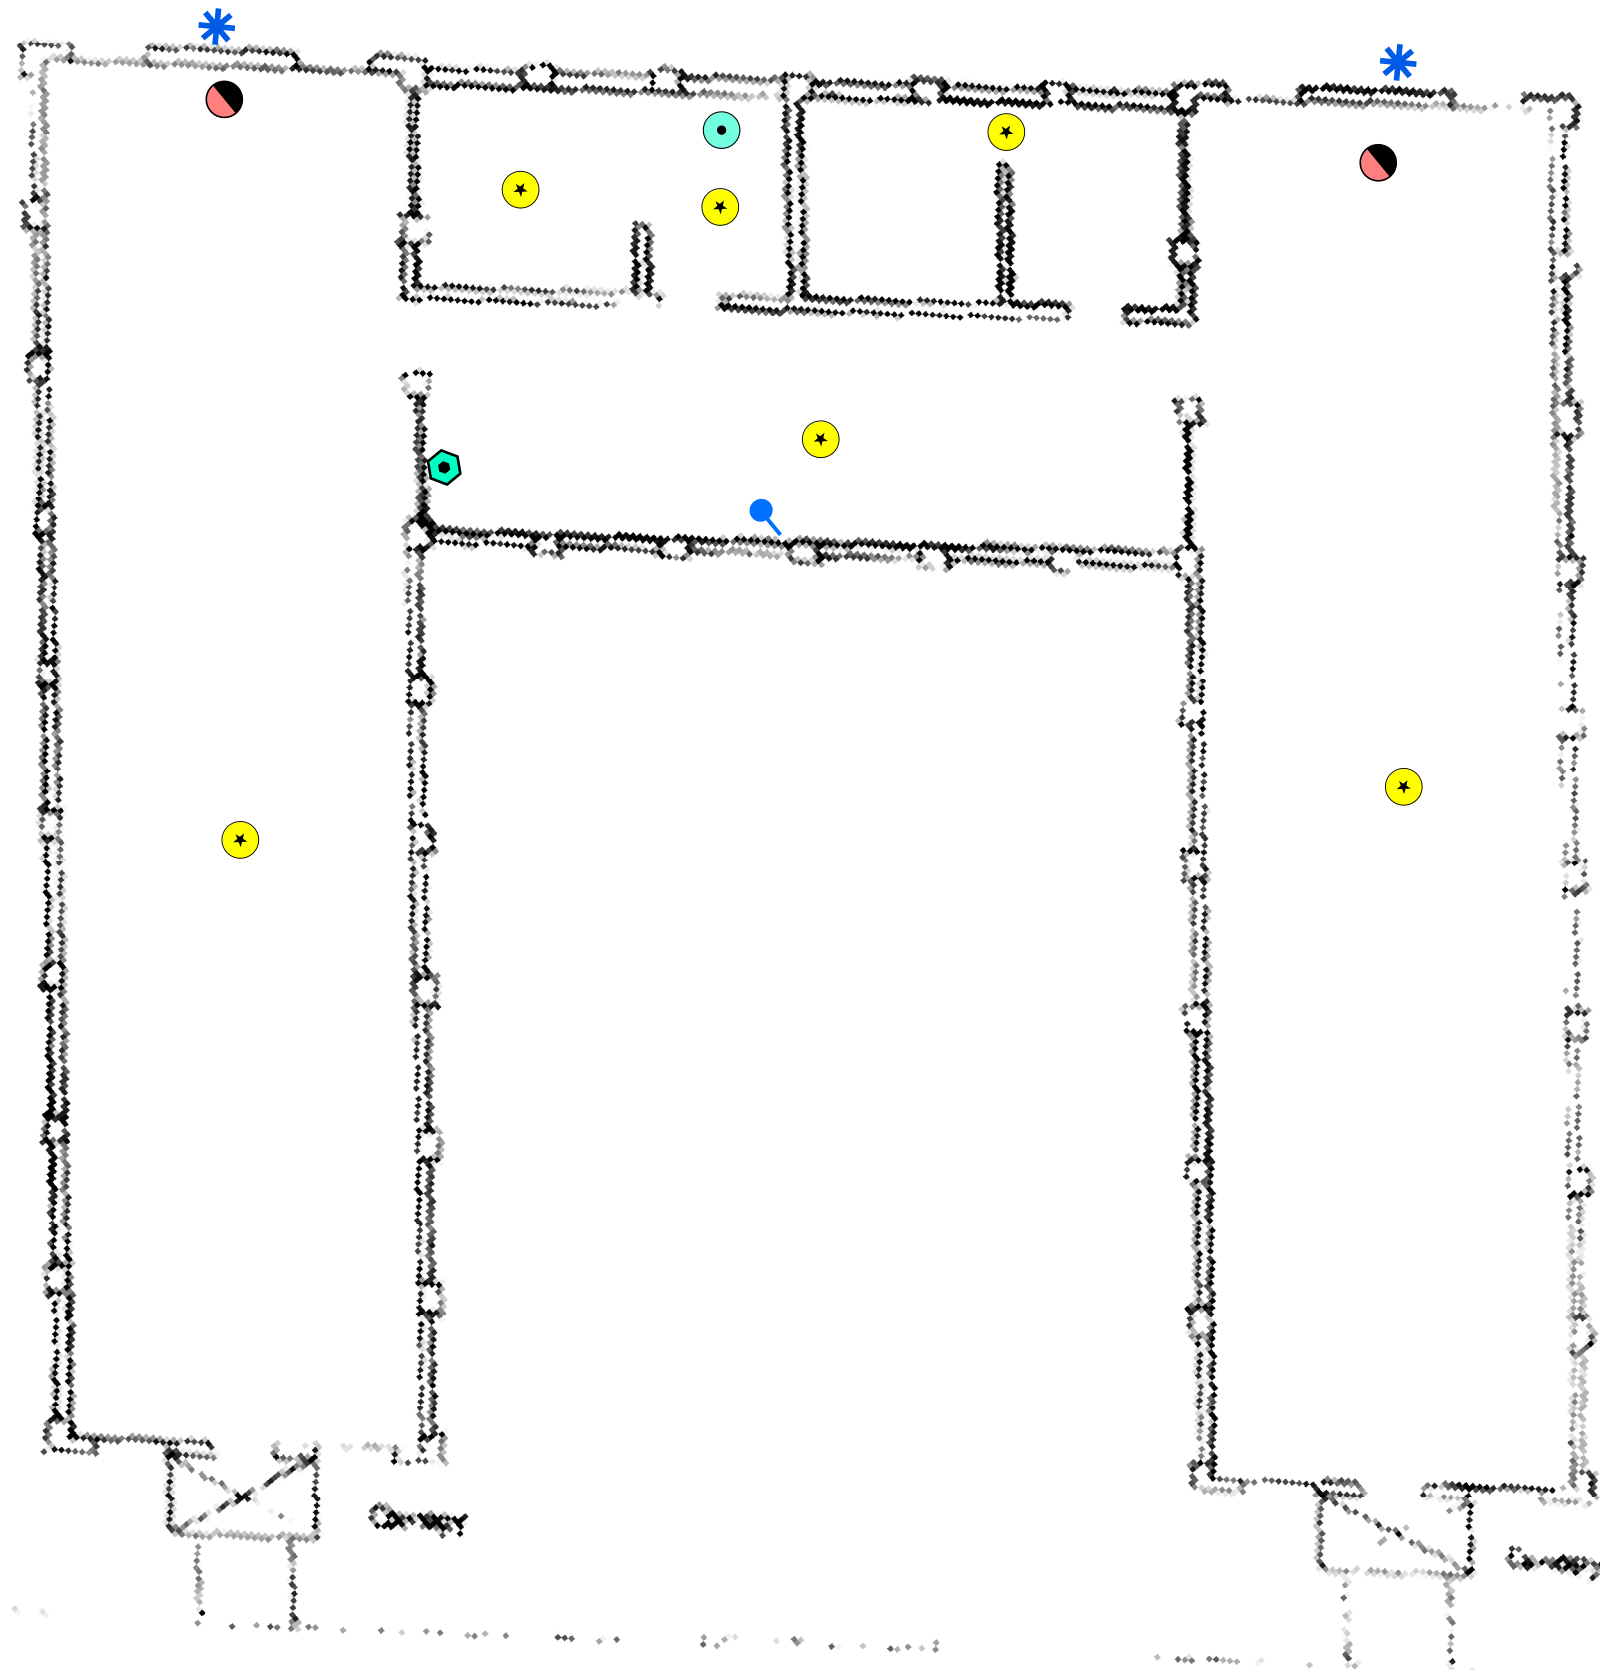**Rowan
University
&
Stockton
University**







Building 17
Sea Girt


Figure ST1
Site Map with
Site Level Features
Sea Girt Armory
Bldg 17



Legend

Sea Girt Building 17 1st Floor

 -  Air Conditioning Unit
-  Hot Water Heater
-  Light Ballast
-  Refrigeration Unit
-  Split Unit (Air Conditioner/Heater)
-  Water Cooler



1 inch = 10 feet



Notes:


Floor plans georeferenced via headsup digitizing over 2015 aerial photography
Locations of air emissions, ODS, and FLBs georeferenced via floor plans



Scale: 1 inch = 10 feet
File: ST1
Date: 5/21/2019
Created By: Rosalie Hood,
Anne Timmreck,
Raina Ryan,
Alexandria Petrosch

Rowan
University
&
Stockton
University

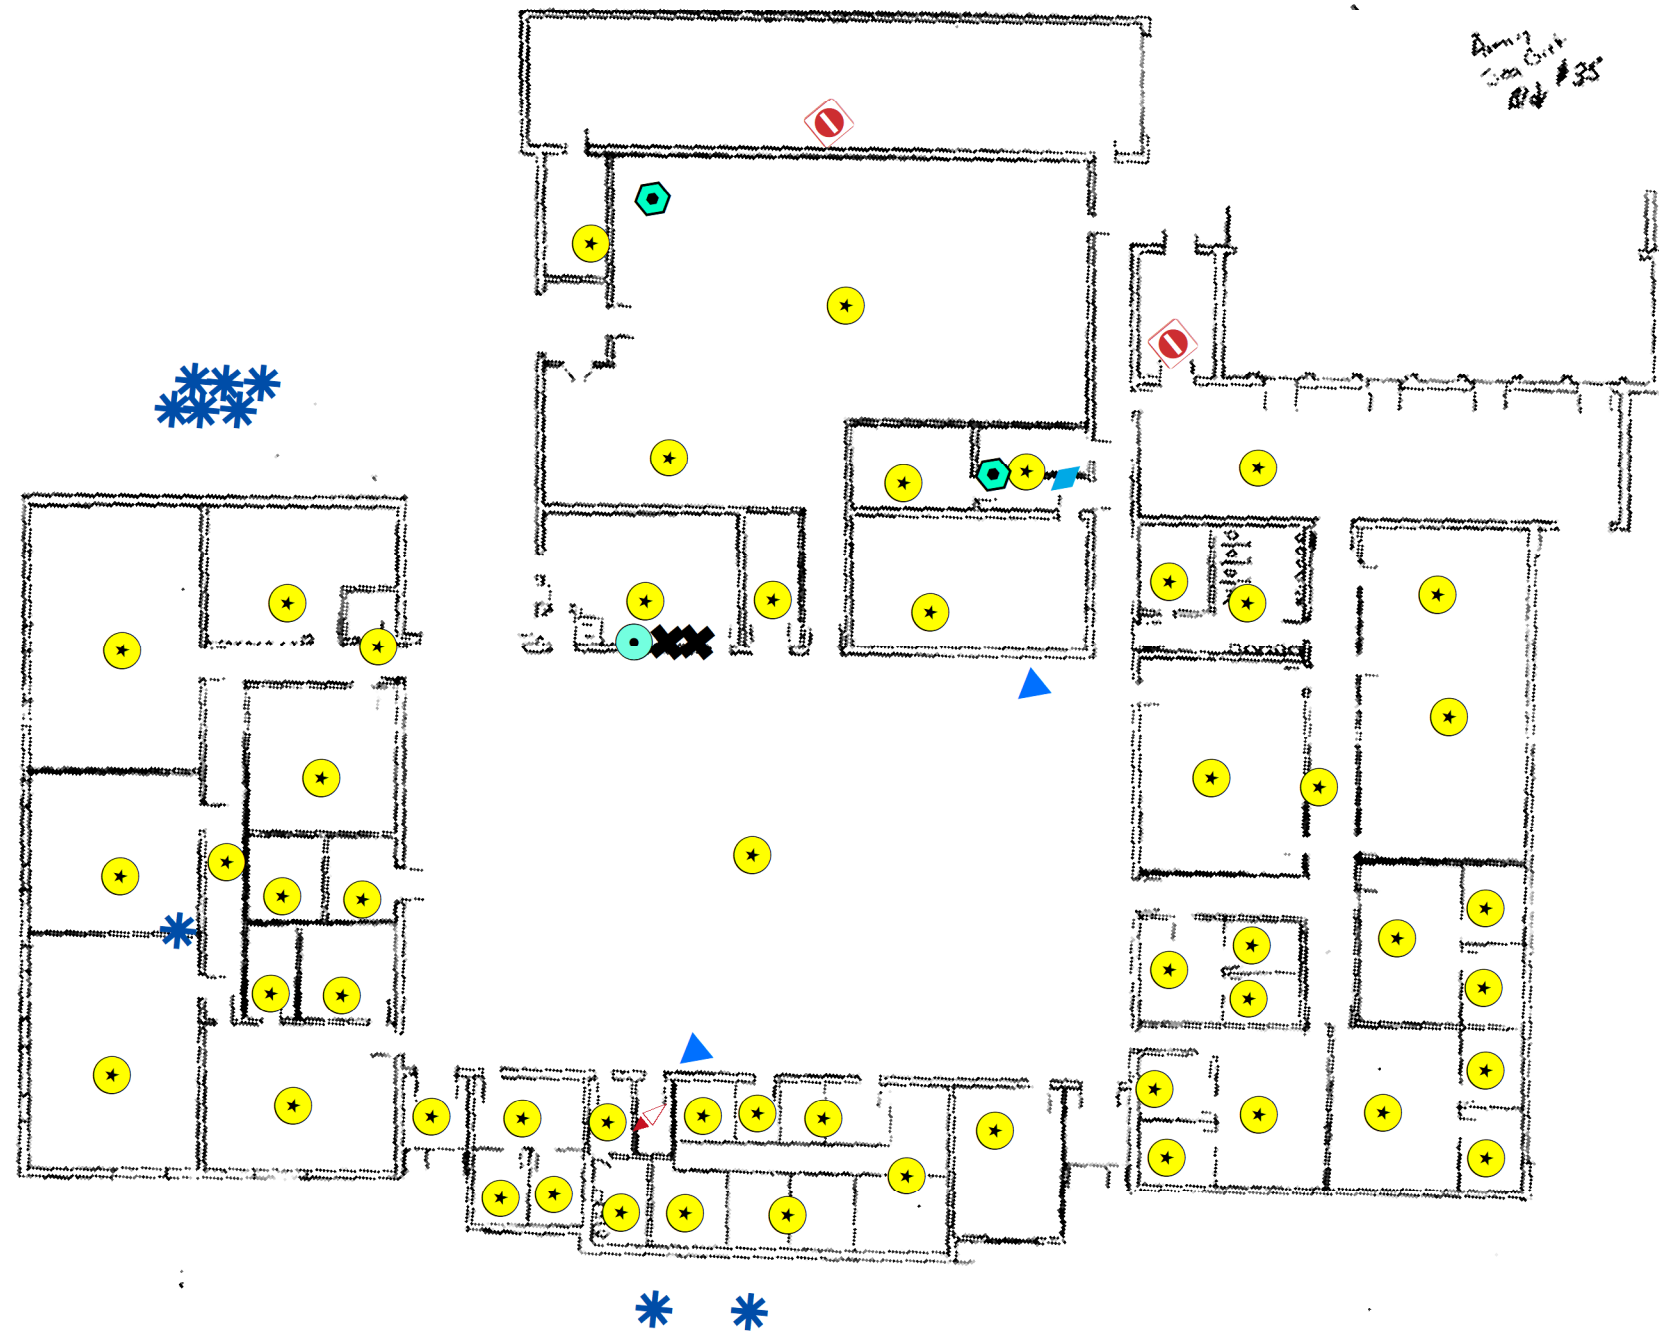
**Figure ST2
Site Map with
Site Level Features
Sea Girt Armory
Bldg 35**



Legend

Sea Girt Building 35 1st Floor

 - Air Conditioning Unit
- Boiler
- Drinking Water Fountain
- Freezer Unit
- Hot Water Heater
- Light Ballast
- No Access
- No FLBs
- Refrigeration Unit



1 inch = 30 feet



Notes:

Floor plans georeferenced via headsup digitizing over 2015 aerial photography
Locations of air emissions, ODS, and FLBs georeferenced via floor plans



Scale: 1 inch = 30 feet
File: ST2
Date: 5/21/2019
Created By: Rosalie Hood,
Anne Timmreck,
Raina Ryan,
Alexandria Petrosch

**Rowan
University
&
Stockton
University**

Bldg 11
Mess Hall










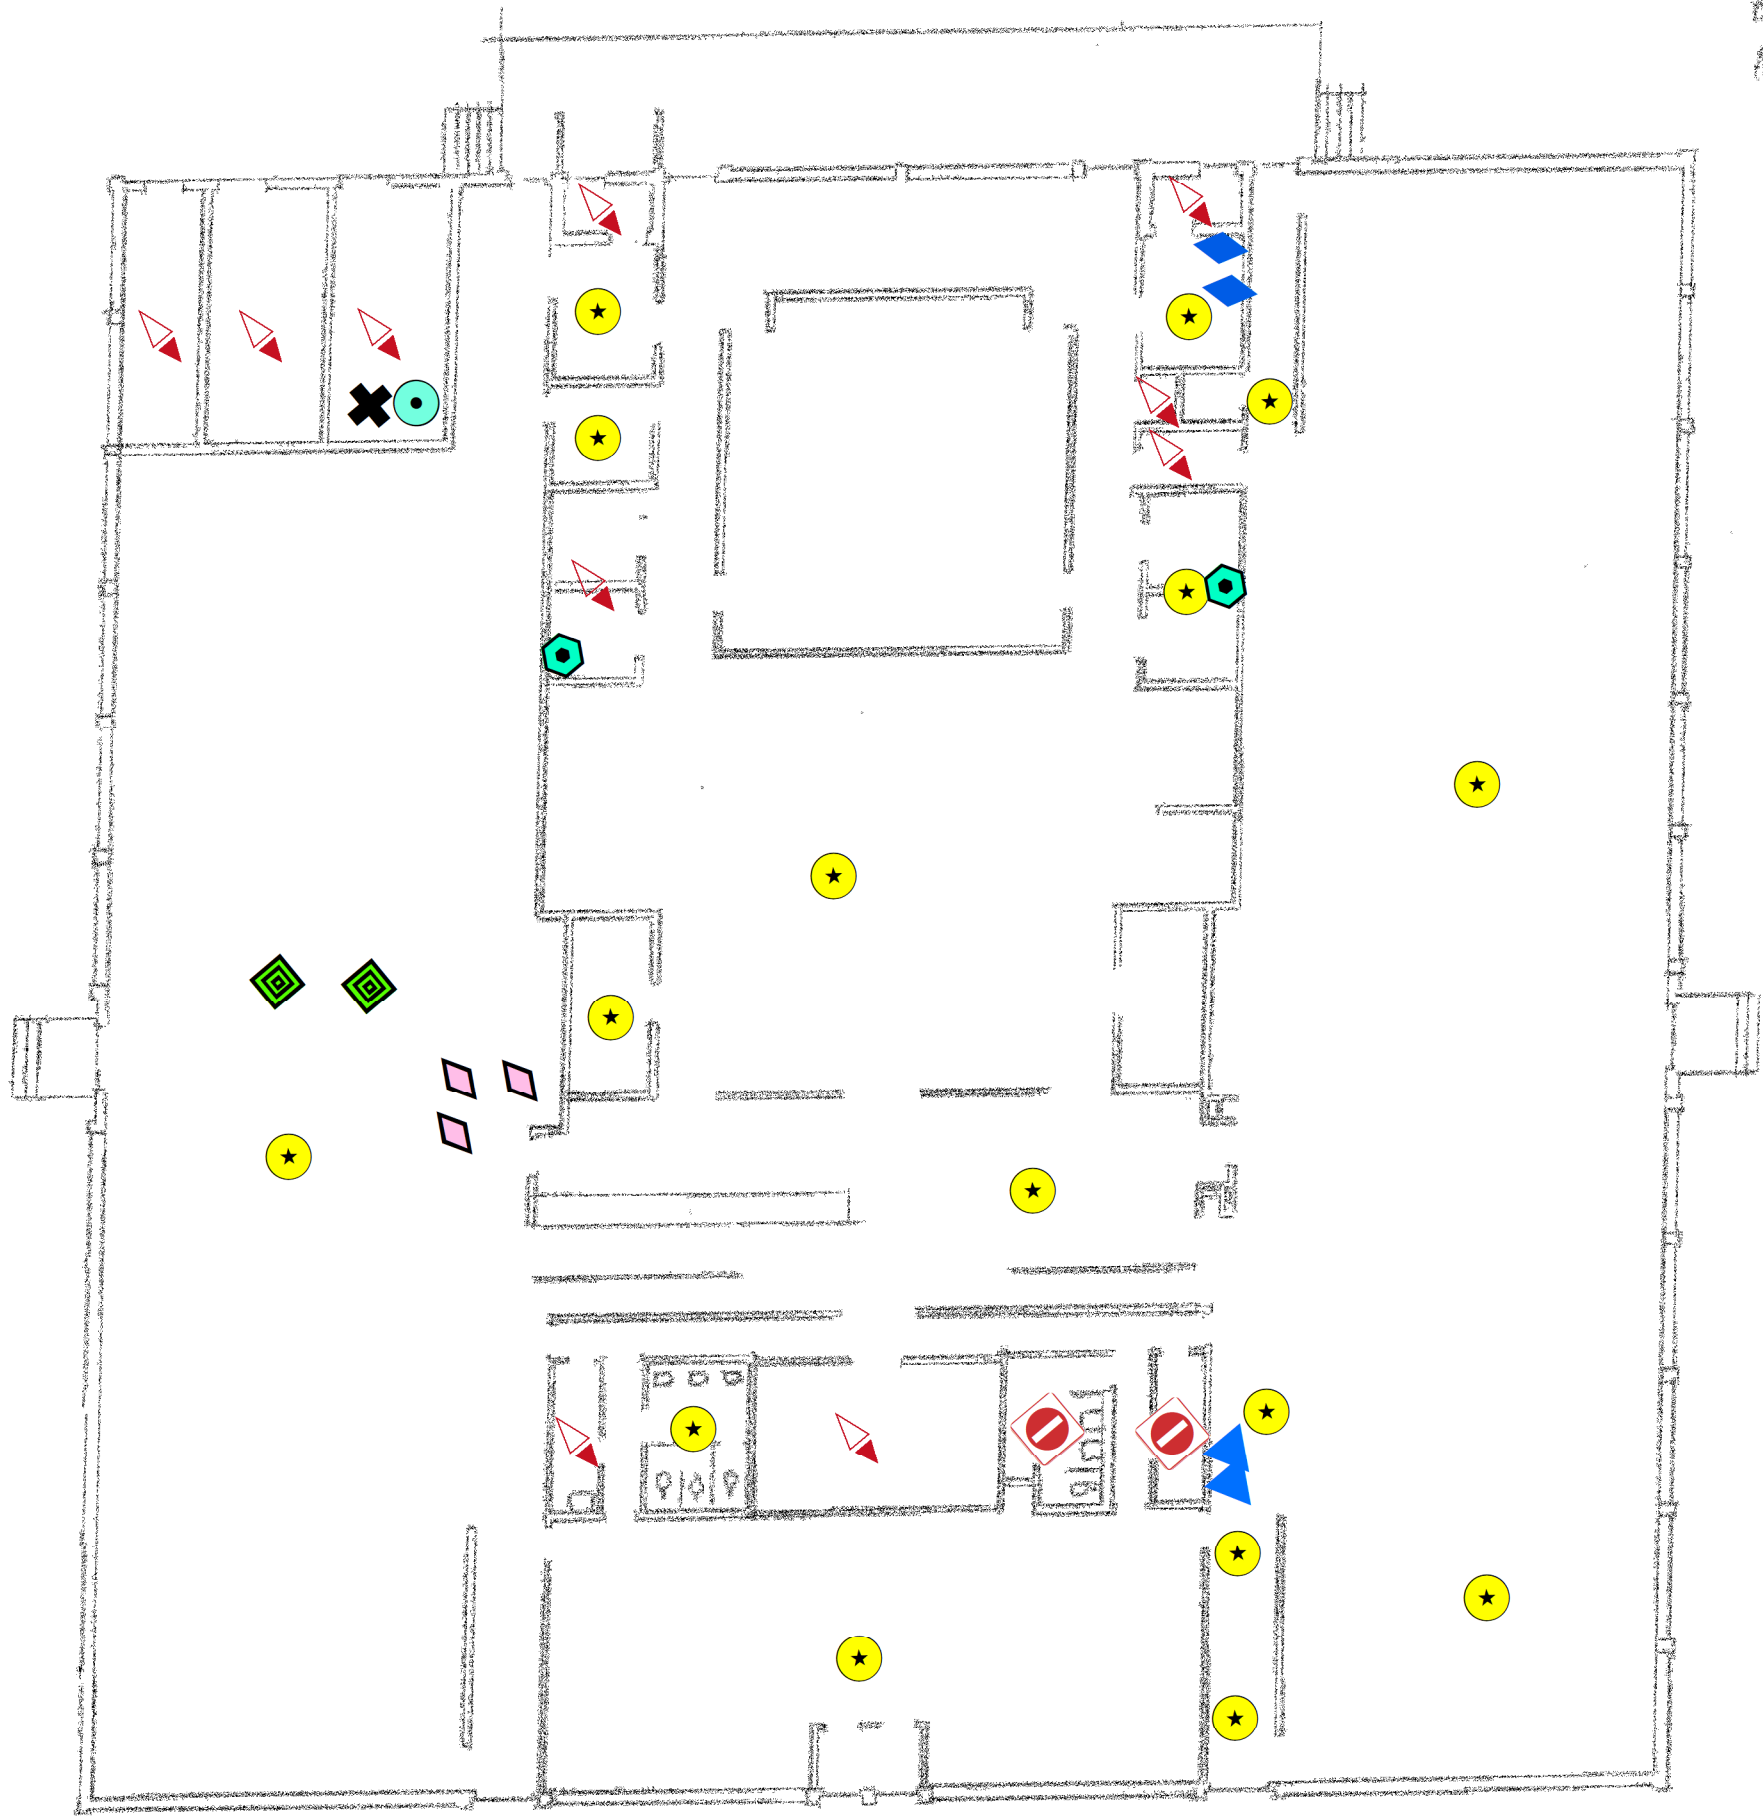

 


Figure ST3
Site Map with
Site Level Features
Sea Girt Armory
Bldg 11 Mess Hall

Legend

Sea Girt Building 11 Mess Hall 1st Floor

-  Boiler
-  Chilled Serving Counter
-  Drinking Water Fountain
-  Hot Water Heater
-  Ice Machine
-  Light Ballast
-  No Access
-  No FLBs
-  Refrigeration Unit
-  Soda Machine



1 inch = 15 feet



Notes:

Floor plans georeferenced via headsup digitizing over 2015 aerial photography
Locations of air emissions, ODS, and FLBs georeferenced via floor plans



Scale: 1 inch = 15 feet


File: ST3

Date: 5/21/2019

Created By: Rosalie Hood,
Anne Timmreck,
Raina Ryan,
Alexandria Petrosch




Rowan
University
&
Stockton
University

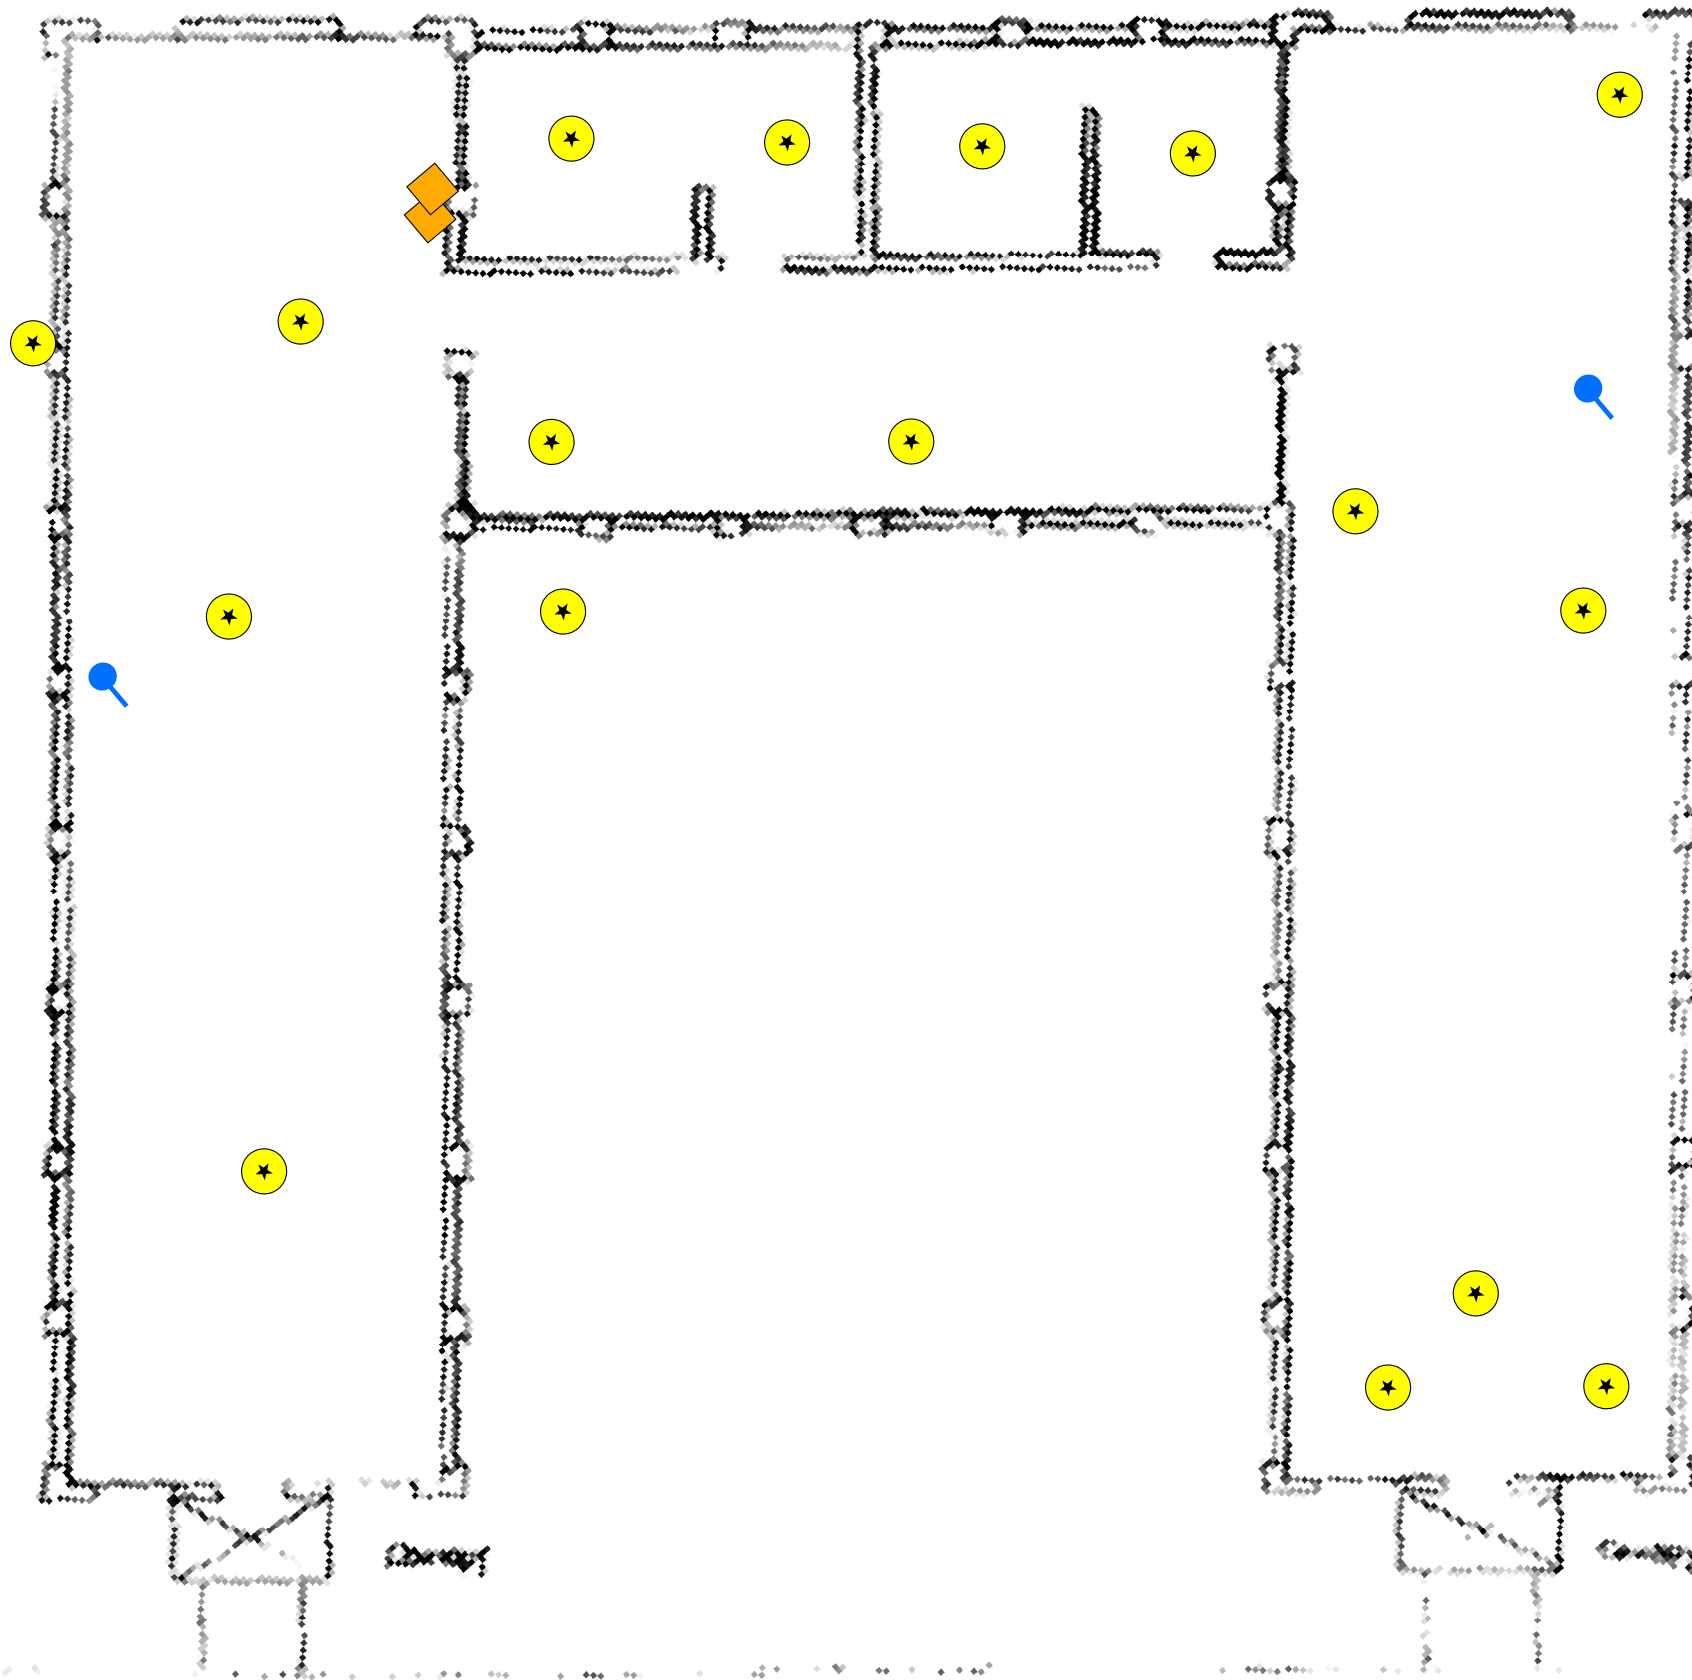
**Figure ST4
Site Map with
Site Level Features
Sea Girt Armory
Bldg 14**




Legend

Sea Girt Building 14 1st Floor

 -  Forced Air Heater
-  Light Ballast
-  Water Cooler



1 inch = 10 feet

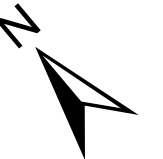

Notes:

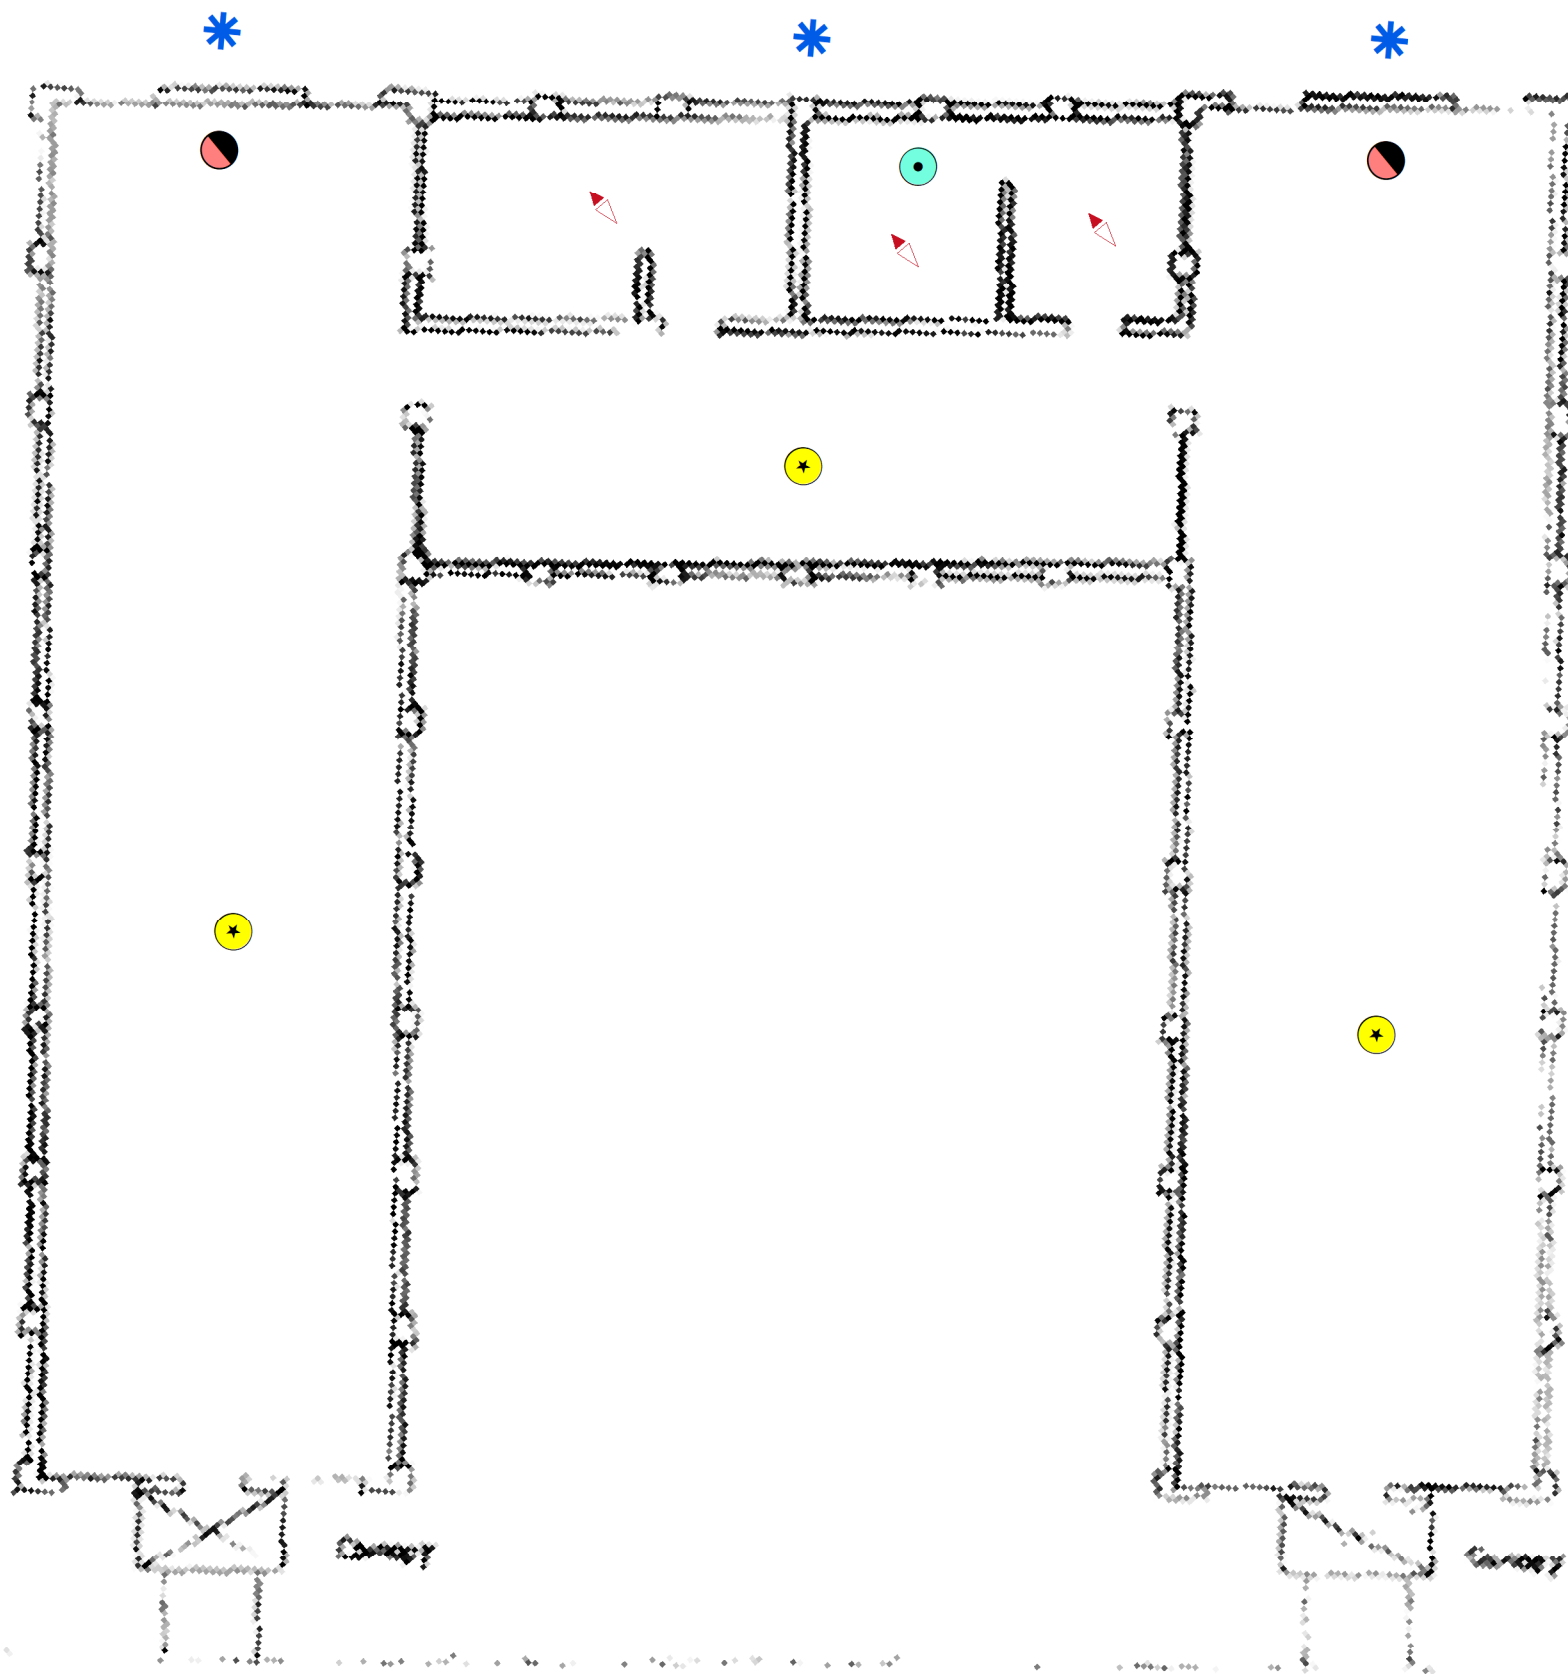
Floor plans georeferenced via headsup digitizing over 2015 aerial photography
Locations of air emissions, ODS, and FLBs georeferenced via floor plans



Scale: 1 inch = 10 feet
File: ST4
Date: 5/21/2019
Created By: Rosalie Hood,
Anne Timmreck,
Raina Ryan,
Alexandria Petrosch






**Rowan
University
&
Stockton
University**

**Figure ST6
Site Map with
Site Level Features
Sea Girt Armory
Bldg 18**



Legend

Sea Girt Building 18 1st Floor

-  Air Conditioning Unit
-  Hot Water Heater
-  Light Ballast
-  No FLBs
-  Split Unit (Air Conditioner/Heater)

0 5 10 20 Feet

1 inch = 10 feet



Notes:


Floor plans georeferenced via headsup digitizing over 2015 aerial photography
Locations of air emissions, ODS, and FLBs georeferenced via floor plans



Scale: 1 inch = 10 feet
File: ST6
Date: 5/21/2019
Created By: Rosalie Hood,
Anne Timmreck,
Raina Ryan,
Alexandria Petrosch

**Rowan
University
&
Stockton
University**

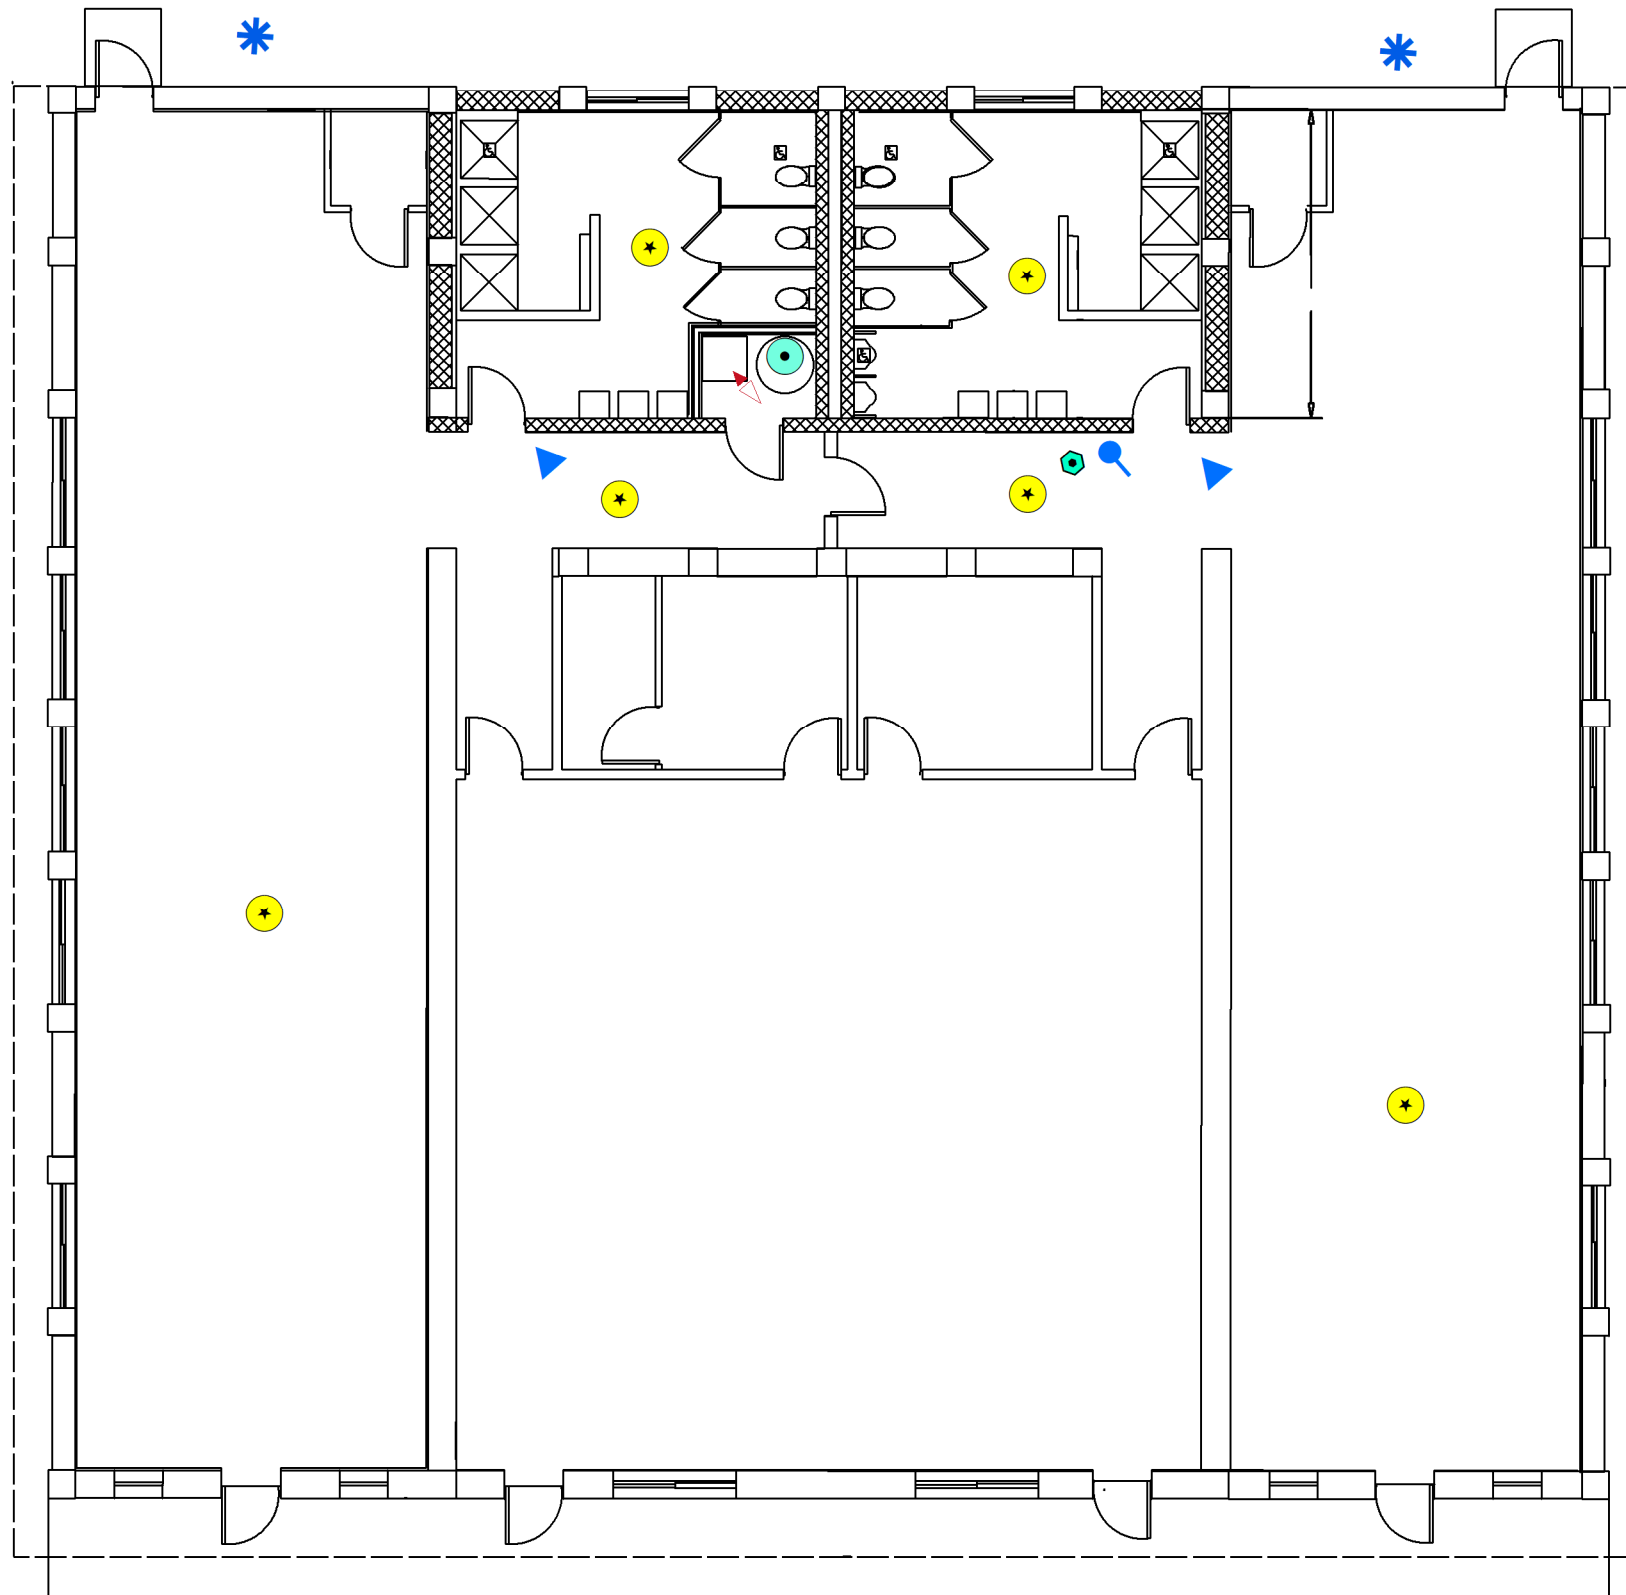**Figure ST7
Site Map with
Site Level Features
Sea Girt Armory
Bldg 20**




Legend

Sea Girt Building 20 1st Floor

- Air Conditioning Unit
- Drinking Water Fountain
- Hot Water Heater
- Light Ballast
- Refrigeration Unit
- Water Cooler
- No FLBs

0 5 10 20 Feet

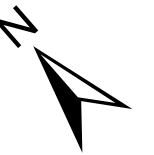1 inch = 10 feet



Notes:

Floor plans georeferenced via headsup digitizing over 2015 aerial photography
Locations of air emissions, ODS, and FLBs georeferenced via floor plans



Scale: 1 inch = 10 feet

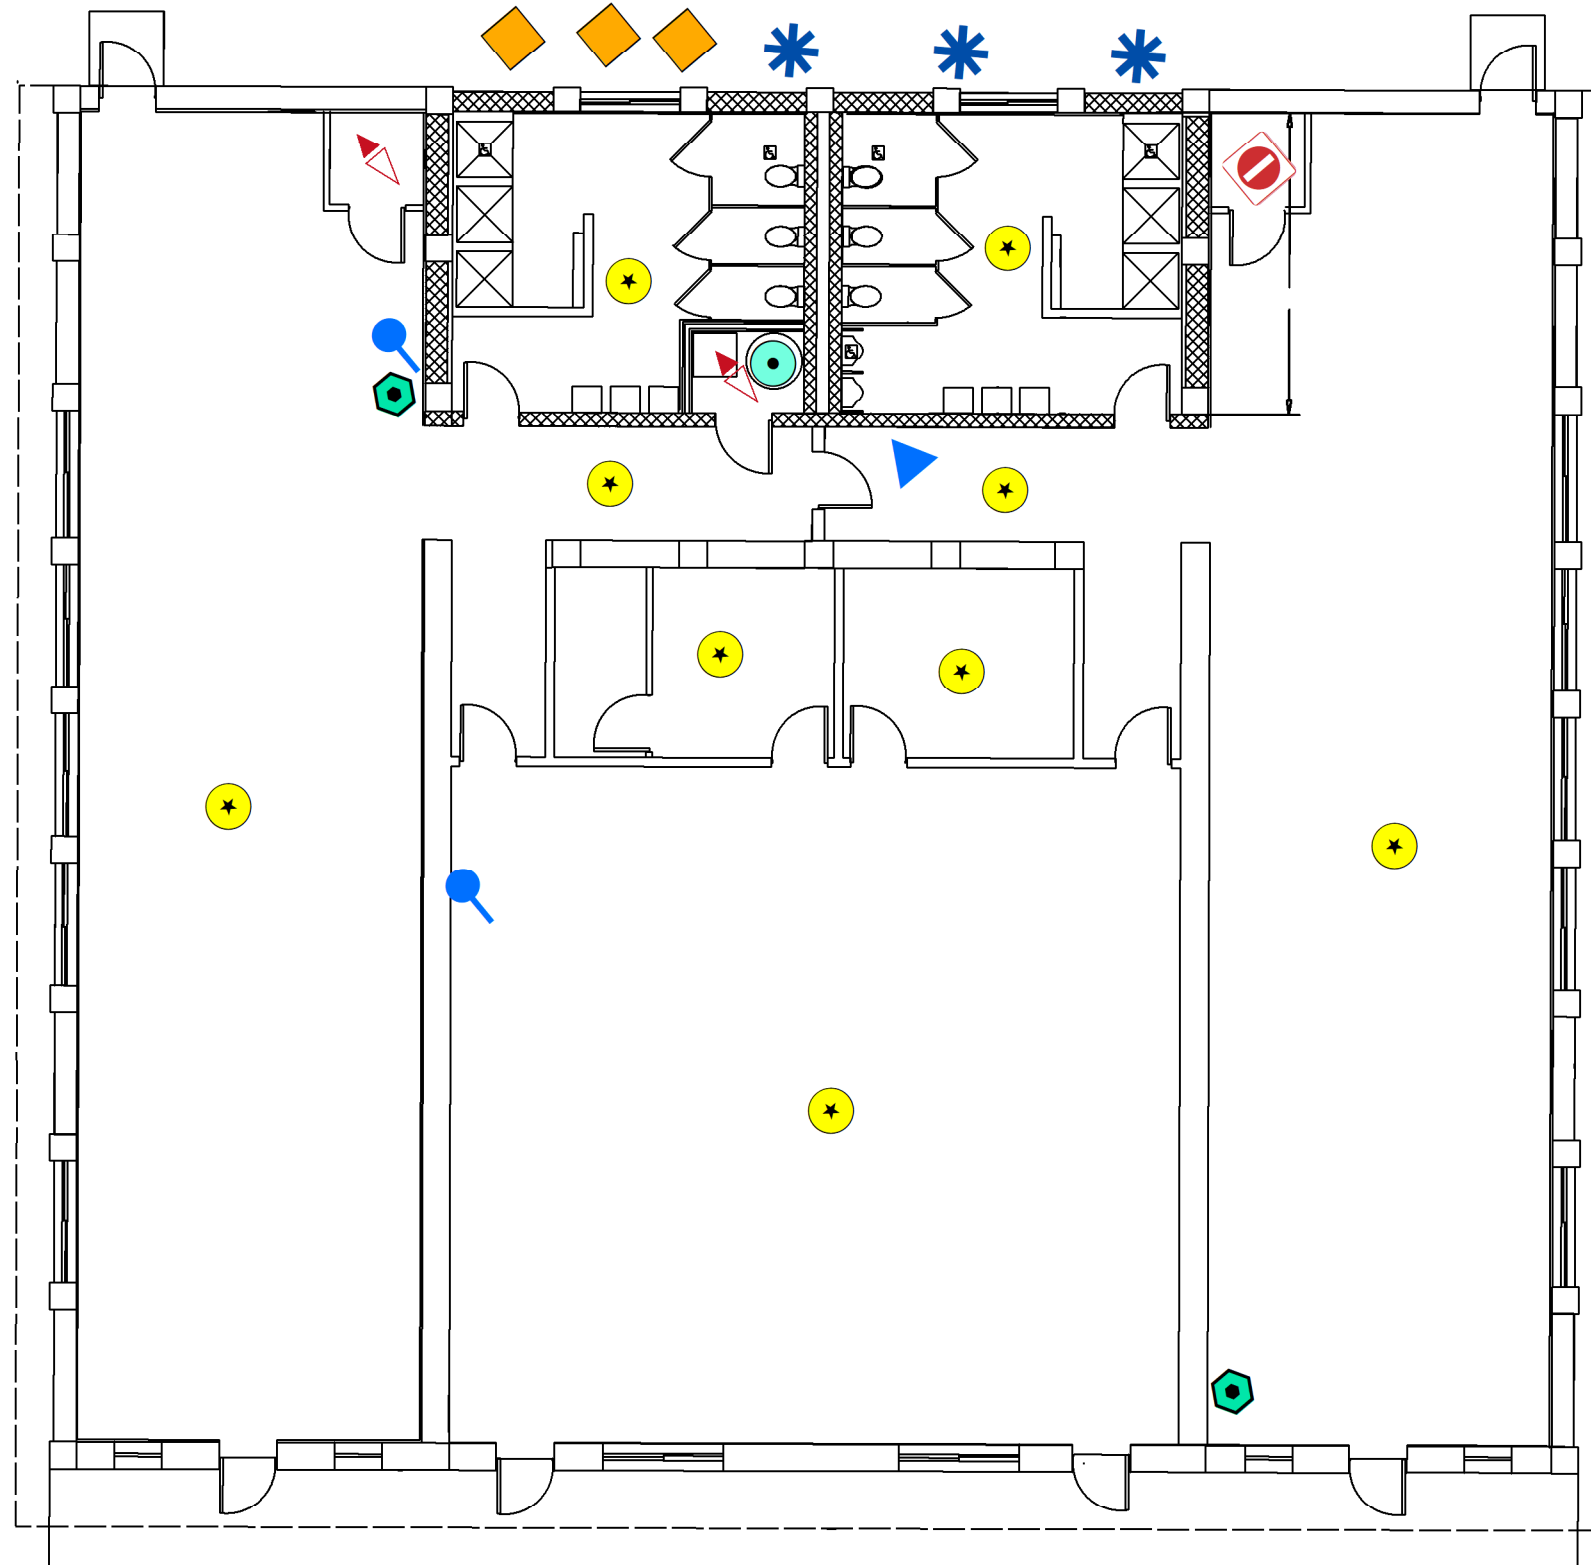
File: ST7

Date: 5/21/2019

Created By: Rosalie Hood,
Anne Timmreck,
Raina Ryan,
Alexandria Petrosch










**Rowan
University
&
Stockton
University**


**Figure ST8
Site Map with
Site Level Features
Sea Girt Armory
Bldg 21**



Legend

Sea Girt Building 21 1st Floor

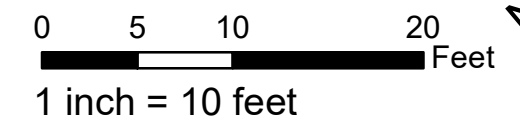-  Air Conditioning Unit
-  Drinking Water Fountain
-  Forced Air Heater
-  Hot Water Heater
-  Light Ballast
-  No Access
-  No FLBs
-  Refrigeration Unit
-  Water Cooler



Notes:

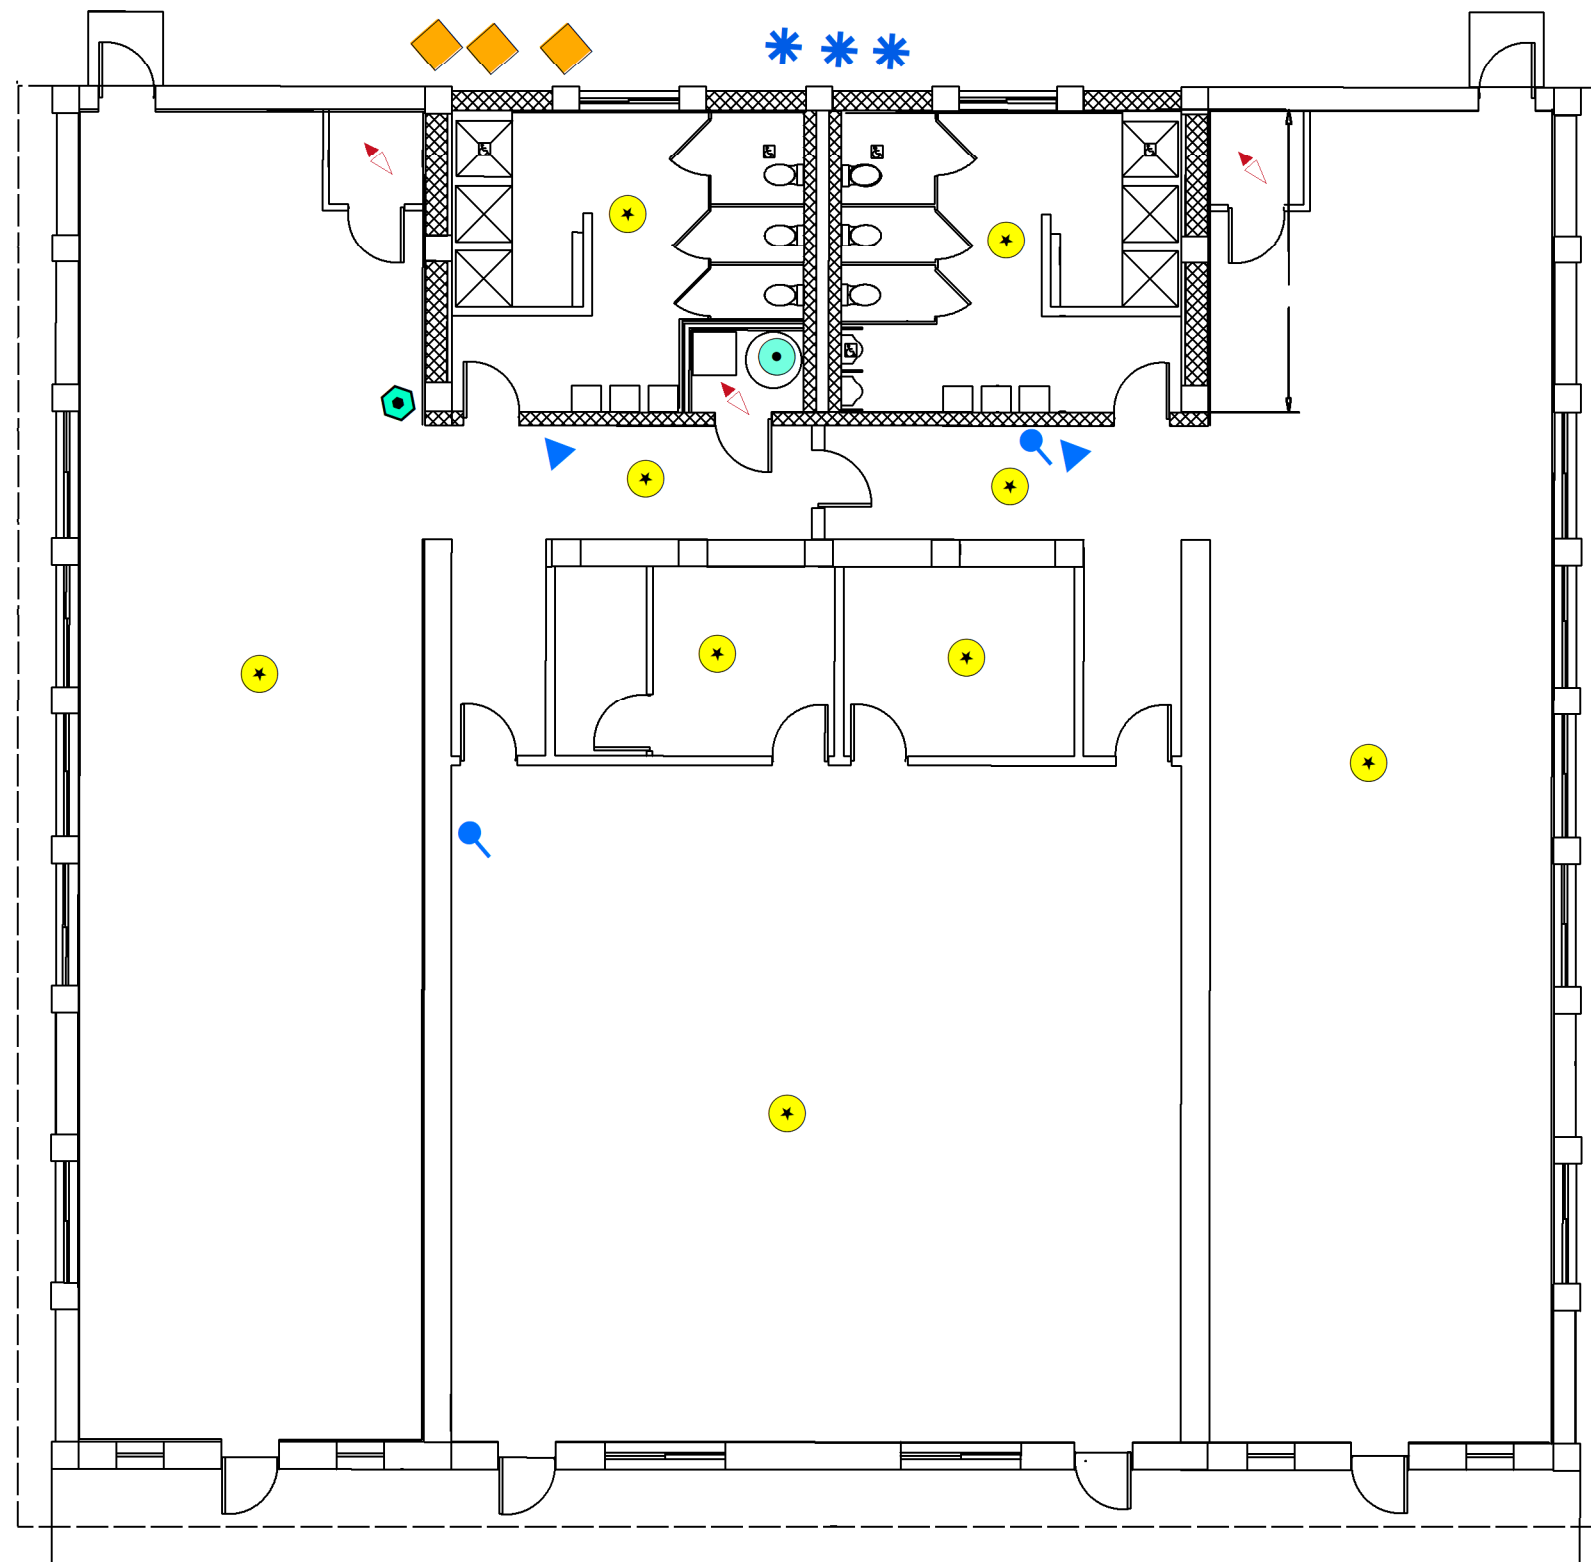
Floor plans georeferenced via headsup digitizing over 2015 aerial photography
Locations of air emissions, ODS, and FLBs georeferenced via floor plans



Scale: 1 inch = 10 feet
File: ST8
Date: 5/21/2019
Created By: Rosalie Hood,
Anne Timmreck,
Raina Ryan,
Alexandria Petrosch









**Rowan
University
&
Stockton
University**


**Figure ST9
Site Map with
Site Level Features
Sea Girt Armory
Bldg 22**



Legend

Sea Girt Building 22 1st Floor

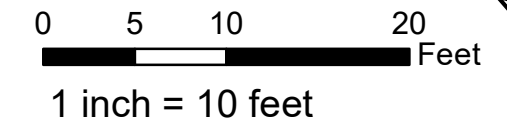-  Air Conditioning Unit
-  Drinking Water Fountain
-  Forced Air Heater
-  Hot Water Heater
-  Light Ballast
-  No FLBs
-  Refrigeration Unit
-  Water Cooler



Notes:


Floor plans georeferenced via headsup digitizing over 2015 aerial photography
Locations of air emissions, ODS, and FLBs georeferenced via floor plans



Scale: 1 inch = 10 feet
File: ST9
Date: 5/21/2019
Created By: Rosalie Hood,
Anne Timmreck,
Raina Ryan,
Alexandria Petrosch

**Rowan
University
&
Stockton
University**


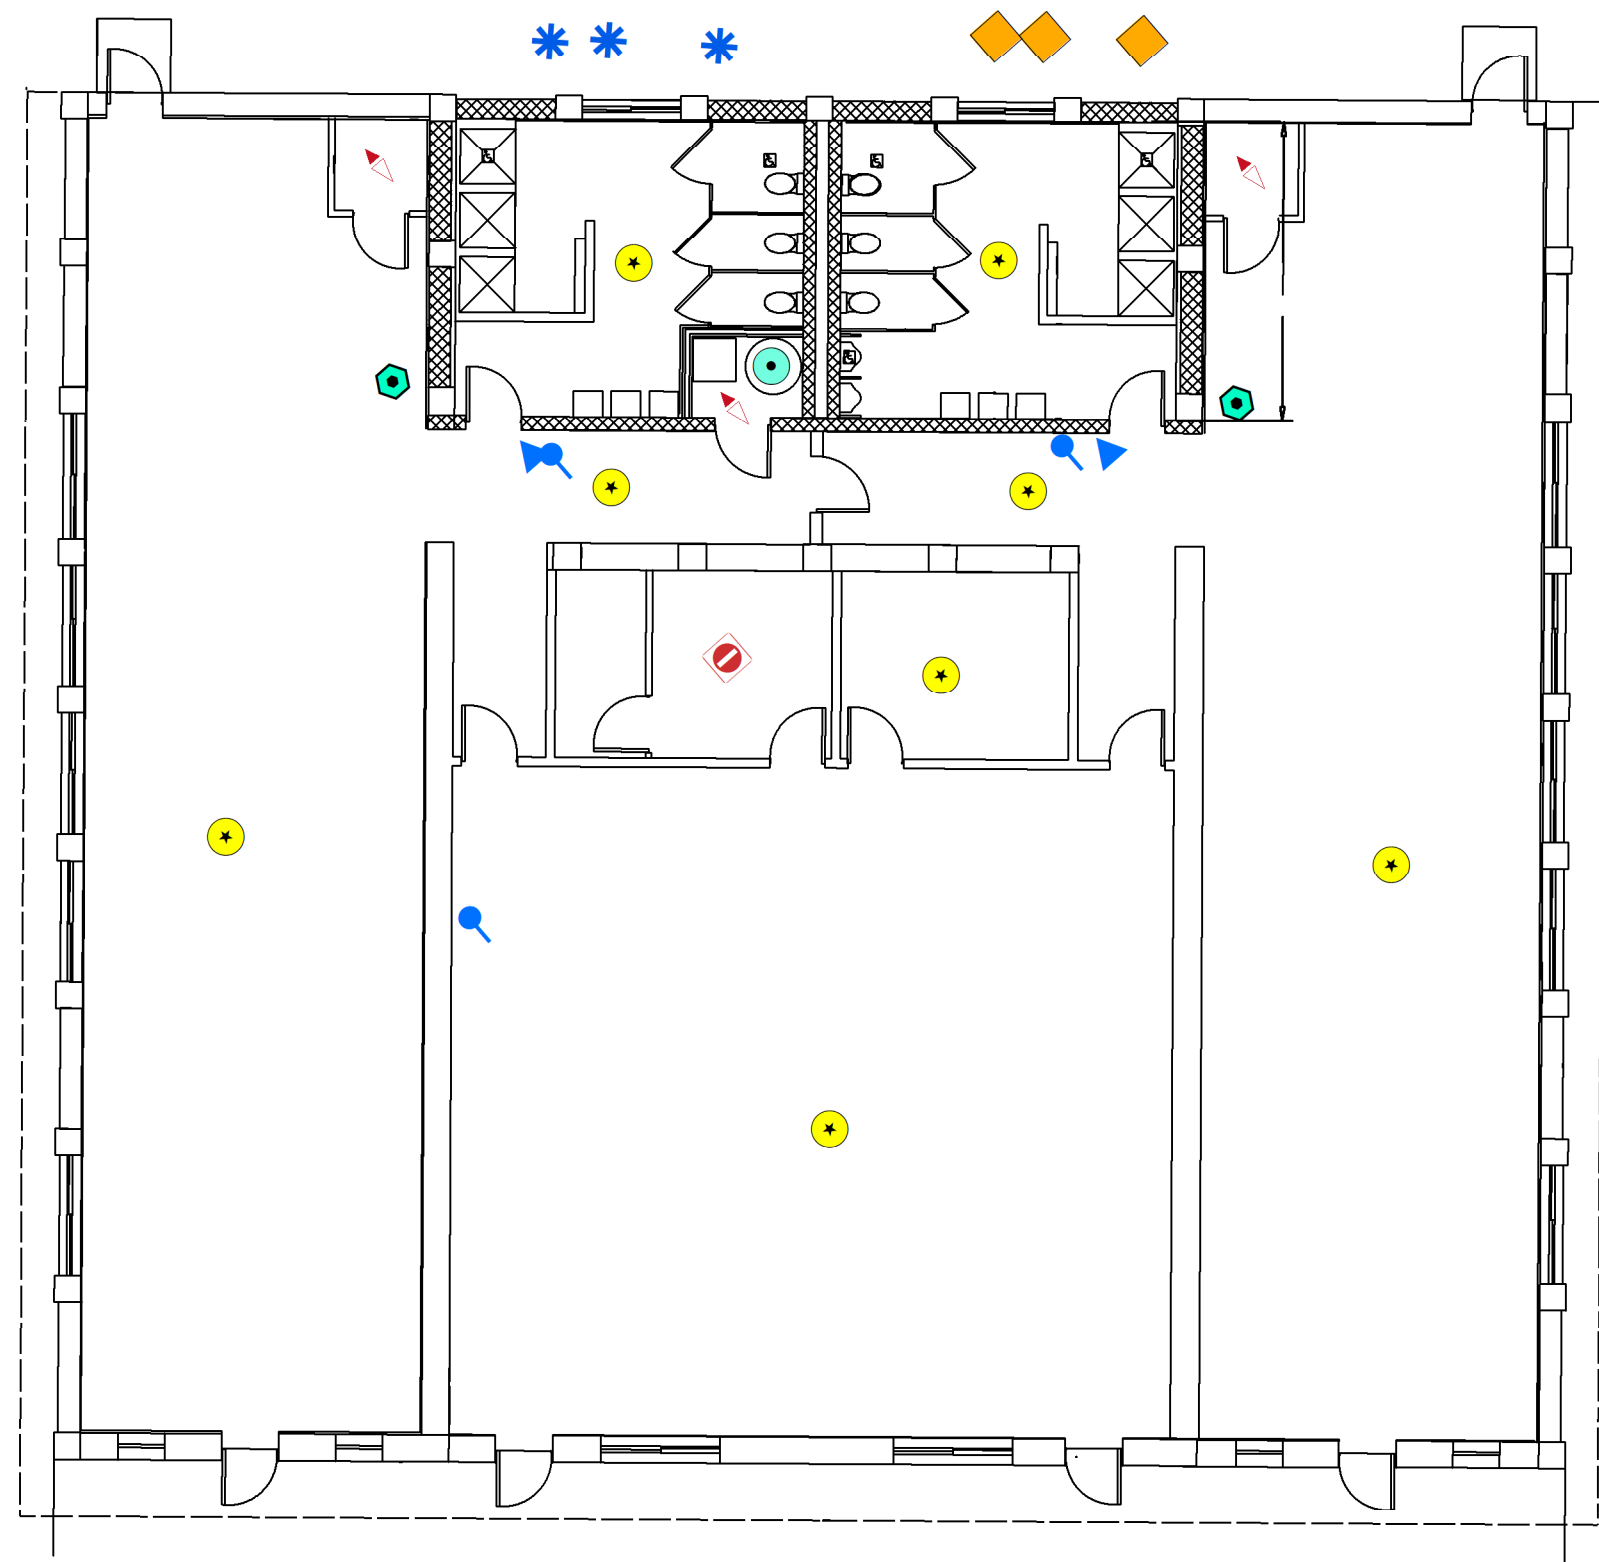
**Figure ST10
Site Map with
Site Level Features
Sea Girt Armory
Bldg 23**



Legend

Sea Girt Building 23 1st Floor

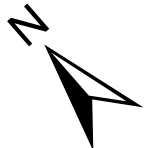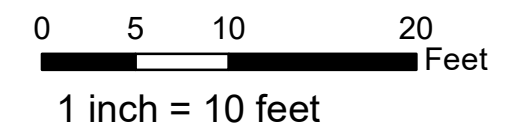- Air Conditioning Unit
- Drinking Water Fountain
- Forced Air Heater
- Hot Water Heater
- Light Ballast
- No Access
- No FLBs
- Refrigeration Unit
- Water Cooler



Notes:

Floor plans georeferenced via headsup digitizing over 2015 aerial photography
Locations of air emissions, ODS, and FLBs georeferenced via floor plans




Scale: 1 inch = 10 feet
File: ST10
Date: 5/21/2019
Created By: Rosalie Hood,
Anne Timmreck,
Raina Ryan,
Alexandria Petrosch

**Rowan
University
&
Stockton
University**




Basic Floor Plan
Bldg 20-24 & 24-25 & 23-12
See Grid

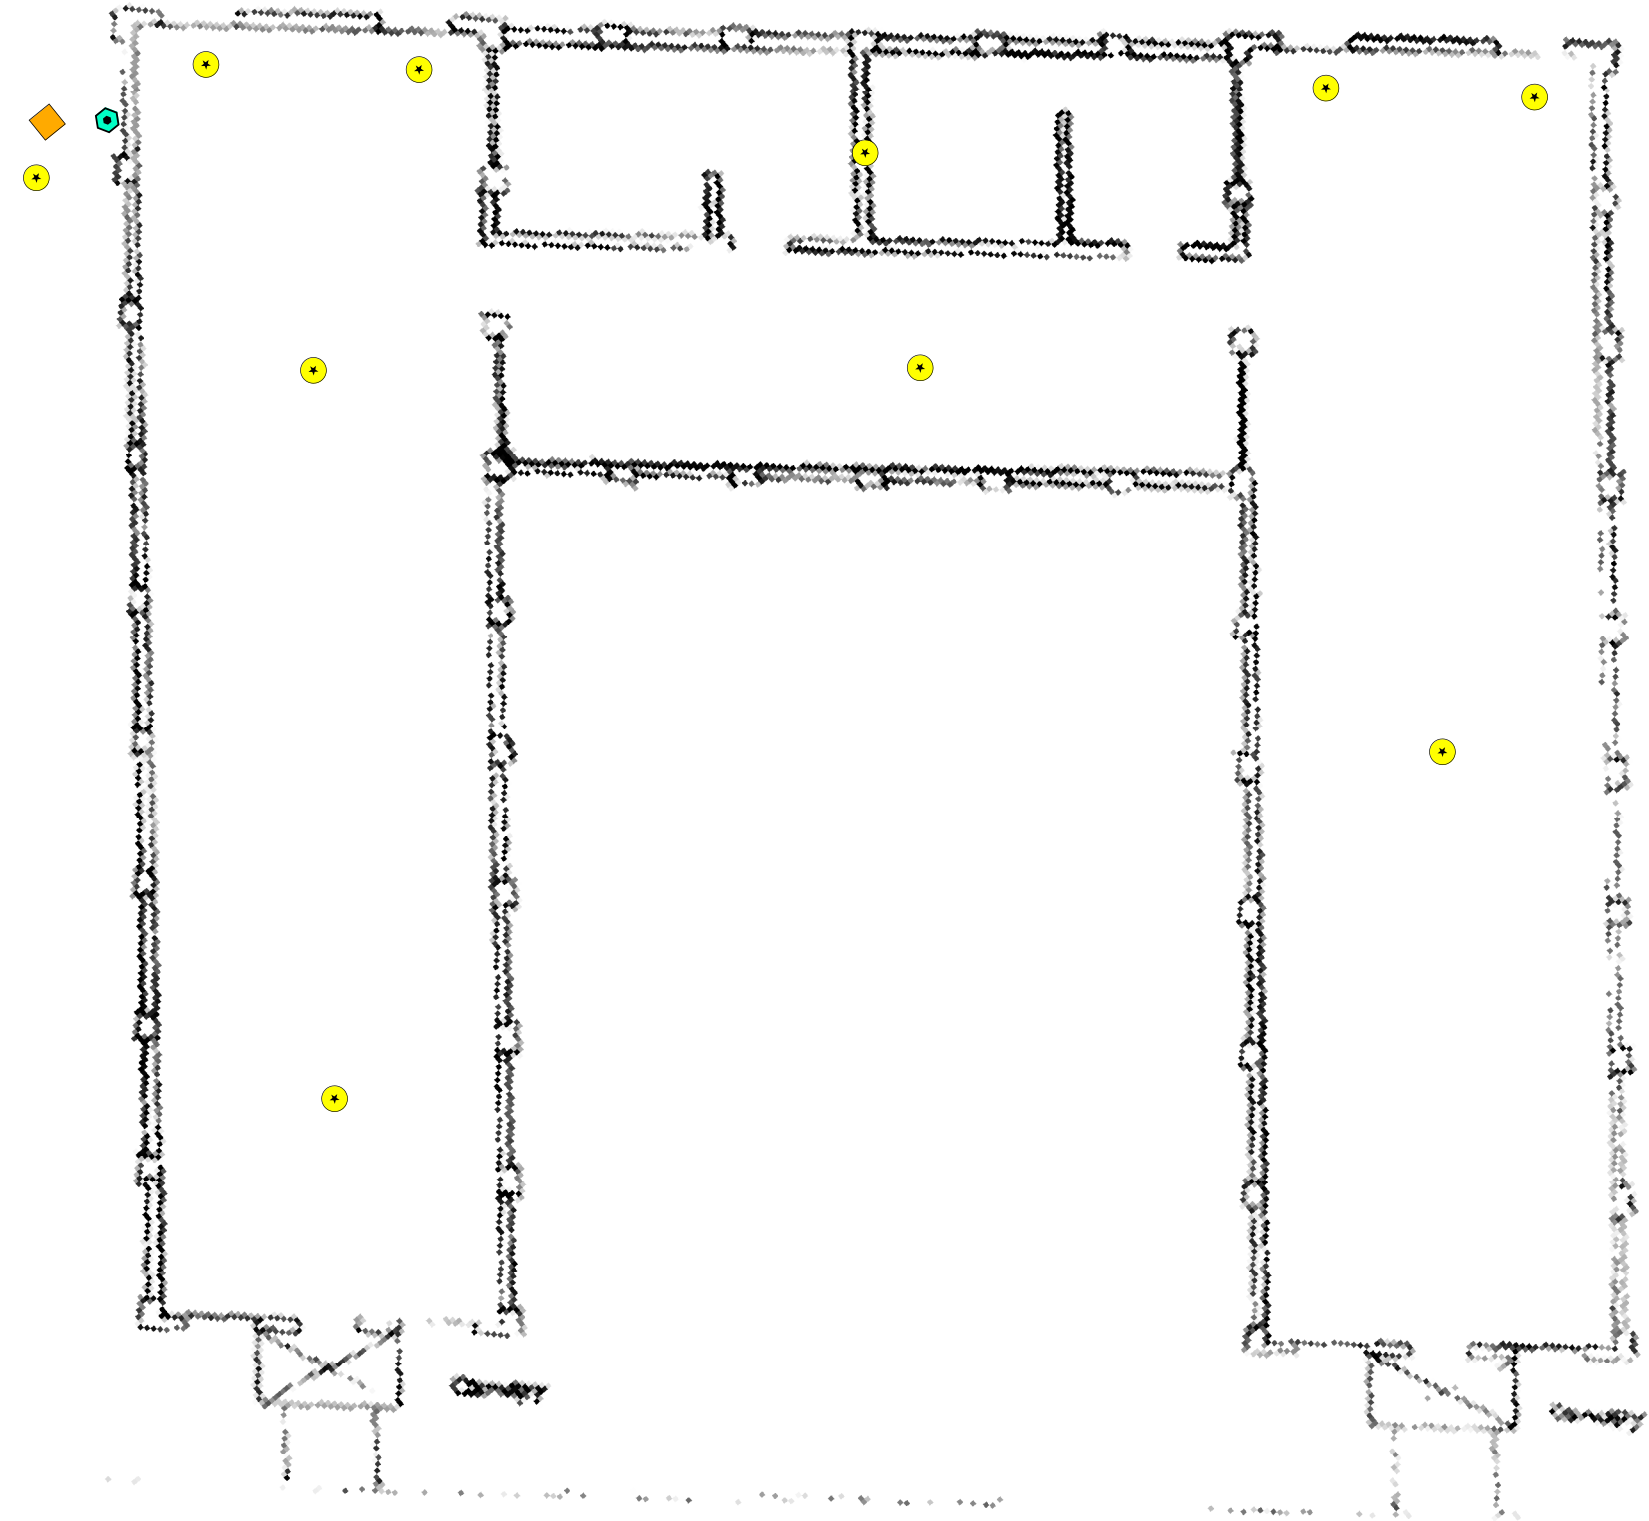
Figure ST11
Site Map with
Site Level Features
Sea Girt Armory
Bldg 24



Legend

Sea Girt Building 24 1st Floor

 -  Forced Air Heater
-  Light Ballast
-  Refrigeration Unit



1 inch = 10 feet



Notes:


Floor plans georeferenced via headsup digitizing over 2015 aerial photography
Locations of air emissions, ODS, and FLBs georeferenced via floor plans



Scale: 1 inch = 10 feet
File: ST11
Date: 5/21/2019
Created By: Rosalie Hood,
Anne Timmreck,
Raina Ryan,
Alexandria Petrosch



Rowan
University
&
Stockton
University

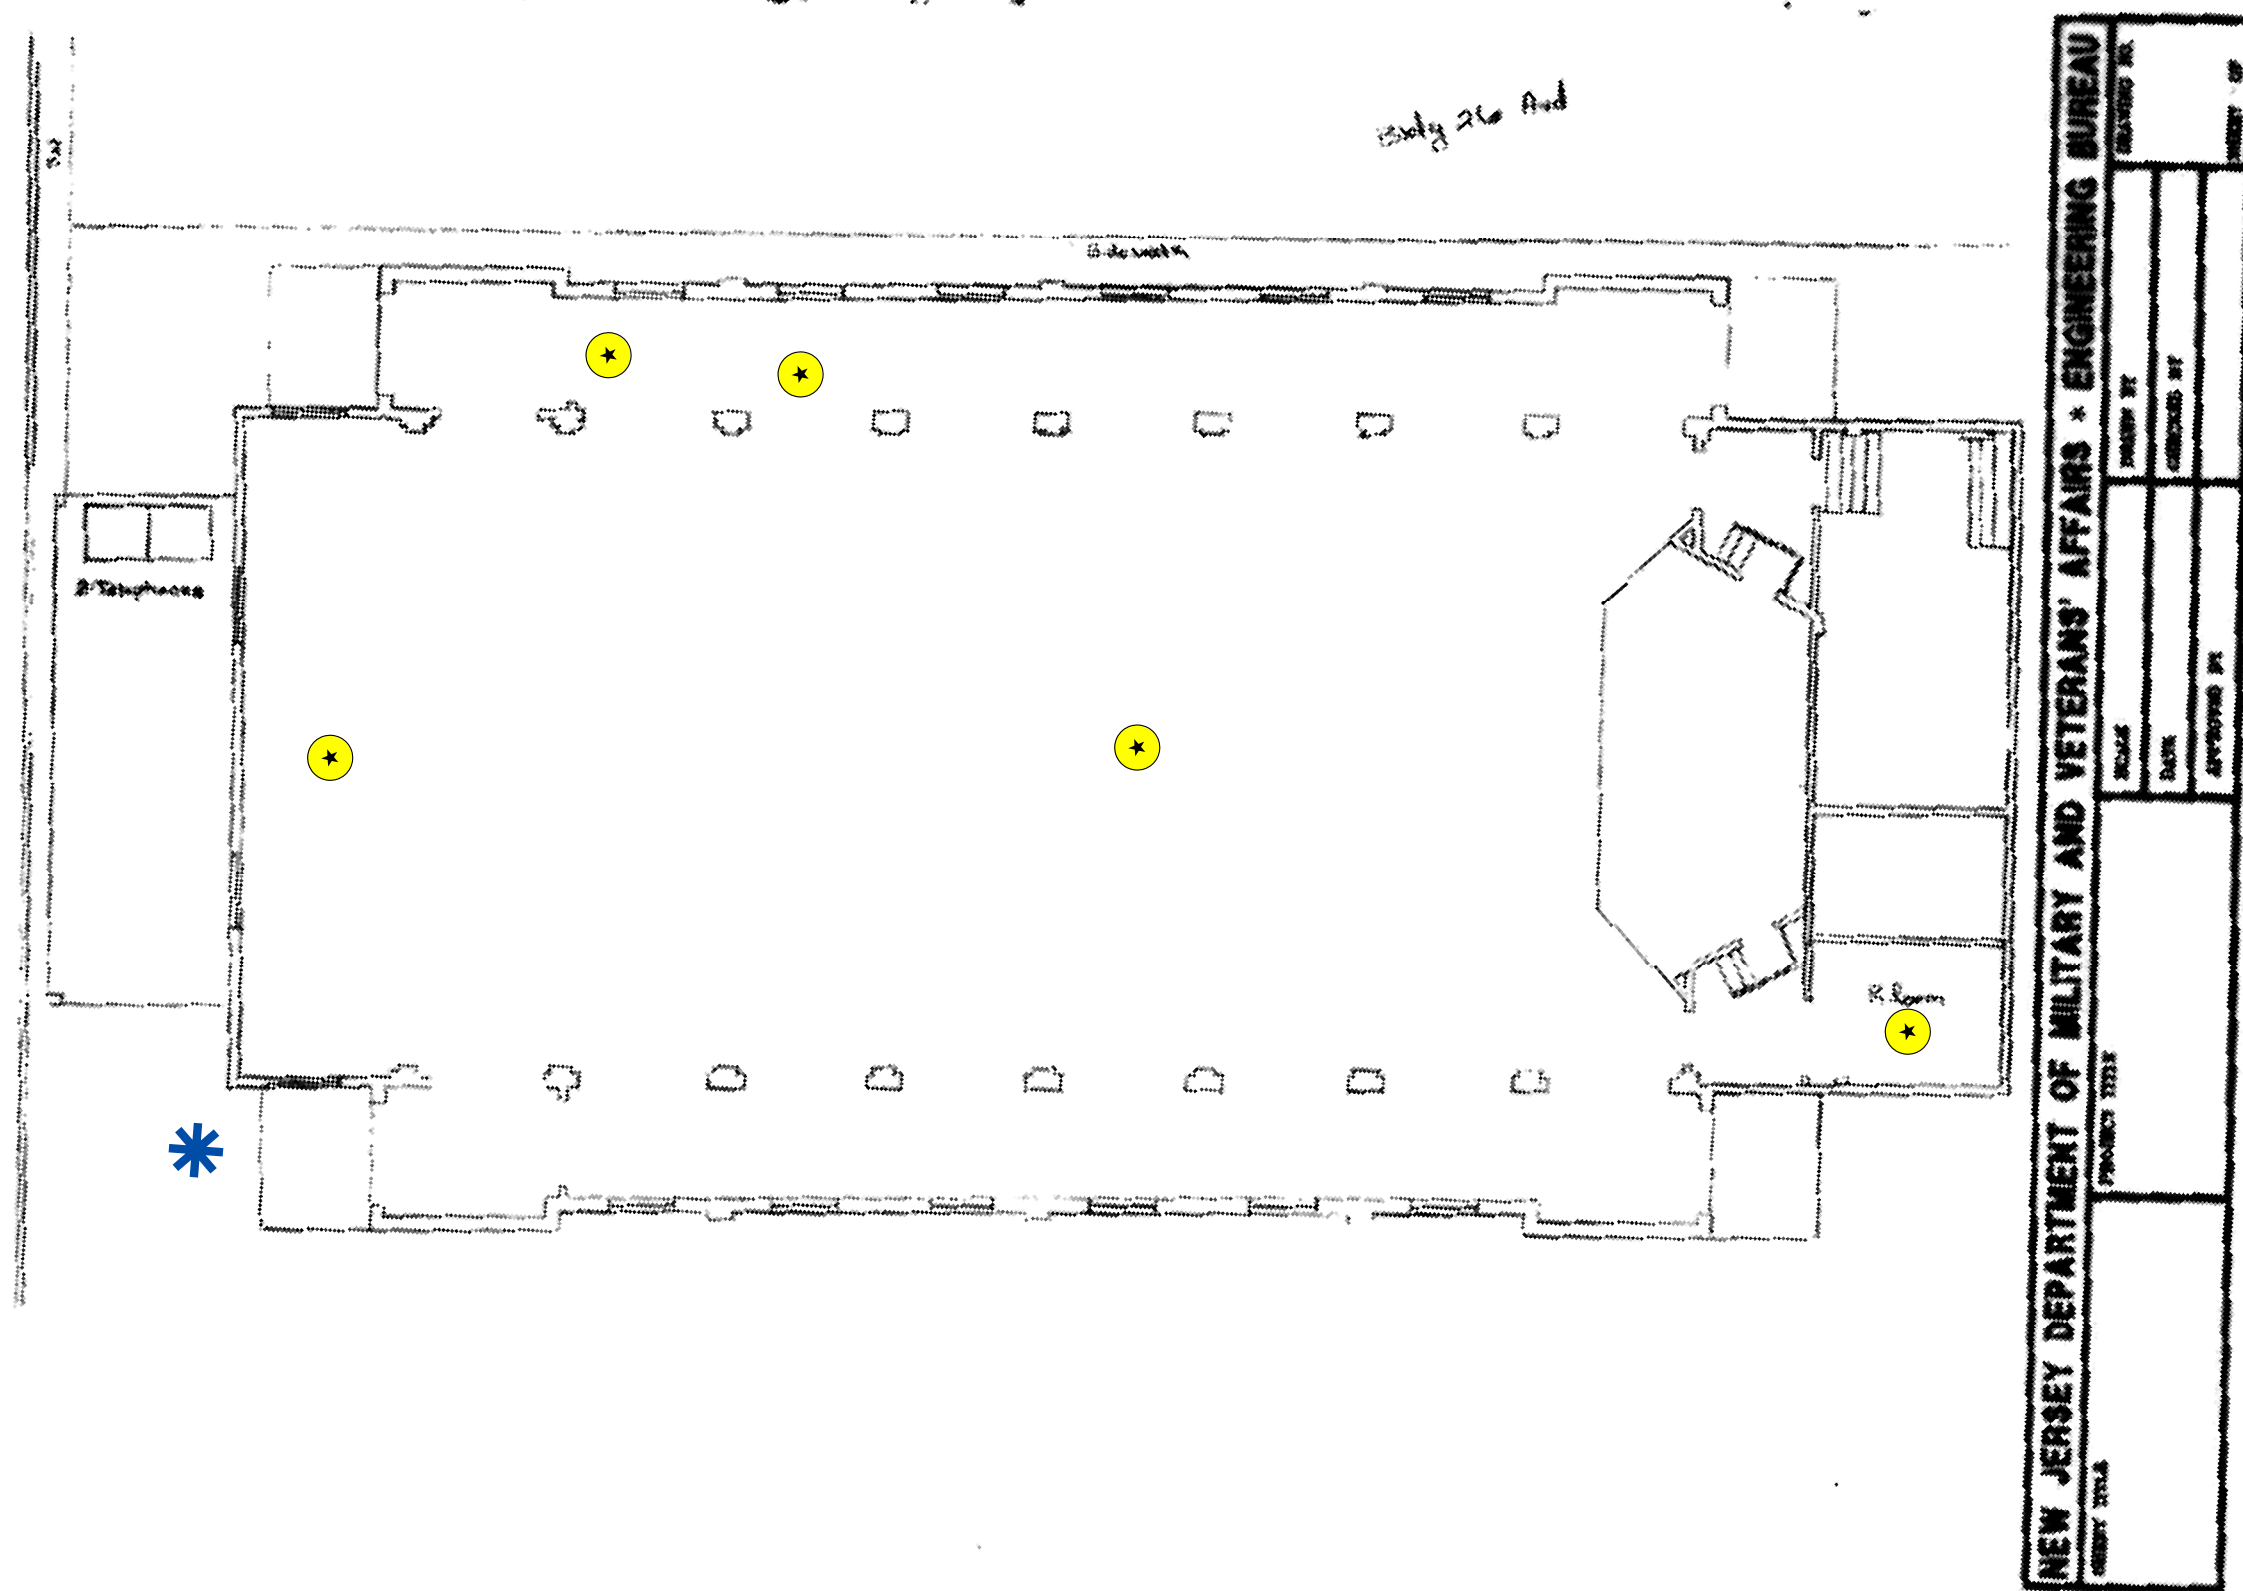
**Figure ST12
Site Map with
Site Level Features
Sea Girt Armory
Bldg 26**




Legend

Sea Girt Building 26 1st Floor

 -  Air Conditioning Unit
-  Light Ballast



1 inch = 10 feet

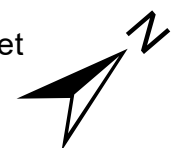

Notes:

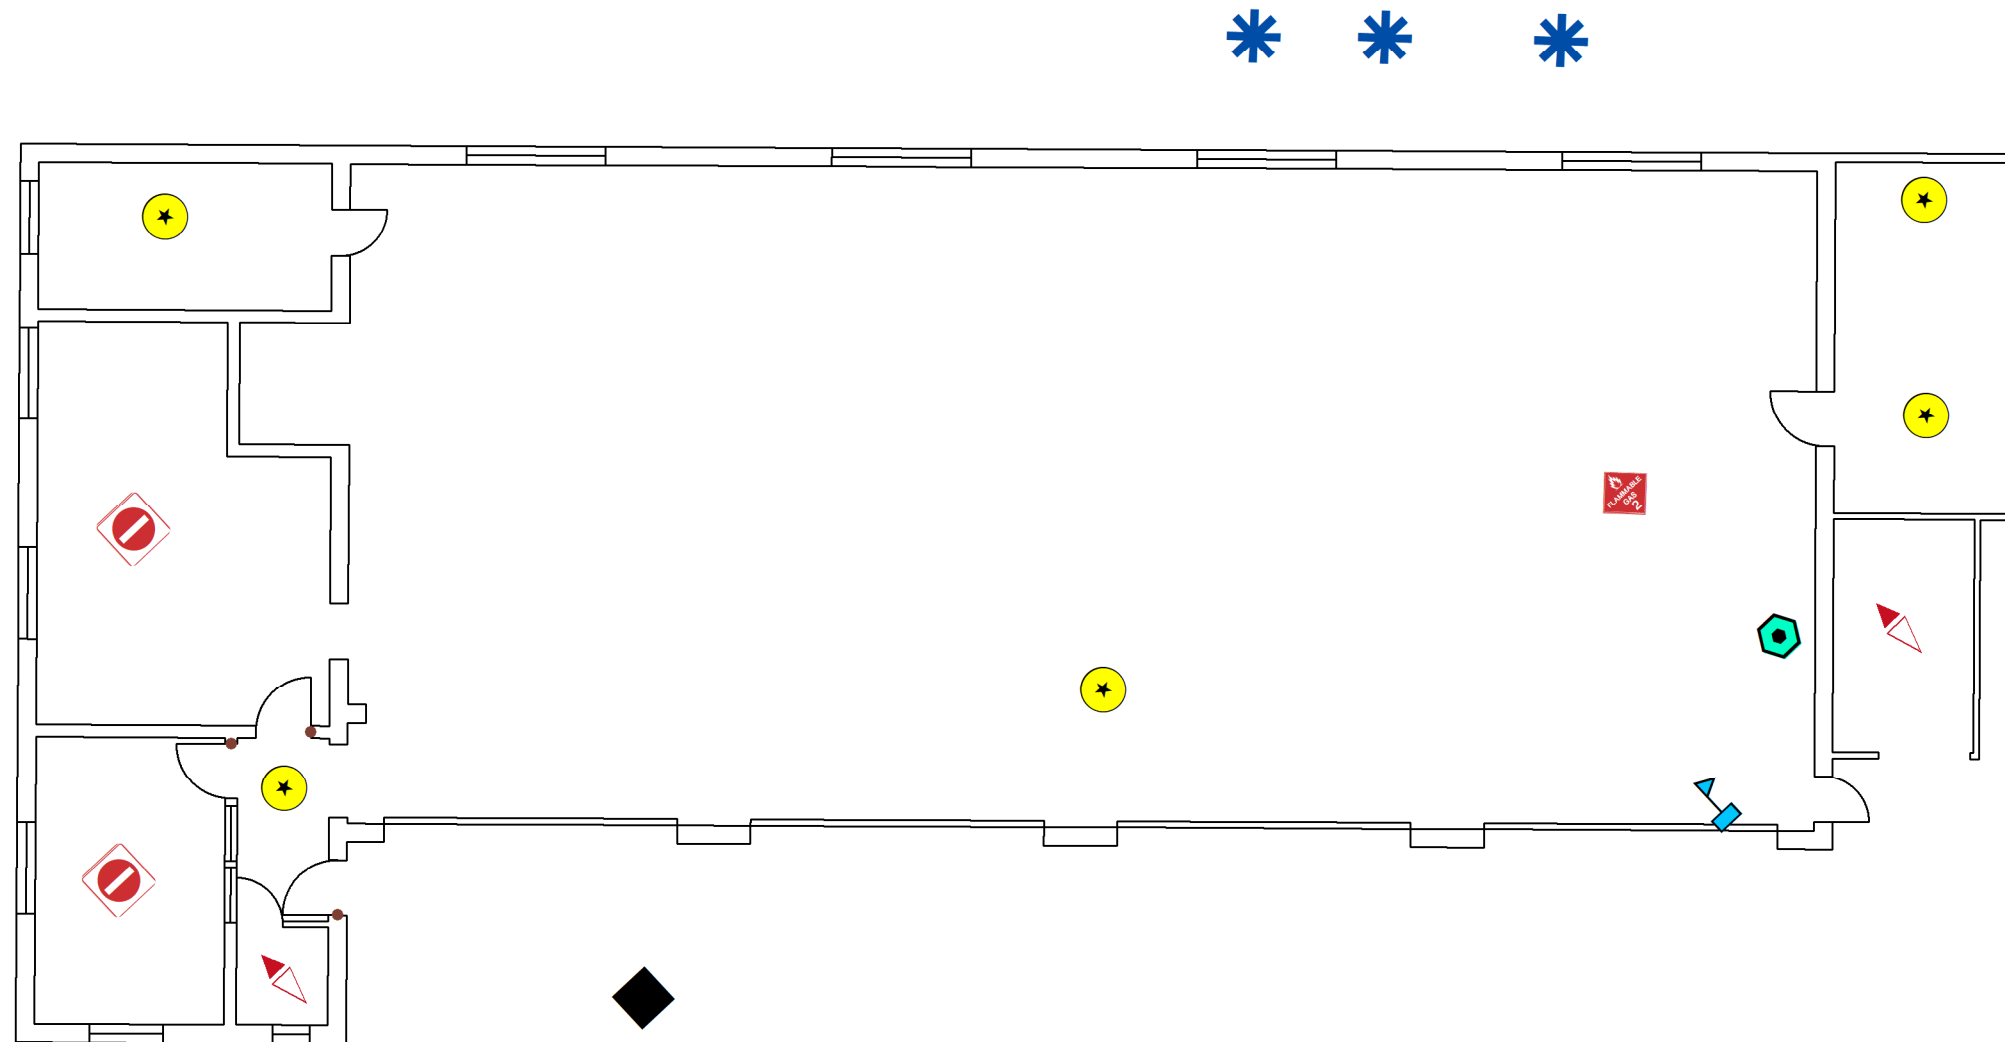
Floor plans georeferenced via headsup digitizing over 2015 aerial photography
Locations of air emissions, ODS, and FLBs georeferenced via floor plans



Scale: 1 inch = 10 feet
File: ST12
Date: 5/21/2019
Created By: Rosalie Hood,
Anne Timmreck,
Raina Ryan,
Alexandria Petrosch






 


Rowan
University
&
Stockton
University


**Figure ST13
Site Map with
Site Level Features
Sea Girt Armory
Bldg 36**



Legend

Sea Girt Building 36 1st Floor

 -  Air Conditioning Unit
-  Flammable Cabinet
-  Light Ballast
-  No Access
-  No FLBs
-  Parts Washer
-  Refrigeration Unit
-  Storage Tank



1 inch = 10 feet



Notes:


Floor plans georeferenced via headsup digitizing over 2015 aerial photography
Locations of air emissions, ODS, and FLBs georeferenced via floor plans



Scale: 1 inch = 10 feet
File: ST13
Date: 5/21/2019
Created By: Rosalie Hood,
Anne Timmreck,
Raina Ryan,
Alexandria Petrosch

**Rowan
University
&
Stockton
University**

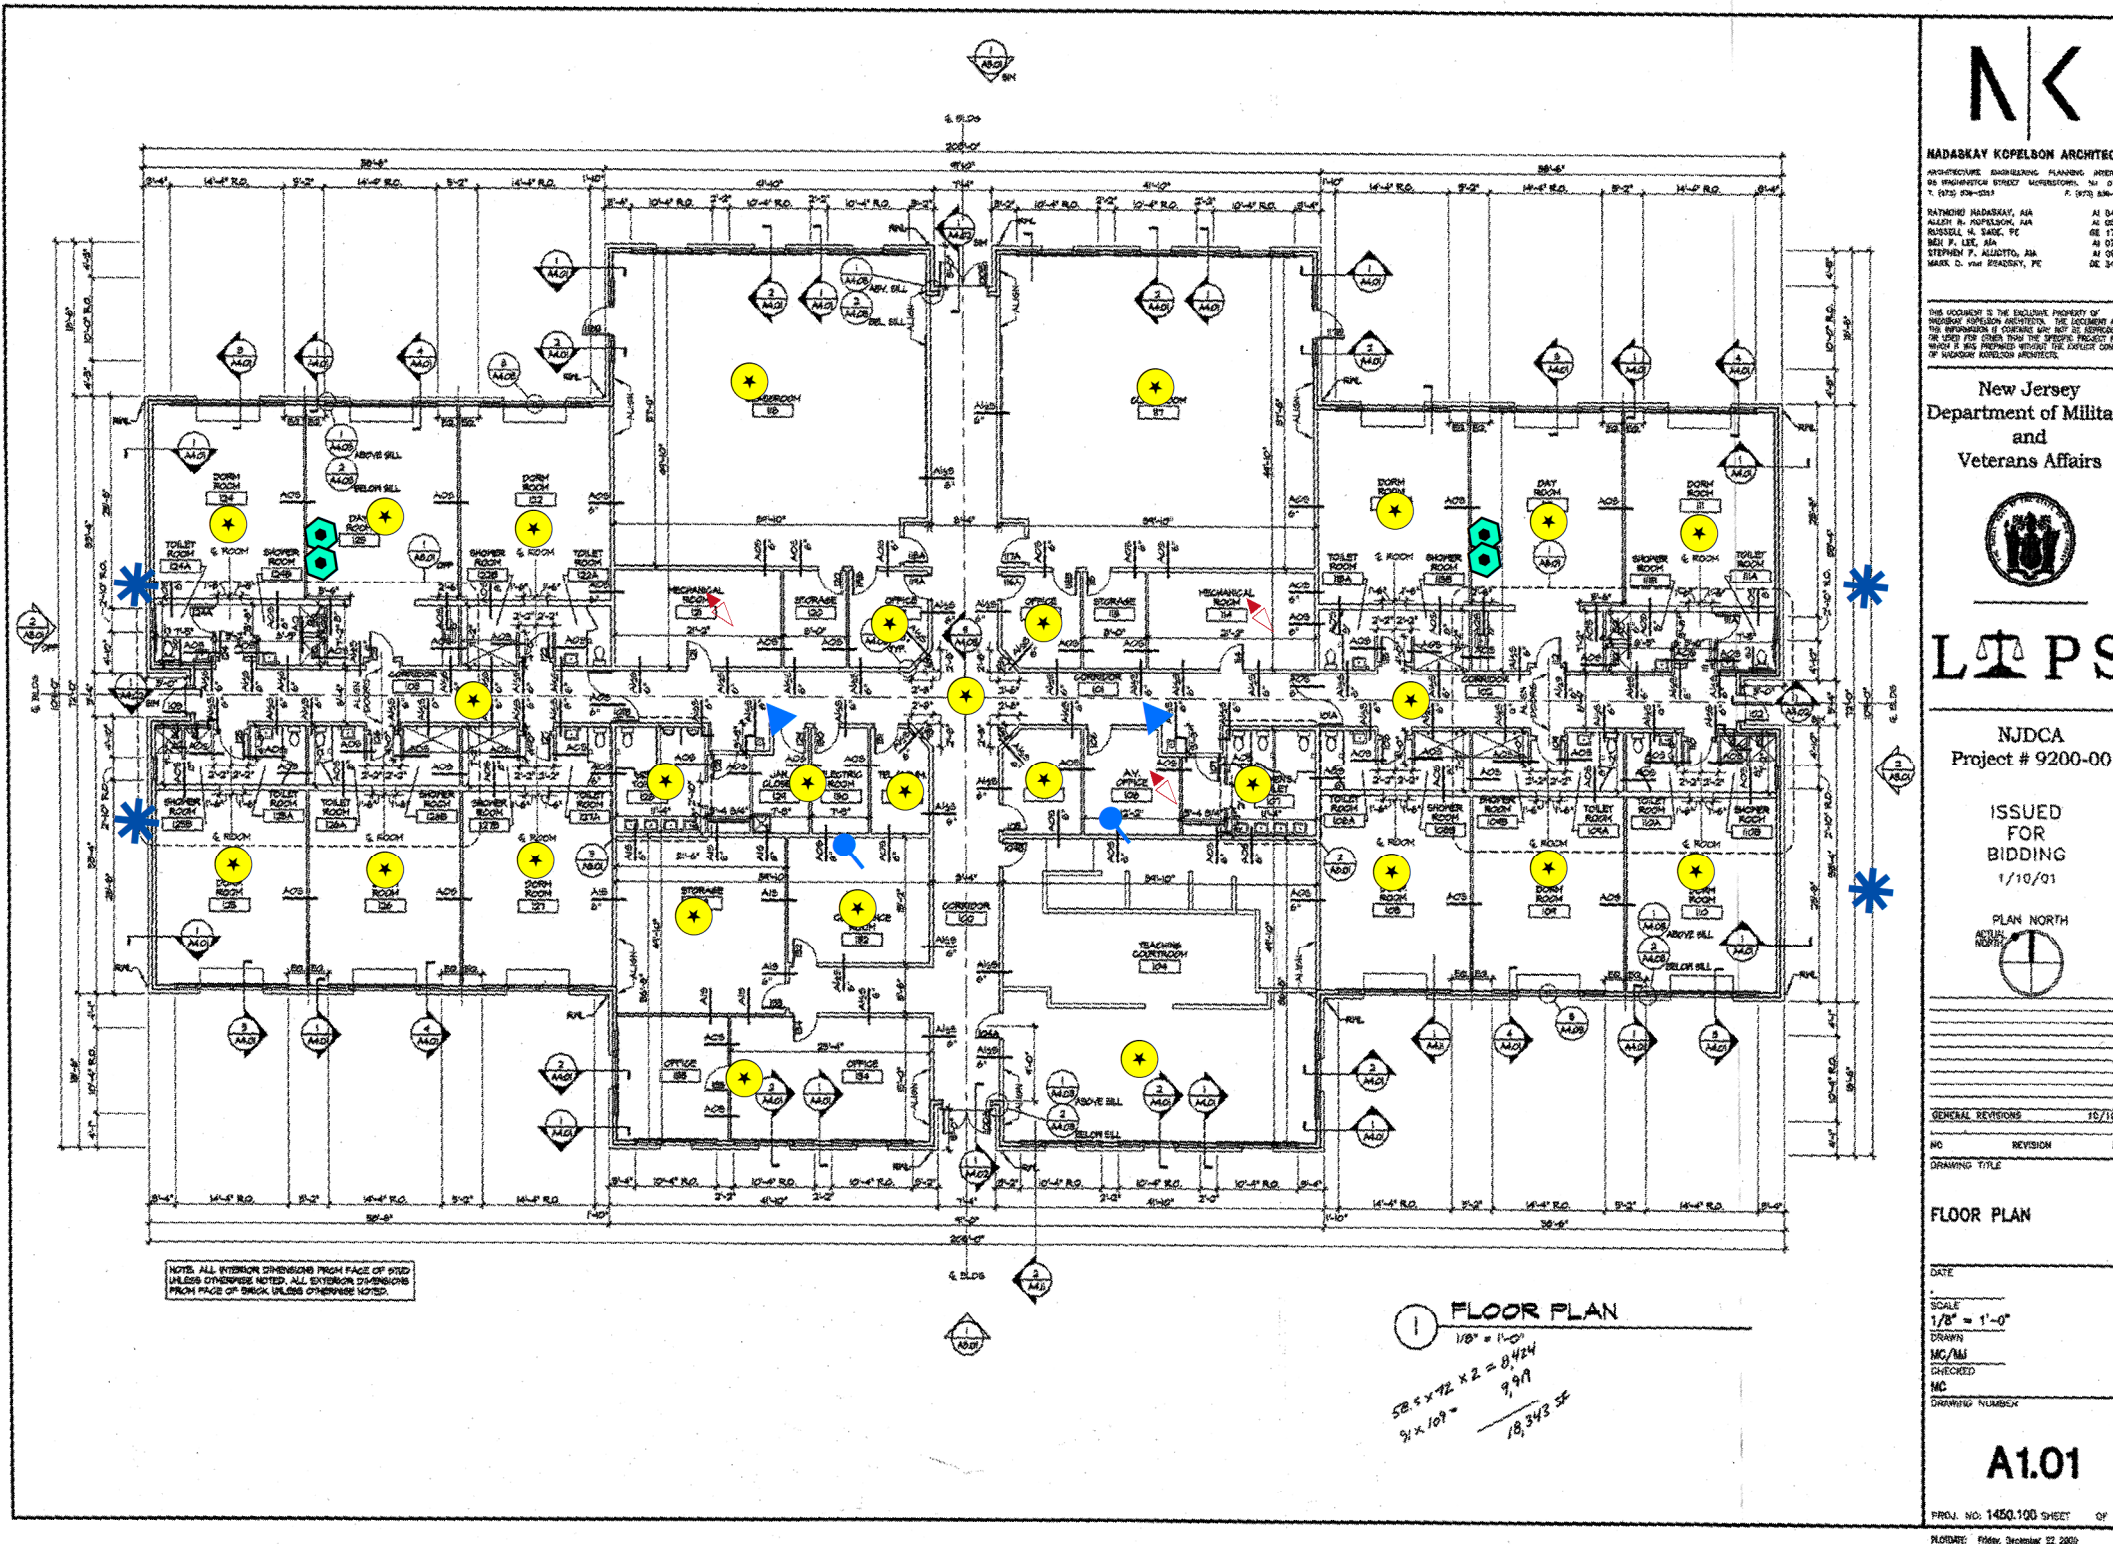**Figure ST14
Site Map with
Site Level Features
Sea Girt Armory
Bldg 37**



NK

HADARAY KOPELSON ARCHITECTS
ARCHITECTURE, INTERIORS, PLANNING, INTERIORS
66 HANOVER STREET, SUITE 200, NEW YORK, NY 10014
T: (212) 512-2243 F: (212) 512-1876

RATNOM HADARAY, AIA AI 04318
ALEXIS M. KOPELSON, AIA AI 02844
RUSSELL M. SAGE, PE AE 17045
BEN F. LEE, AIA AI 07817
STEPHEN F. ALBERTO, AIA AI 02259
MAX D. VAN BRADLEY, PE DE 34284

THIS DOCUMENT IS THE EXCLUSIVE PROPERTY OF HADARAY KOPELSON ARCHITECTS. THE DOCUMENT AND THE INFORMATION IT CONTAINS ARE NOT TO BE REPRODUCED OR USED FOR OTHER THAN THE SPECIFIC PROJECT FOR WHICH IT WAS PREPARED WITHOUT THE EXPRESS CONSENT OF HADARAY KOPELSON ARCHITECTS.

**New Jersey
Department of Military
and
Veterans Affairs**

LTPS

**NJDCA
Project # 9200-00**

**ISSUED
FOR
BIDDING
1/10/01**

PLAN NORTH

GENERAL REVISIONS 15/19/01

NO.	REVISION	DATE

FLOOR PLAN

DATE: _____
SCALE: 1/8" = 1'-0"
DRAWN: _____
CHECKED: _____
DRAWING NUMBER: _____

A1.01

PROJ. NO: 1450.100 SHEET OF _____
FLOOR: 1st Floor, December 22, 2009

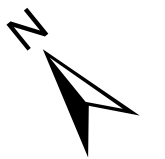
Legend

Sea Girt Building 37 1st Floor

- Air Conditioning Unit
- Drinking Water Fountain
- Light Ballast
- Refrigeration Unit
- No FLBs
- Water Cooler

0 12.5 25 50 Feet

1 inch = 25 feet



Notes:


Floor plans georeferenced via headsup digitizing over 2015 aerial photography
Locations of air emissions, ODS, and FLBs georeferenced via floor plans



Scale: 1 inch = 25 feet
File: ST14
Date: 5/21/2019
Created By: Rosalie Hood,
Anne Timmreck,
Raina Ryan,
Alexandria Petrosch




**Rowan
University
&
Stockton
University**

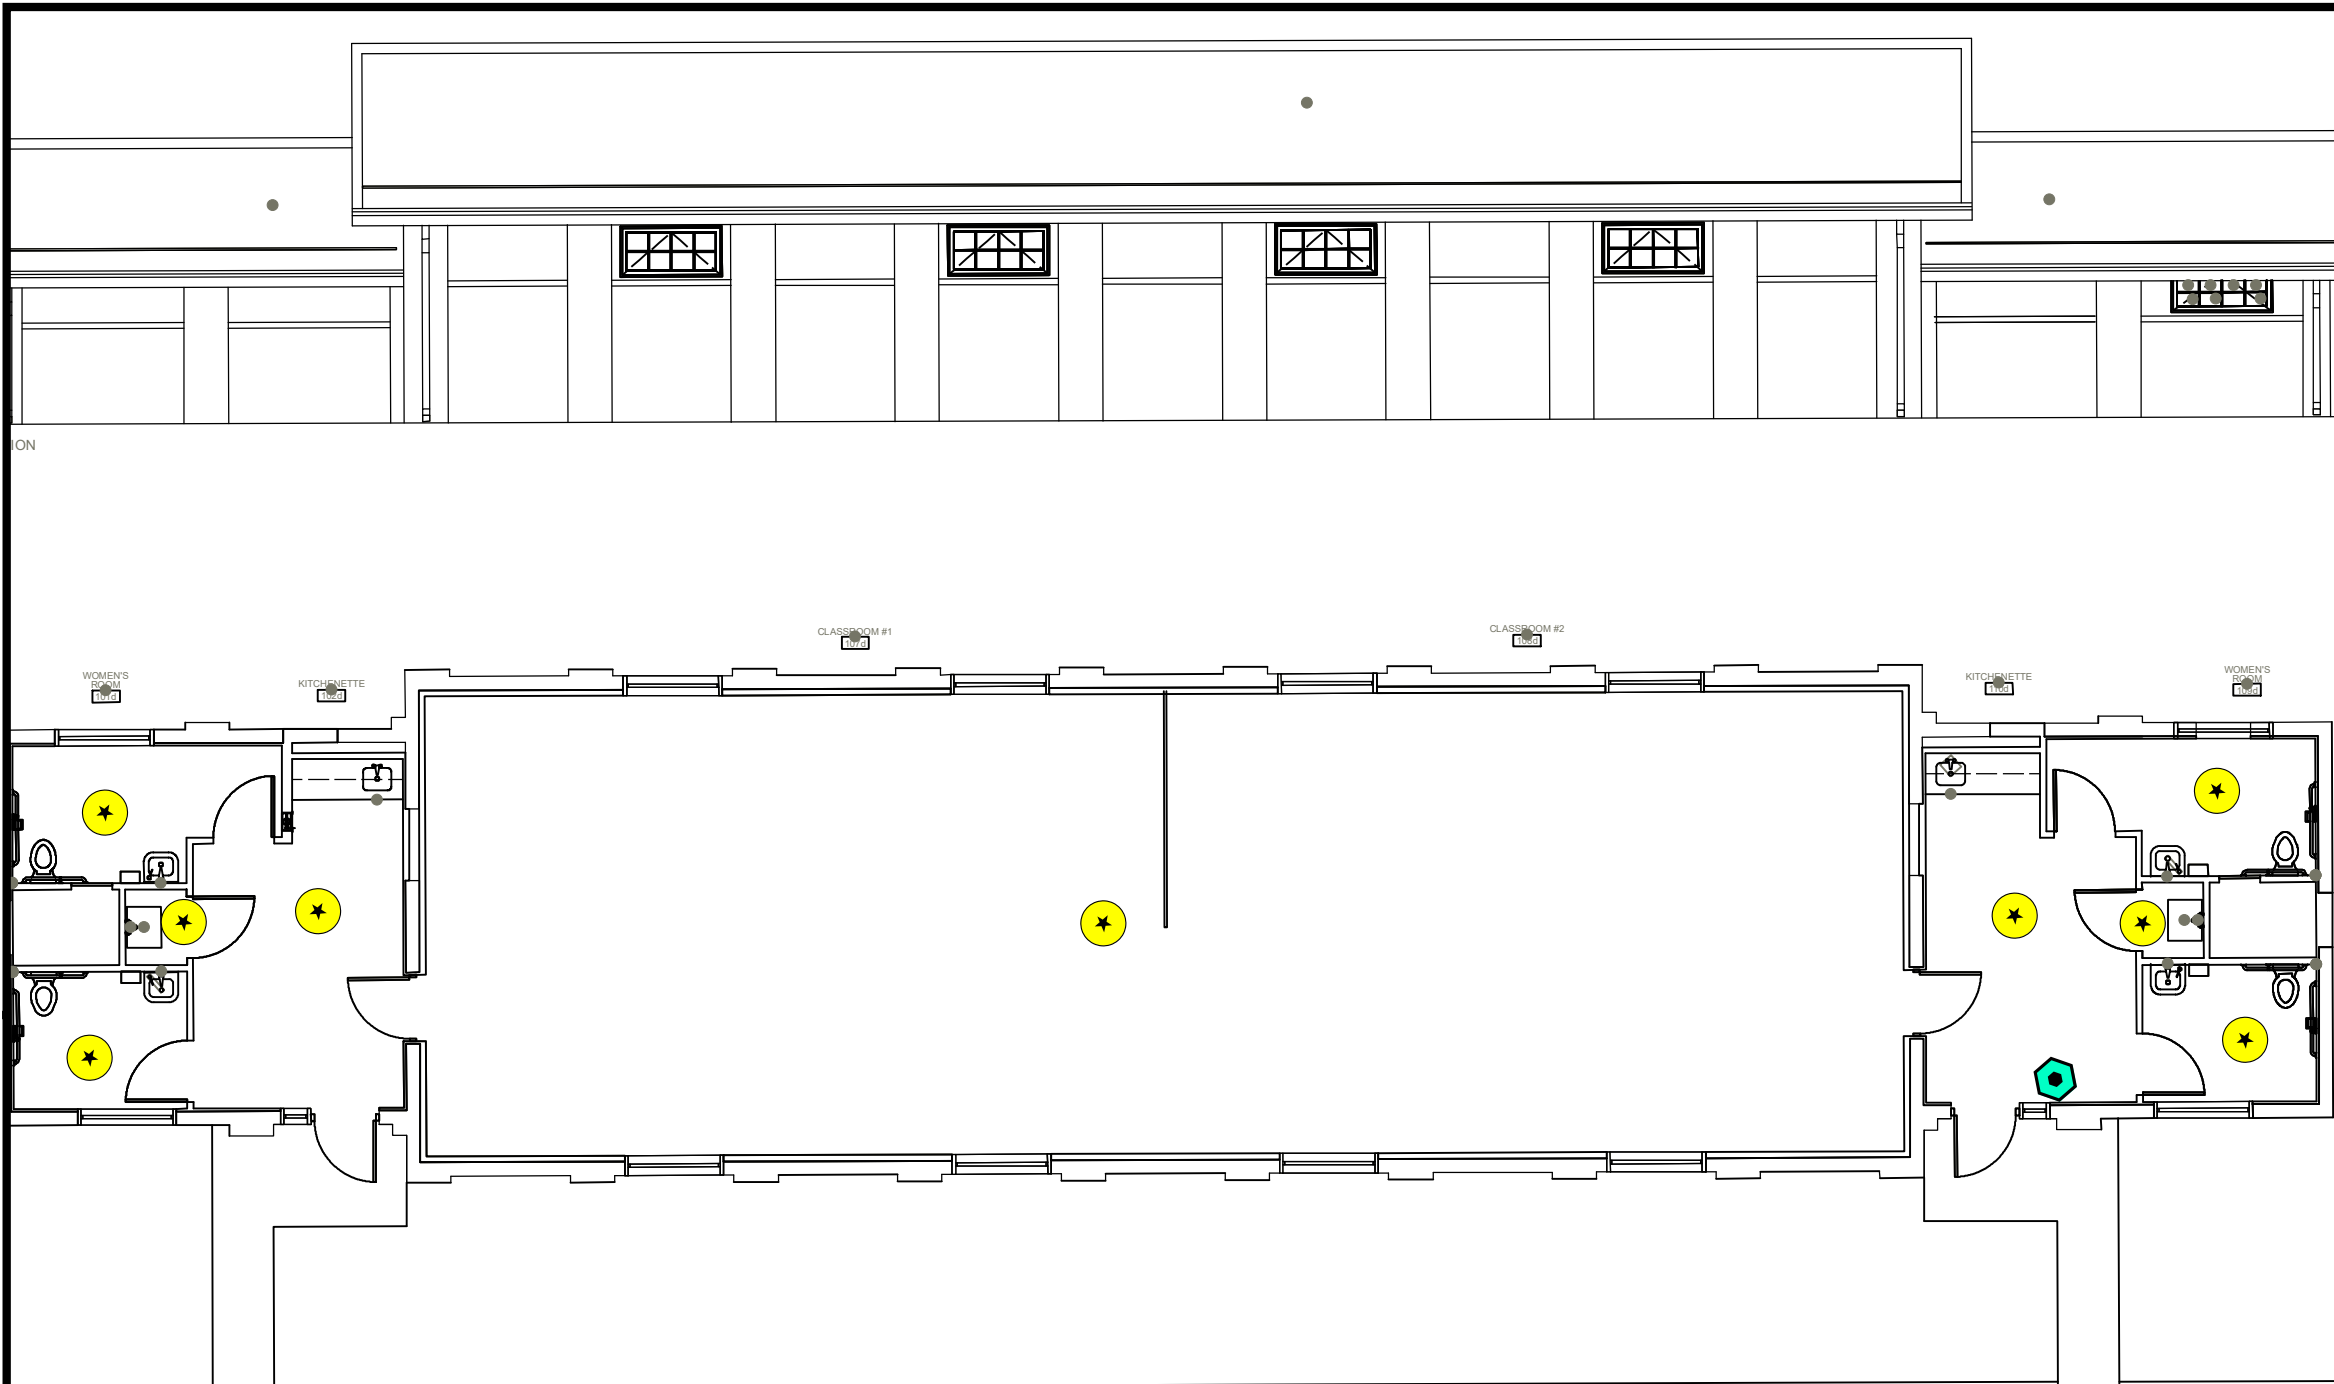**Figure ST15
Site Map with
Site Level Features
Sea Girt Armory
Bldg 54**



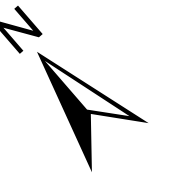
Legend

Sea Girt Building 54 1st Floor

-  Air Conditioning Unit
-  Light Ballast
-  Refrigeration Unit

0 5 10 20 Feet

1 inch = 10 feet



Notes:


Floor plans georeferenced via headsup digitizing over 2015 aerial photography
Locations of air emissions, ODS, and FLBs georeferenced via floor plans



Scale: 1 inch = 10 feet
File: ST15
Date: 5/21/2019
Created By: Rosalie Hood,
Anne Timmreck,
Raina Ryan,
Alexandria Petrosch

**Rowan
University
&
Stockton
University**

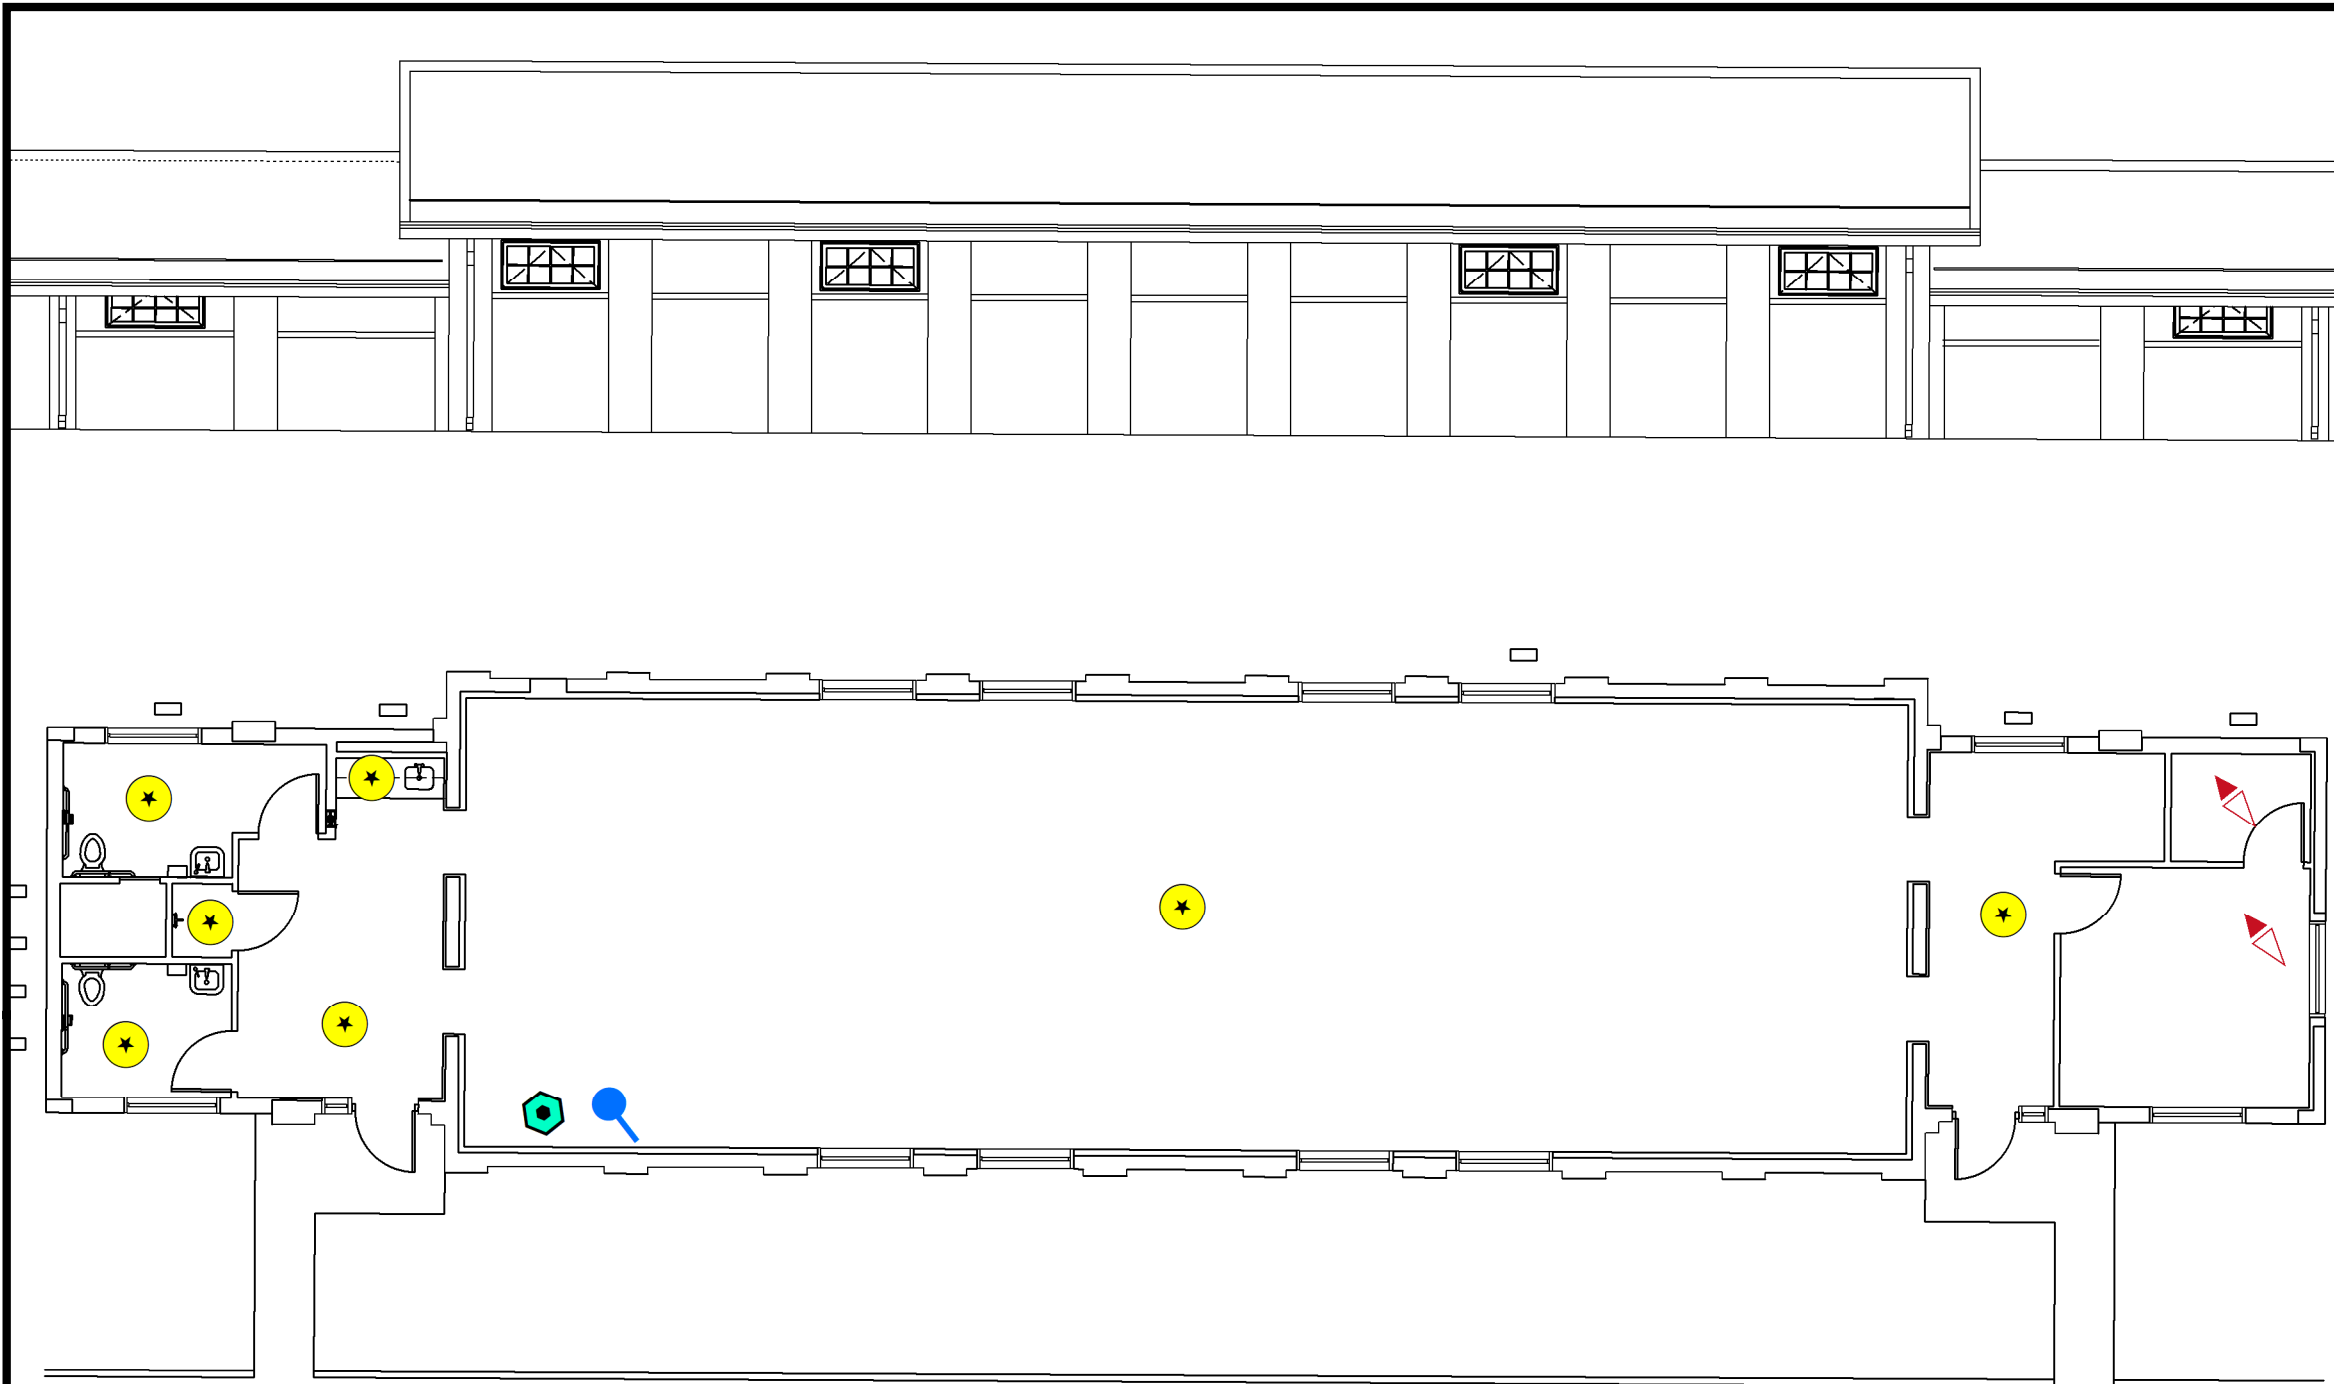**Figure ST16
Site Map with
Site Level Features
Sea Girt Armory
Bldg 56**



Legend

Sea Girt Building 56 1st Floor

★ Light Ballast

▽ No FLBs

⬡ Refrigeration Unit

● Water Cooler

0 5 10 20 Feet

1 inch = 10 feet



Notes:

Floor plans georeferenced via headsup digitizing over 2015 aerial photography
Locations of air emissions, ODS, and FLBs georeferenced via floor plans



Scale: 1 inch = 10 feet

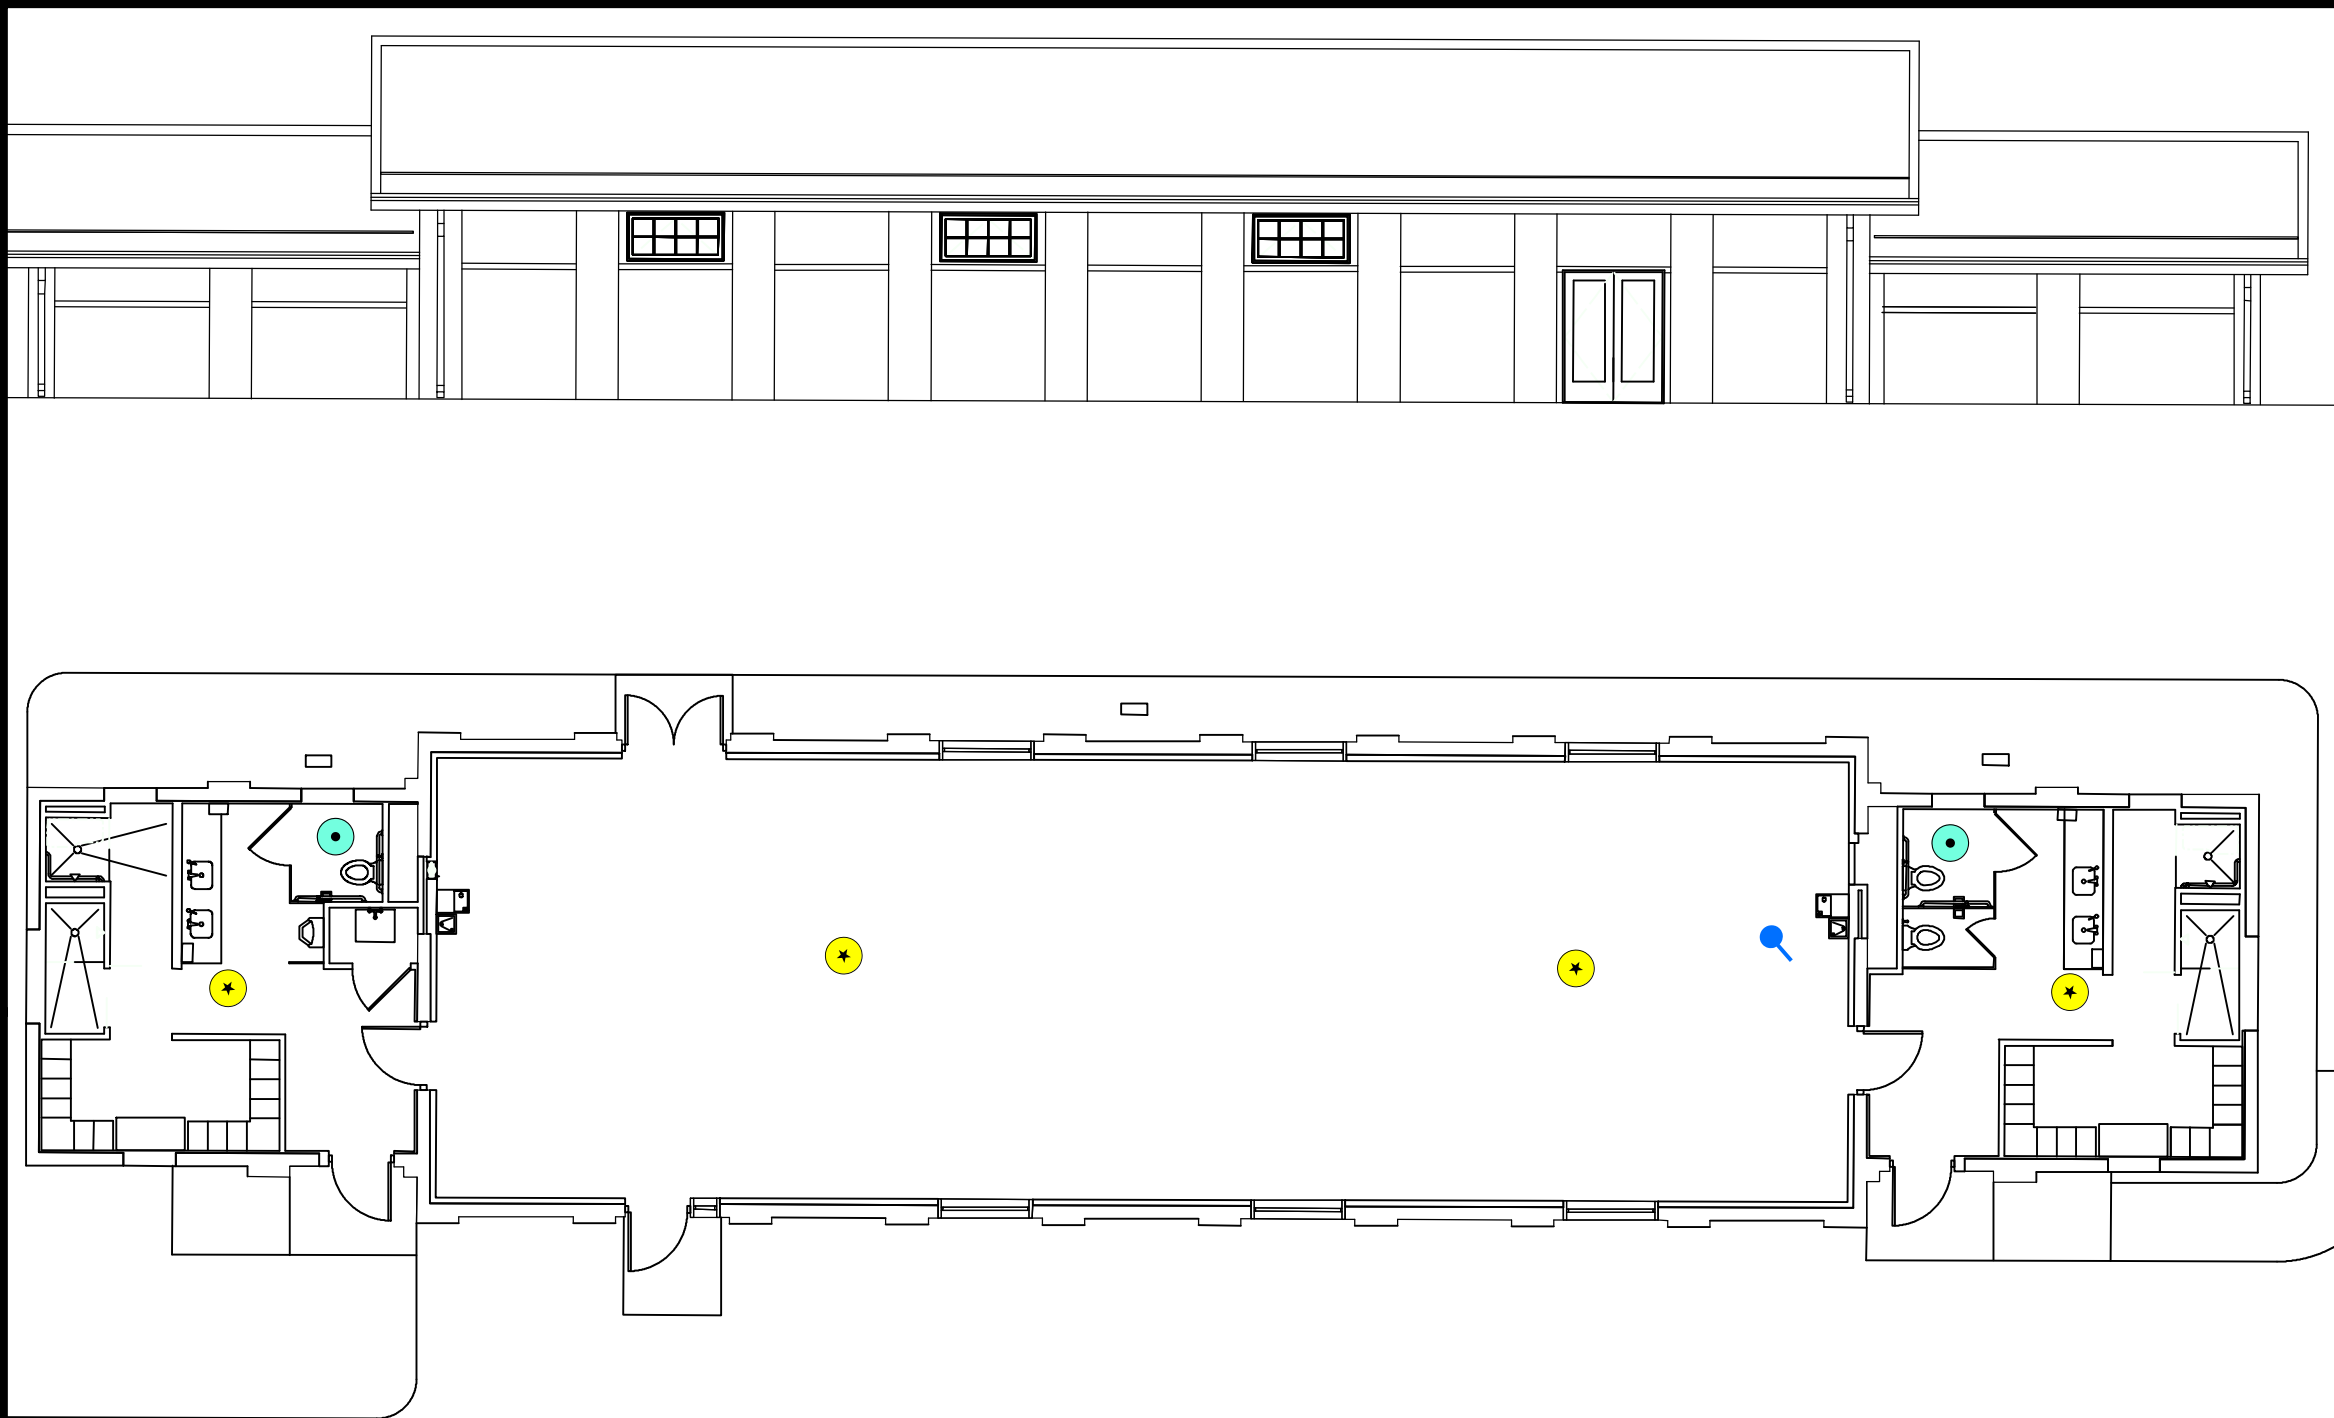
File: ST16

Date: 5/21/2019

Created By: Rosalie Hood,
Anne Timmreck,
Raina Ryan,
Alexandria Petrosch





**Rowan
University
&
Stockton
University**

**Figure ST17
Site Map with
Site Level Features
Sea Girt Armory
Bldg 58**



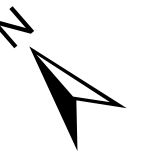
Legend

Sea Girt Building 58 1st Floor

-  Air Conditioning Unit
-  Hot Water Heater
-  Water Cooler
-  Light Ballast

0 5 10 20 Feet

1 inch = 10 feet



Notes:

Floor plans georeferenced via headsup digitizing over 2015 aerial photography
Locations of air emissions, ODS, and FLBs georeferenced via floor plans











Scale: 1 inch = 10 feet
File: ST17
Date: 5/21/2019
Created By: Rosalie Hood,
Anne Timmreck,
Raina Ryan,
Alexandria Petrosch


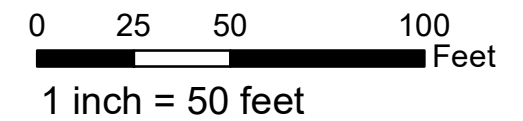
**Rowan
University
&
Stockton
University**

**Figure ST18
Site Map with
Site Level Features
Sea Girt Classroom & Off
Bldg 60**

Legend

Sea Girt Building 60 1st Floor

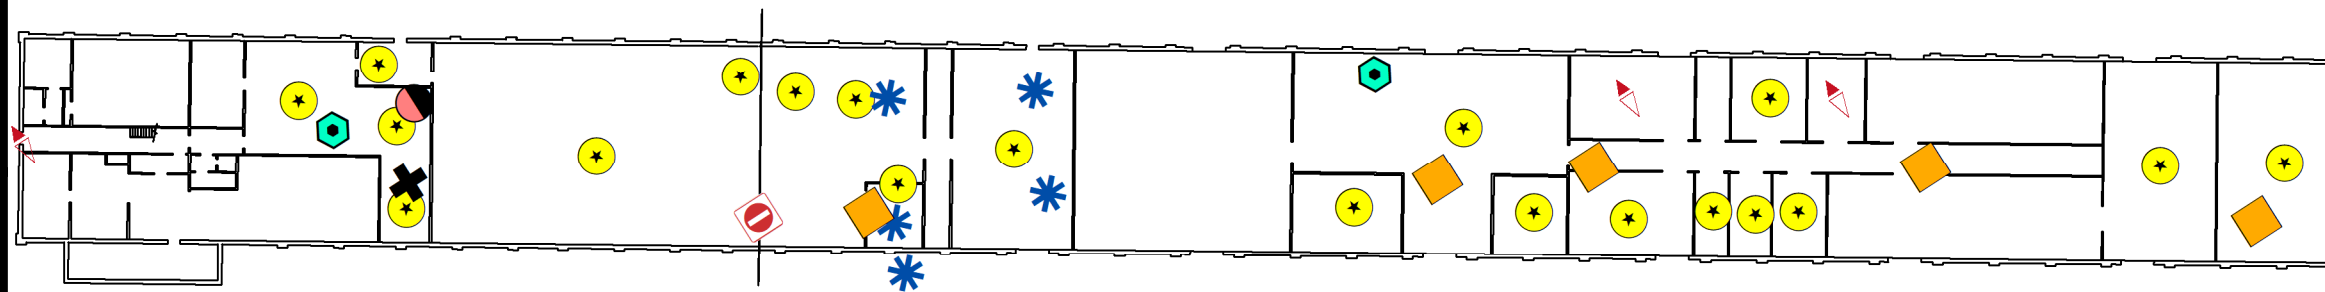-  Air Conditioning Unit
-  Boiler
-  Forced Air Heater
-  Light Ballast
-  No Access
-  No FLBs
-  Refrigeration Unit
-  Split Unit (Air Conditioner/Heater)



Notes:

Floor plans georeferenced via headsup digitizing over 2015 aerial photography
Locations of air emissions, ODS, and FLBs georeferenced via floor plans



Scale: 1 inch = 50 feet
File: ST18
Date: 5/21/2019
Created By: Rosalie Hood,
Anne Timmreck,
Raina Ryan,
Alexandria Petrosch


**Rowan
University
&
Stockton
University**

**Figure ST19
Site Map with
Site Level Features
Sea Girt Armory
Bldg 64**

Legend

Sea Girt Building 64 1st Floor

 Forced Air Heater

 No FLBs

0 7.5 15 30 Feet
1 inch = 15 feet



Notes:

Floor plans georeferenced via headsup digitizing over 2015 aerial photography
Locations of air emissions, ODS, and FLBs georeferenced via floor plans

NEW JERSEY DEPARTMENT OF MILITARY AND VETERANS' AFFAIRS + ENGINEERING BUREAU				
PROJECT TITLE	PROJECT TITLE	SCALE	DRAWN BY	DRAWING NO.
		DATE	CHECKED BY	
		APPROVED BY		REVISIONS





Scale: 1 inch = 15 feet
File: ST19
Date: 5/21/2019
Created By: Rosalie Hood,
Anne Timmreck,
Raina Ryan,
Alexandria Petrosch


Rowan
University
&
Stockton
University

**Figure ST20
Site Map with
Site Level Features
Sea Girt Armory Storage
Bldg 65**

Legend

Sea Girt Building 65 1st Floor

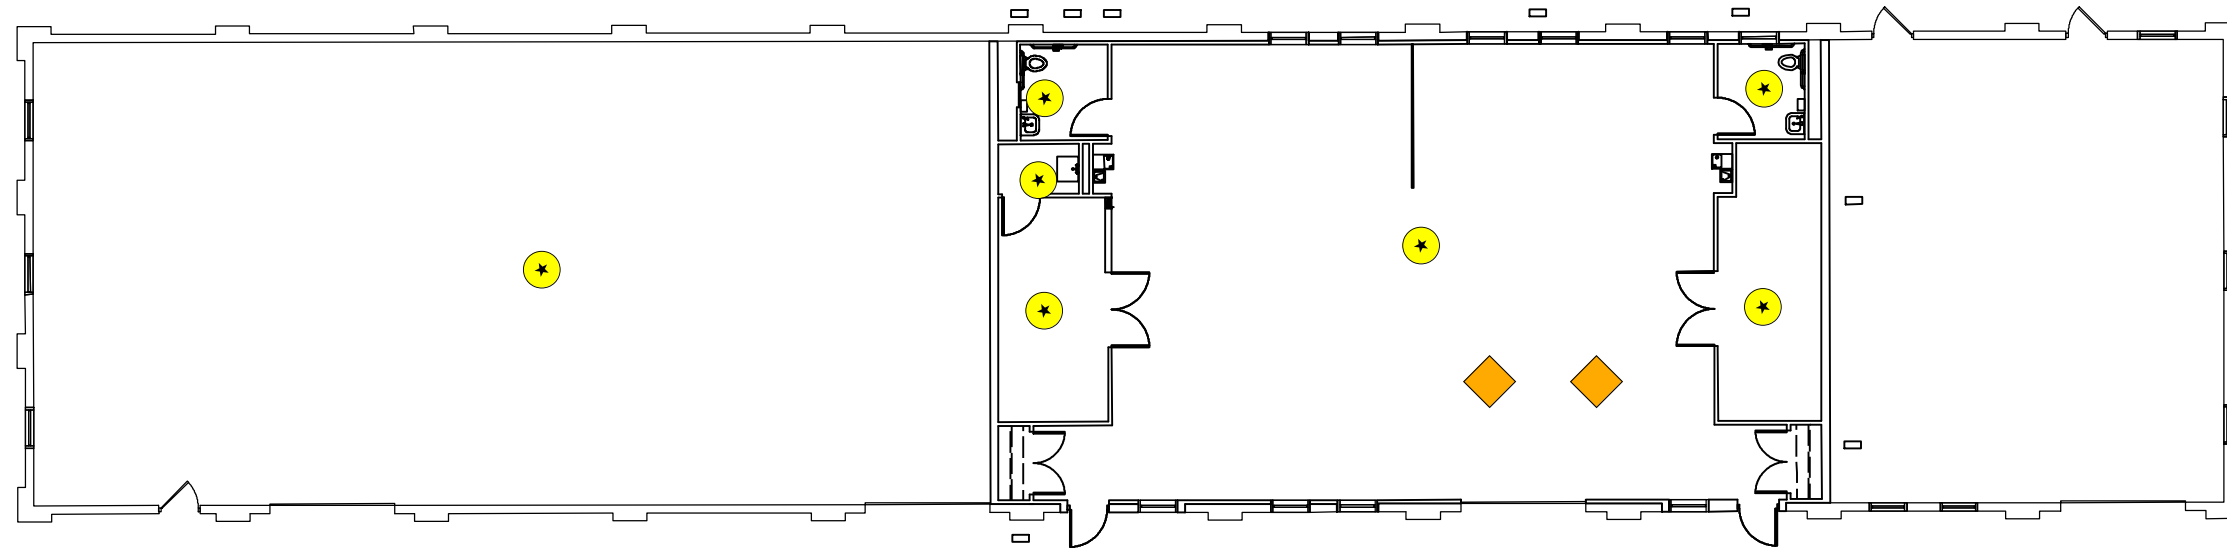-  Forced Air Heater
-  Light Ballast



Notes:

Floor plans georeferenced via headsup digitizing over 2015 aerial photography
Locations of air emissions, ODS, and FLBs georeferenced via floor plans



Scale: 1 inch = 15 feet
File: ST20
Date: 5/21/2019
Created By: Rosalie Hood,
Anne Timmreck,
Raina Ryan,
Alexandria Petrosch





**Rowan
University
&
Stockton
University**


**Figure ST21
Site Map with
Site Level Features
Sea Girt Museum
Bldg 66**



Legend

Sea Girt Building 66 1st Floor

 -  Light Ballast
-  No Access
-  No FLBs
-  Split Unit (Air Conditioner/Heater)



1 inch = 10 feet



Notes:

Floor plans georeferenced via headsup digitizing over 2015 aerial photography
Locations of air emissions, ODS, and FLBs georeferenced via floor plans








Scale: 1 inch = 10 feet
File: ST21
Date: 5/20/2019
Created By: Rosalie Hood,
Anne Timmreck,
Raina Ryan,
Alexandria Petrosch

**Rowan
University
&
Stockton
University**

**Figure ST22
Site Map with
Site Level Features
Sea Girt Armory
Bldg 7 Floor 1**

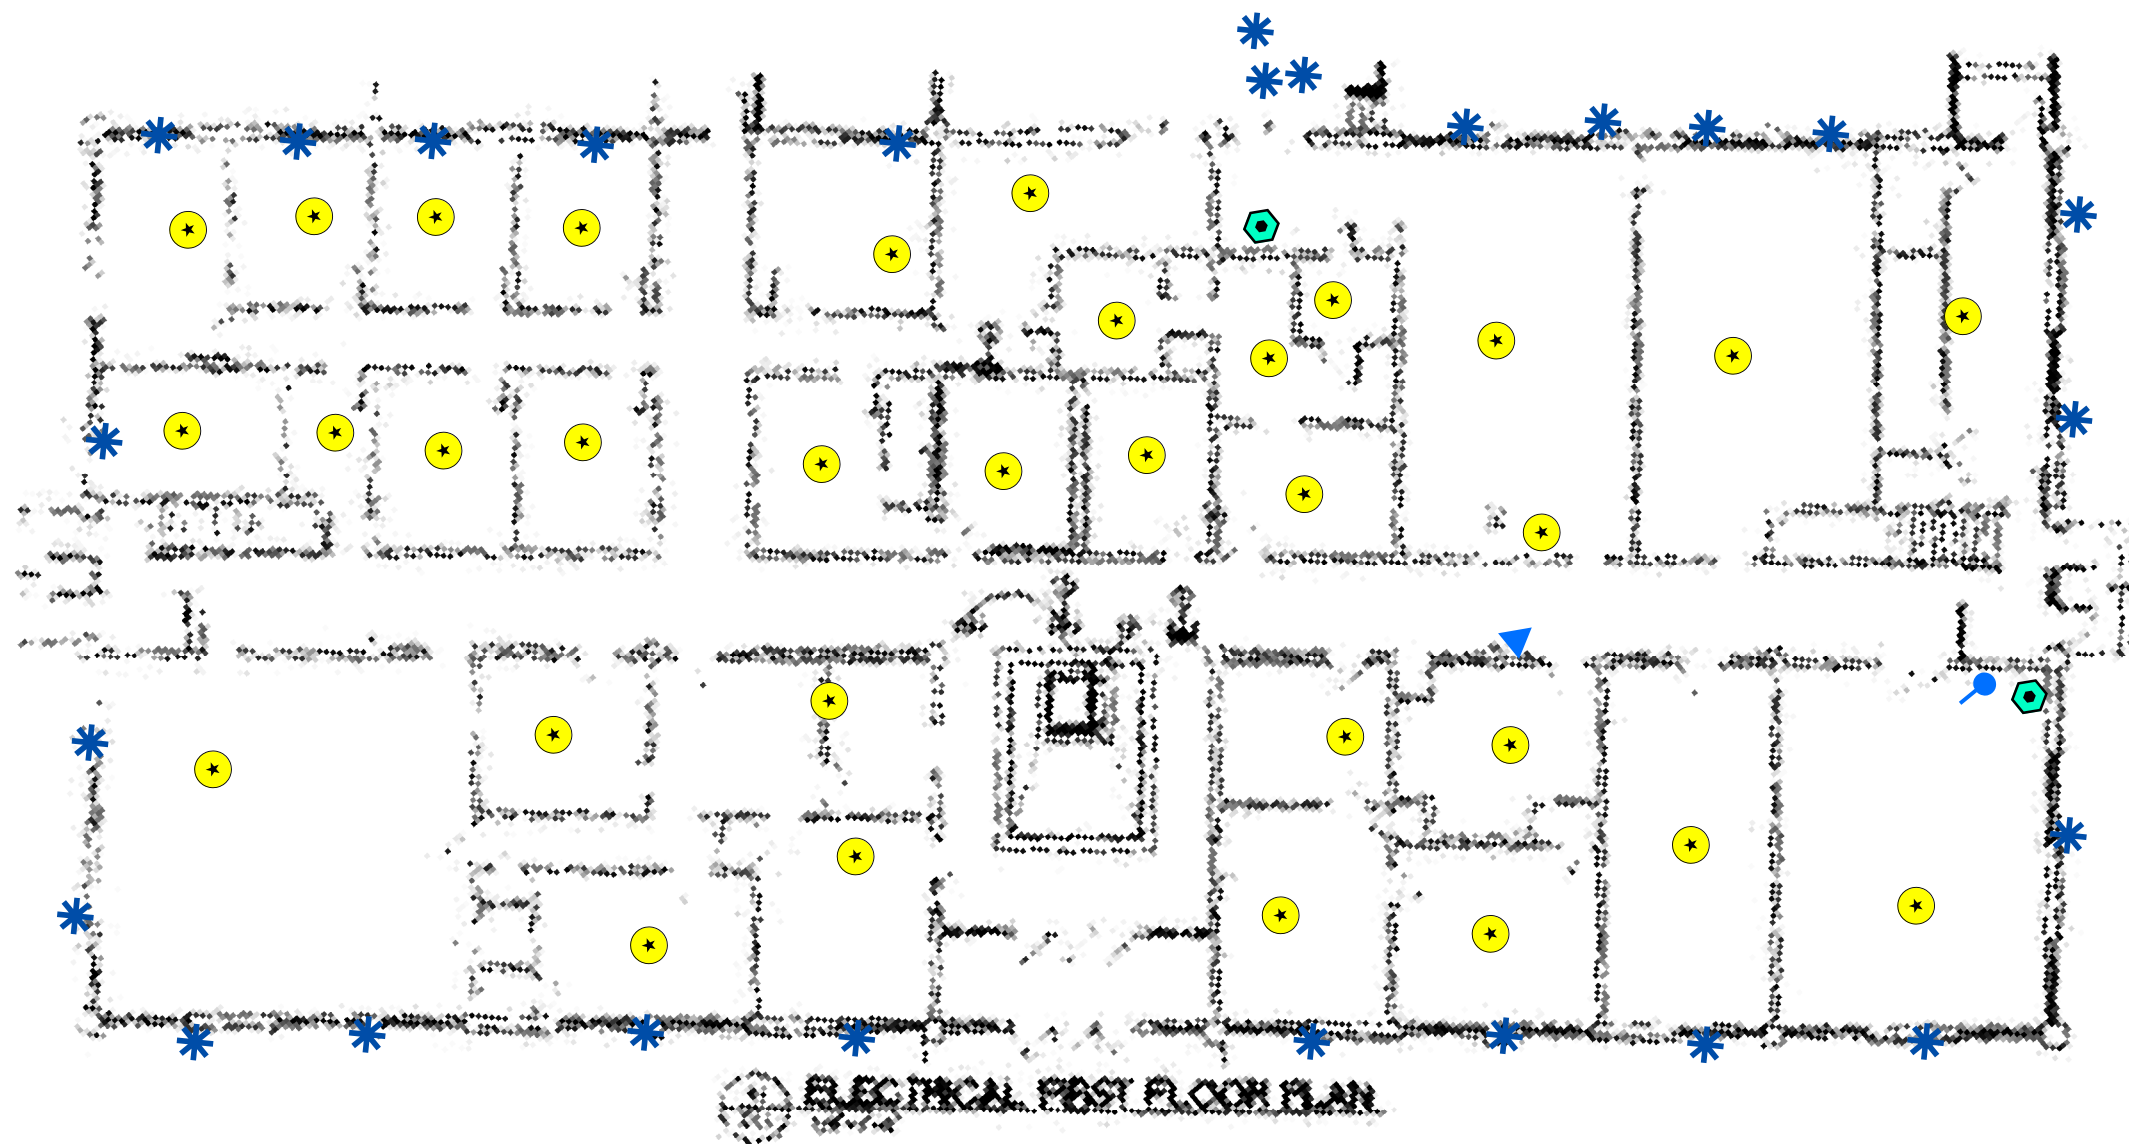
Legend

Sea Girt Building 7 1st Floor

-  Air Conditioning Unit
-  Drinking Water Fountain
-  Light Ballast
-  Refrigeration Unit
-  Water Cooler

0 7.5 15 30 Feet

1 inch = 15 feet



Notes:

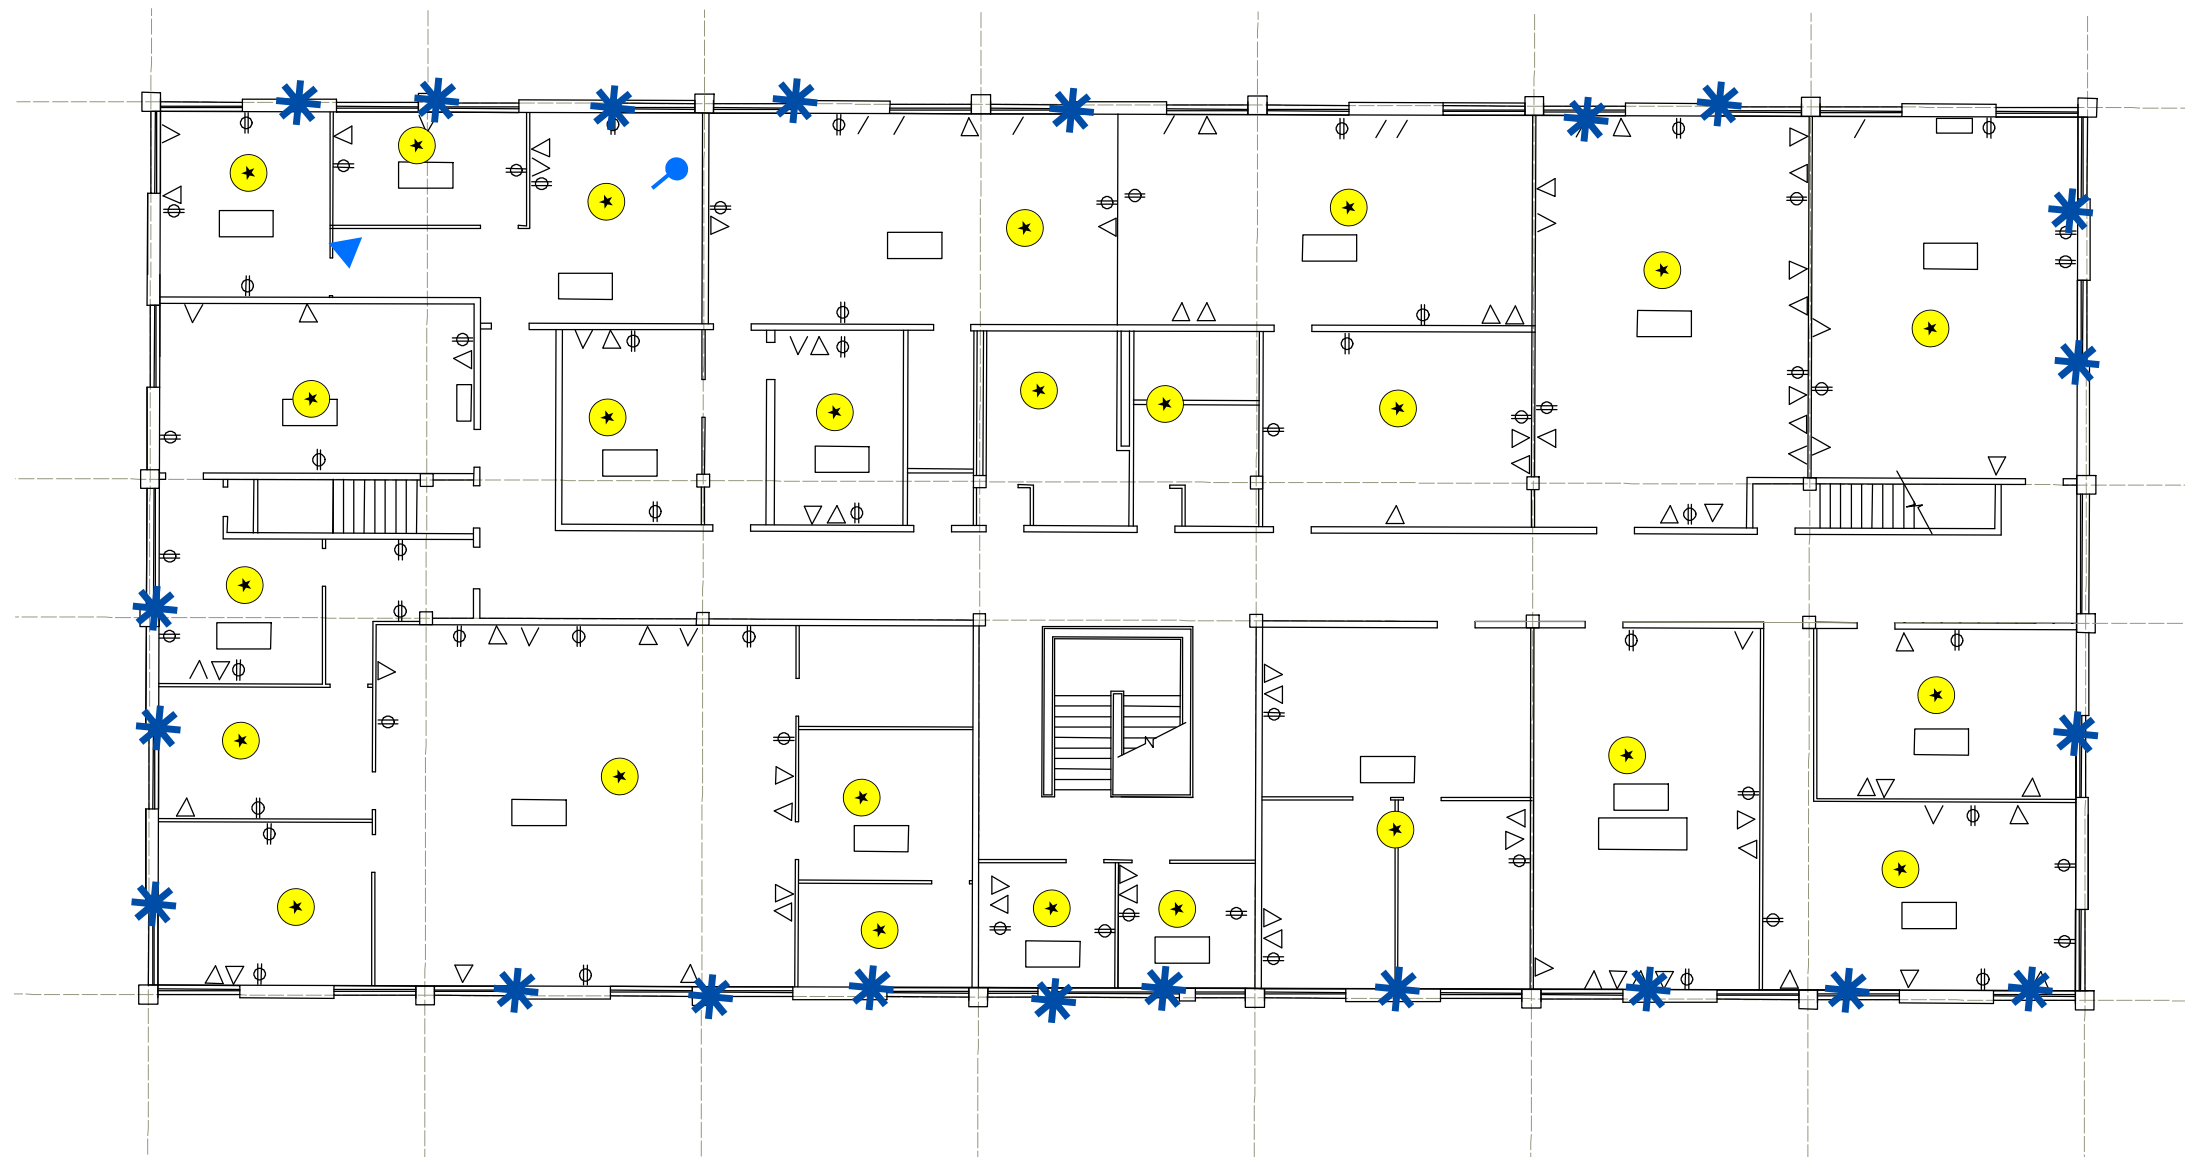
Floor plans georeferenced via headsup digitizing over 2015 aerial photography
Locations of air emissions, ODS, and FLBs georeferenced via floor plans



Scale: 1 inch = 15 feet
File: ST22
Date: 5/21/2019
Created By: Rosalie Hood,
Anne Timmreck,
Raina Ryan,
Alexandria Petrosch





**Rowan
University
&
Stockton
University**


**Figure ST23
Site Map with
Site Level Features
Sea Girt Armory
Bldg 7 Floor 2**




Legend

Sea Girt Building 7 2nd Floor

 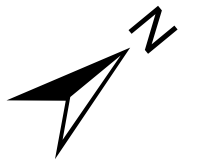-  Air Conditioning Unit
-  Drinking Water Fountain
-  Water Cooler
-  Light Ballast


 
 


1 inch = 15 feet



Notes:

Floor plans georeferenced via headsup digitizing over 2015 aerial photography
Locations of air emissions, ODS, and FLBs georeferenced via floor plans


	
	
	



Scale: 1 inch = 15 feet
File: ST23
Date: 5/21/2019
Created By: Rosalie Hood,
Anne Timmreck,
Raina Ryan,
Alexandria Petrosch




**Rowan
University
&
Stockton
University**

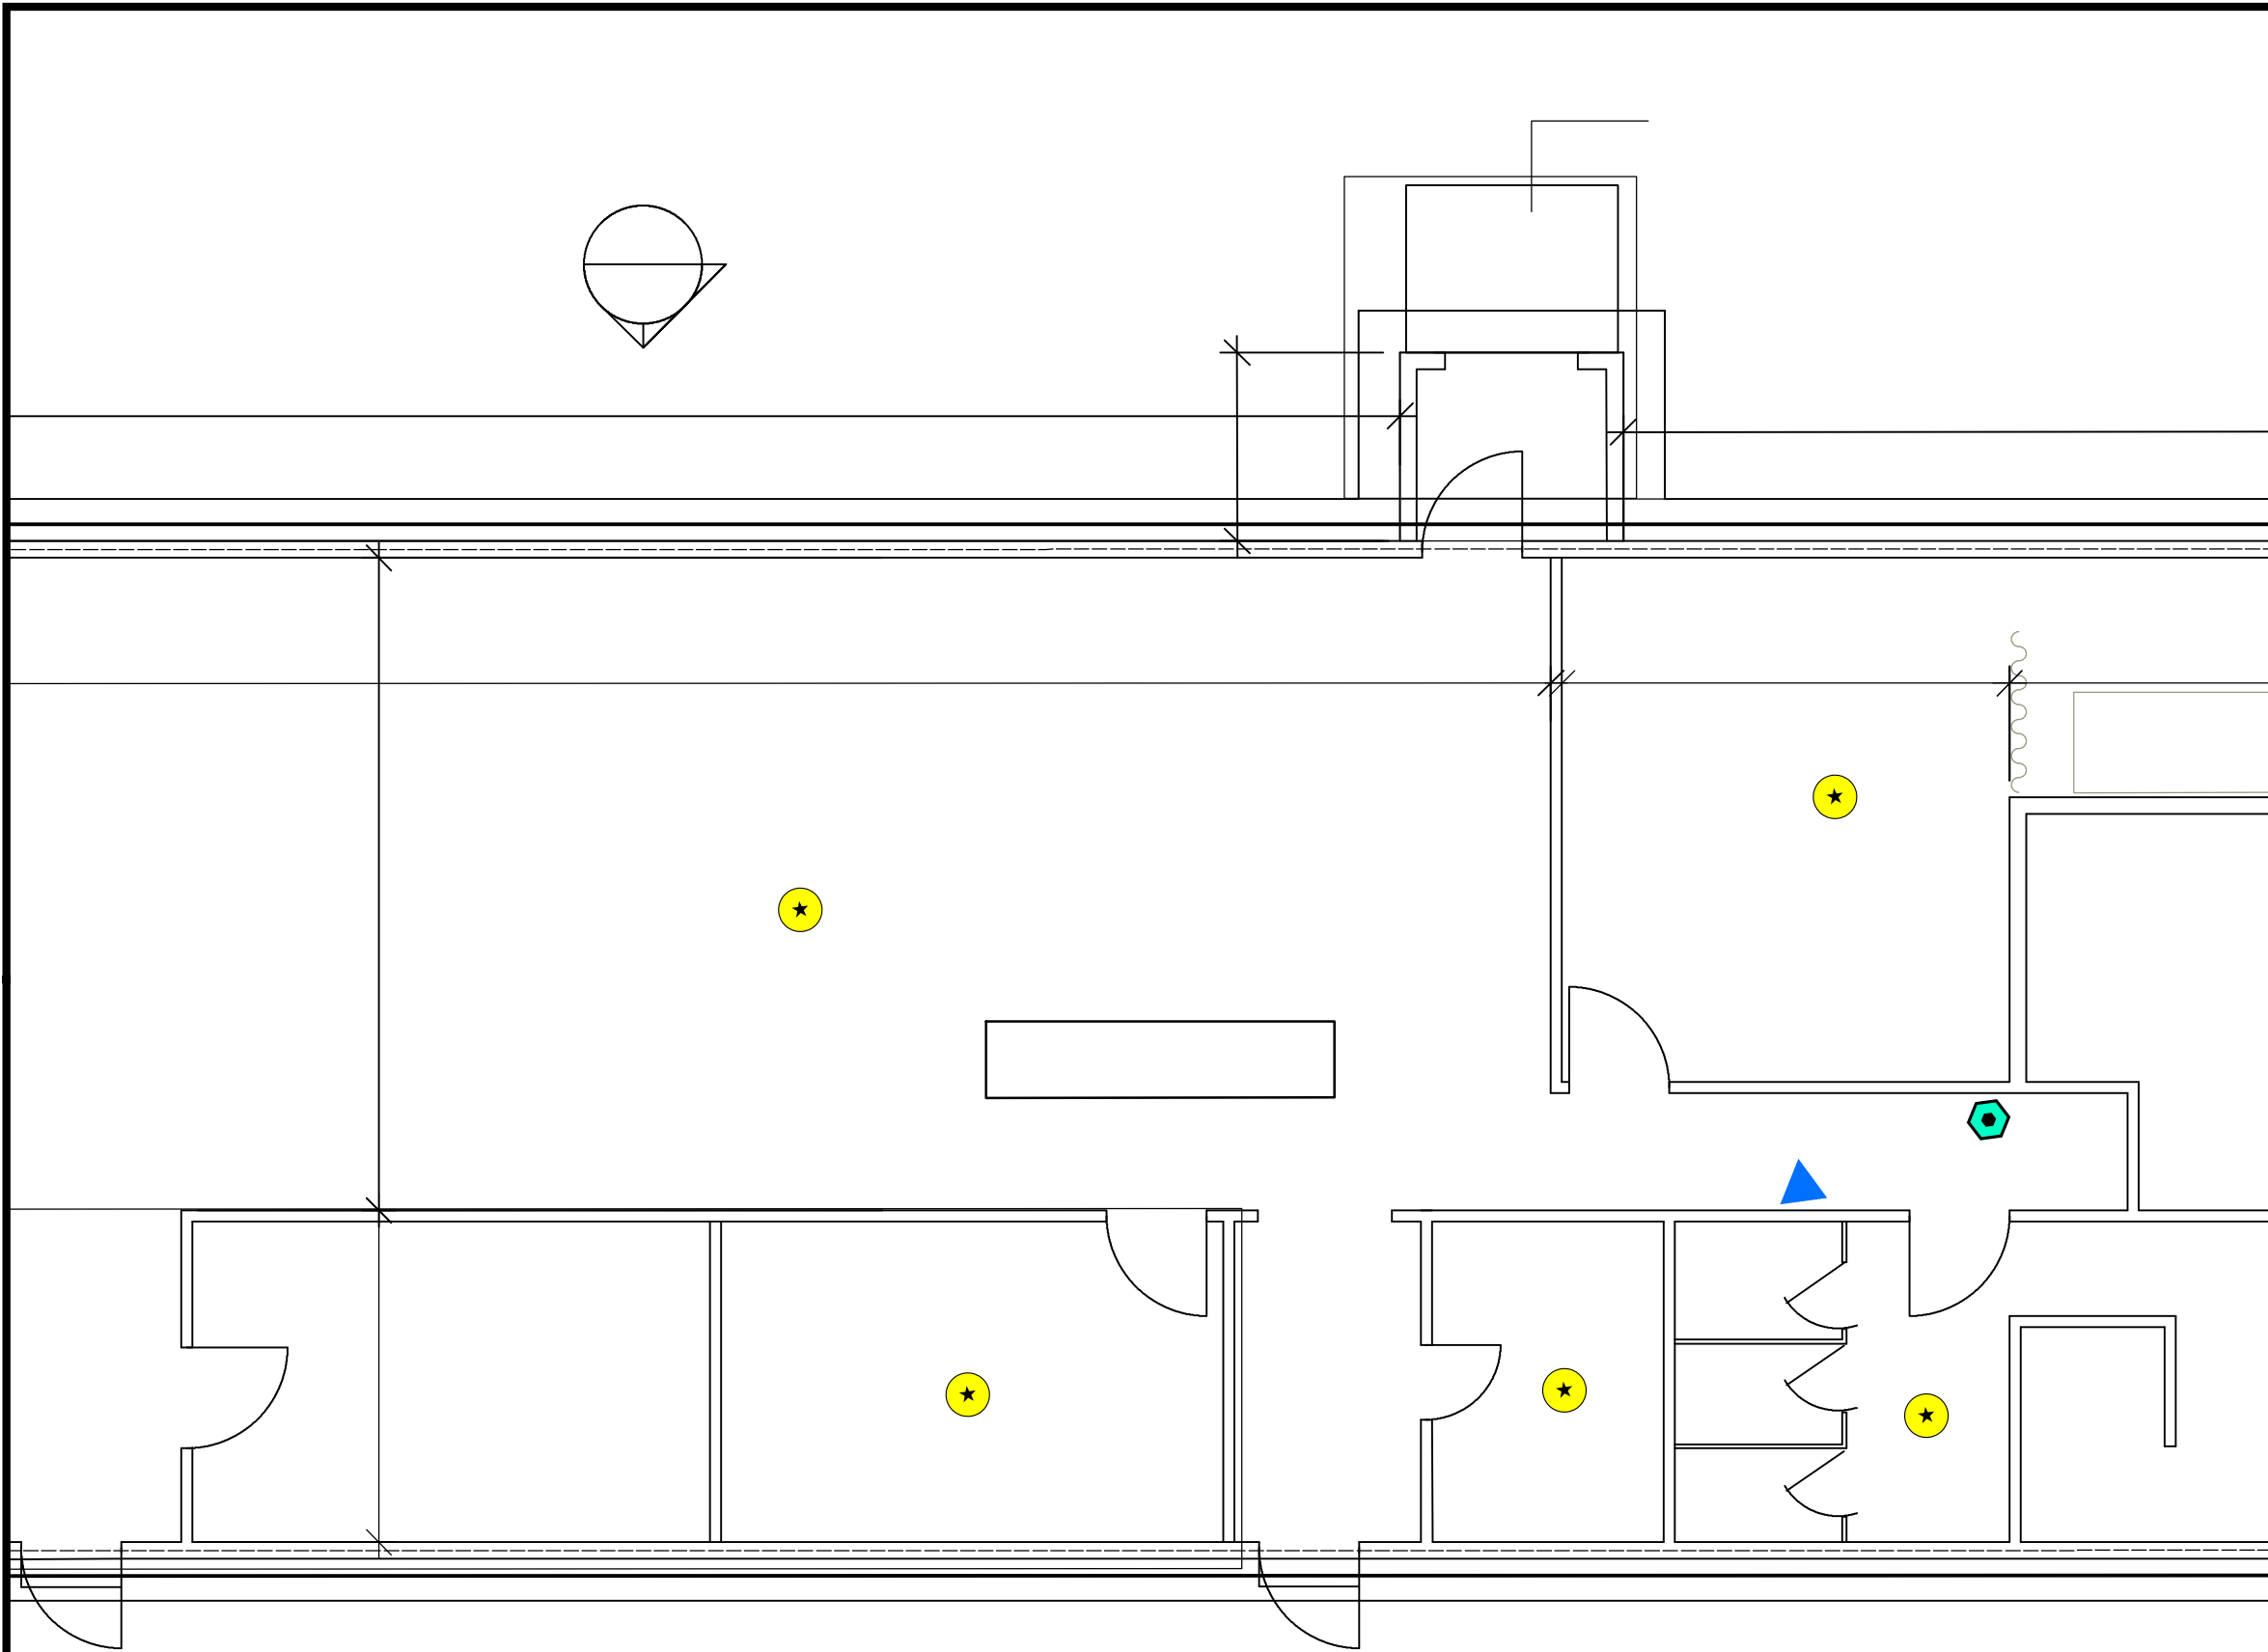
Figure ST24
Site Map with
Site Level Features
Sea Girt Classroom
Bldg 73



Legend

Sea Girt Building 73 1st Floor

 -  Drinking Water Fountain
-  Light Ballast
-  Refrigeration Unit



1 inch = 5 feet



Notes:

Floor plans georeferenced via headsup digitizing over 2015 aerial photography
 Locations of air emissions, ODS, and FLBs georeferenced via floor plans








Scale: 1 inch = 5 feet
 File: ST24
 Date: 5/21/2019
 Created By: Rosalie Hood,
 Anne Timmreck,
 Raina Ryan,
 Alexandria Petrosch

Rowan
University
&
Stockton
University

**Figure ST25
Site Map with
Site Level Features
Sea Girt Armory
Bldg 8
Floor 1**

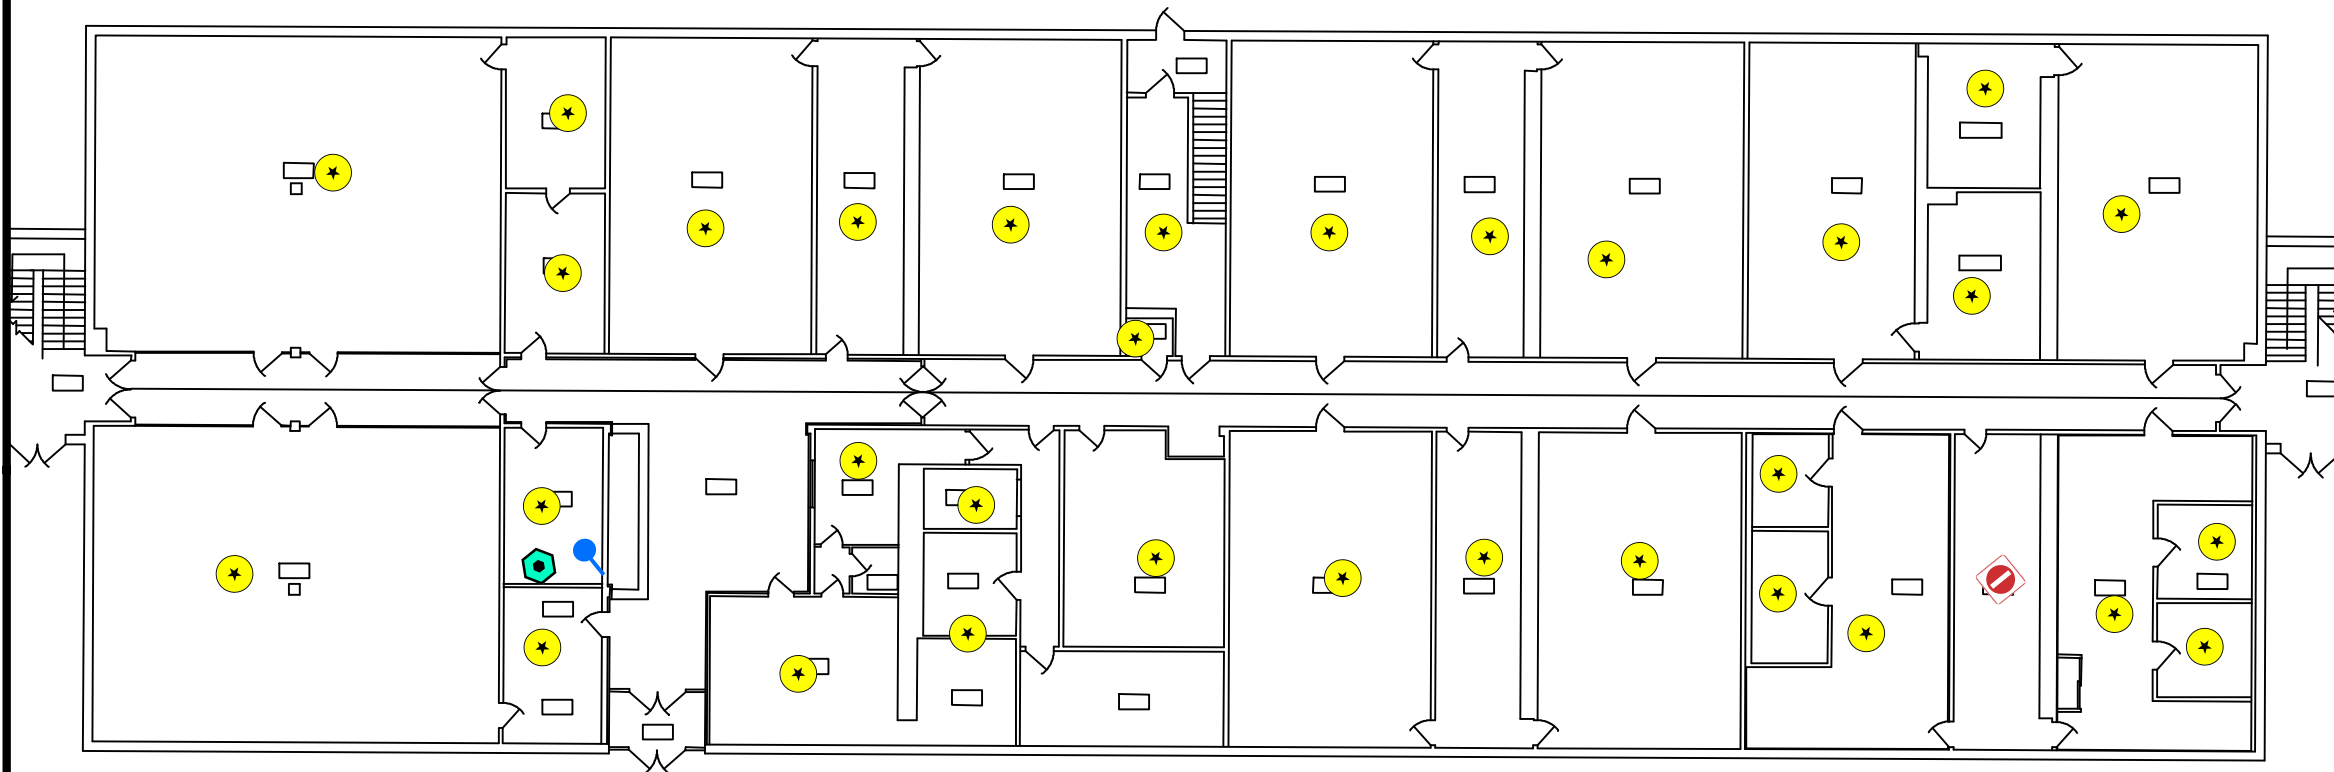
Legend

Sea Girt Building 8 1st Floor

-  Drinking Water Fountain
-  Light Ballast
-  No Access
-  Refrigeration Unit
-  Water Cooler

0 10 20 40 Feet

1 inch = 20 feet



Notes:

Floor plans georeferenced via headsup digitizing over 2015 aerial photography
Locations of air emissions, ODS, and FLBs georeferenced via floor plans



Scale: 1 inch = 20 feet
File: ST25
Date: 5/21/2019
Created By: Rosalie Hood,
Anne Timmreck,
Raina Ryan,
Alexandria Petrosch

**Rowan
University
&
Stockton
University**